
 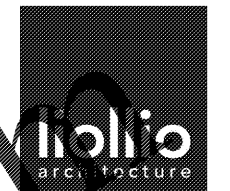


**KEY NOTES**


- ① PROVIDE 2" SCHEDULE 40 PVC BETWEEN SCE&G LIGHT POLES. PRIOR TO ANY WORK, COORDINATE LOCATIONS AND INSTALLATION WITH MARY ALTMAN (843-576-8310) AT SCE&G.
- ② APPROXIMATE LOCATION OF EXISTING UTILITY POWER POLE 173247 AND SCE&G PROVIDED HAND HOLE. COORDINATE PATHWAY WITH CIVIL DRAWINGS.
- ③ PROVIDE A 2"C STUB-OUT FOR FUTURE SCE&G LIGHT POLES
- ④ NEW GENERATOR LOCATION. GENERATOR SHALL BE MOUNTED ON EQUIPMENT PAD. COORDINATE WITH STRUCTURAL DRAWINGS FOR ADDITIONAL INFORMATION.
- ⑤ APPROXIMATE LOCATION OF SERVICE ENTRANCE. DISCONNECT SWITCH AND METER LOCATED ON EXTERIOR WALL.
- ⑥ PROVIDE THREE (3) 2" CONDUITS FROM TBB IN TOWN HALL MAIN TELECOMMUNICATIONS ROOM TO TBB IN MEETING/EVENT BUILDING ELECTRICAL MECH ROOM.
- ⑦ PROVIDE THREE (3) 2" CONDUITS FROM TBB IN TOWN HALL MAIN TELECOMMUNICATIONS ROOM TO UTILITY RIGHT-OF-WAY (ROW). COORDINATE EXACT LOCATION OF UTILITY ROW WITH SERVICE PROVIDER.
- ⑧ POWER TO FLAG POLE LOCATION FOR FLAG POLE LIGHT (LIGHTS OTHERS). PROVIDE 2#12, #12G IN 1"C. CONNECT TO EXTERIOR SIGNAGE LIGHTING CIRCUIT. COORDINATE EXACT LOCATION WITH LANDSCAPING AND CIVIL.
- ⑨ DIRECTIONAL BORE CONDUITS UNDER EXISTING ROADWAY PER DOT REQUIREMENTS. COORDINATE WITH OTHER UTILITY TRENCHING.
- ⑩ MAIN ELECTRICAL ROOM.

**GENERAL NOTES**

1. COORDINATE ALL REQUIREMENTS WITH UTILITY COMPANY, CIVIL DRAWINGS, LANDSCAPE DRAWINGS, AND ALL OTHER TRADES PRIOR TO ANY WORK. ALL ROUTING SHALL BE COORDINATED WITH EXISTING TREES AND TREE ROOTS.
2. MAINTAIN ALL UTILITY REQUIRED CLEARANCES BETWEEN SERVICES.
3. SCE&G CONTACT IS ELIZABETH THOMAS (843) 576-8170.



147 Wappoo Creek Drive Suite 400  
Charleston, SC 29412  
P 843.762.2222

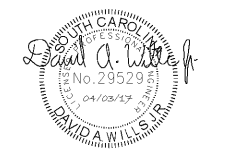


Revision	Date	Description

Town of James Island  
**James Island  
Town Hall**  
1122/1126 Dills Bluff Road  
Charleston, SC.

Project Number:	15169-00
Checked By:	DAW
Drawn By:	MCG
Date:	04/03/17
Scale:	1" = 20'-0"

**E100**  
**ELECTRICAL SITE  
PLAN**

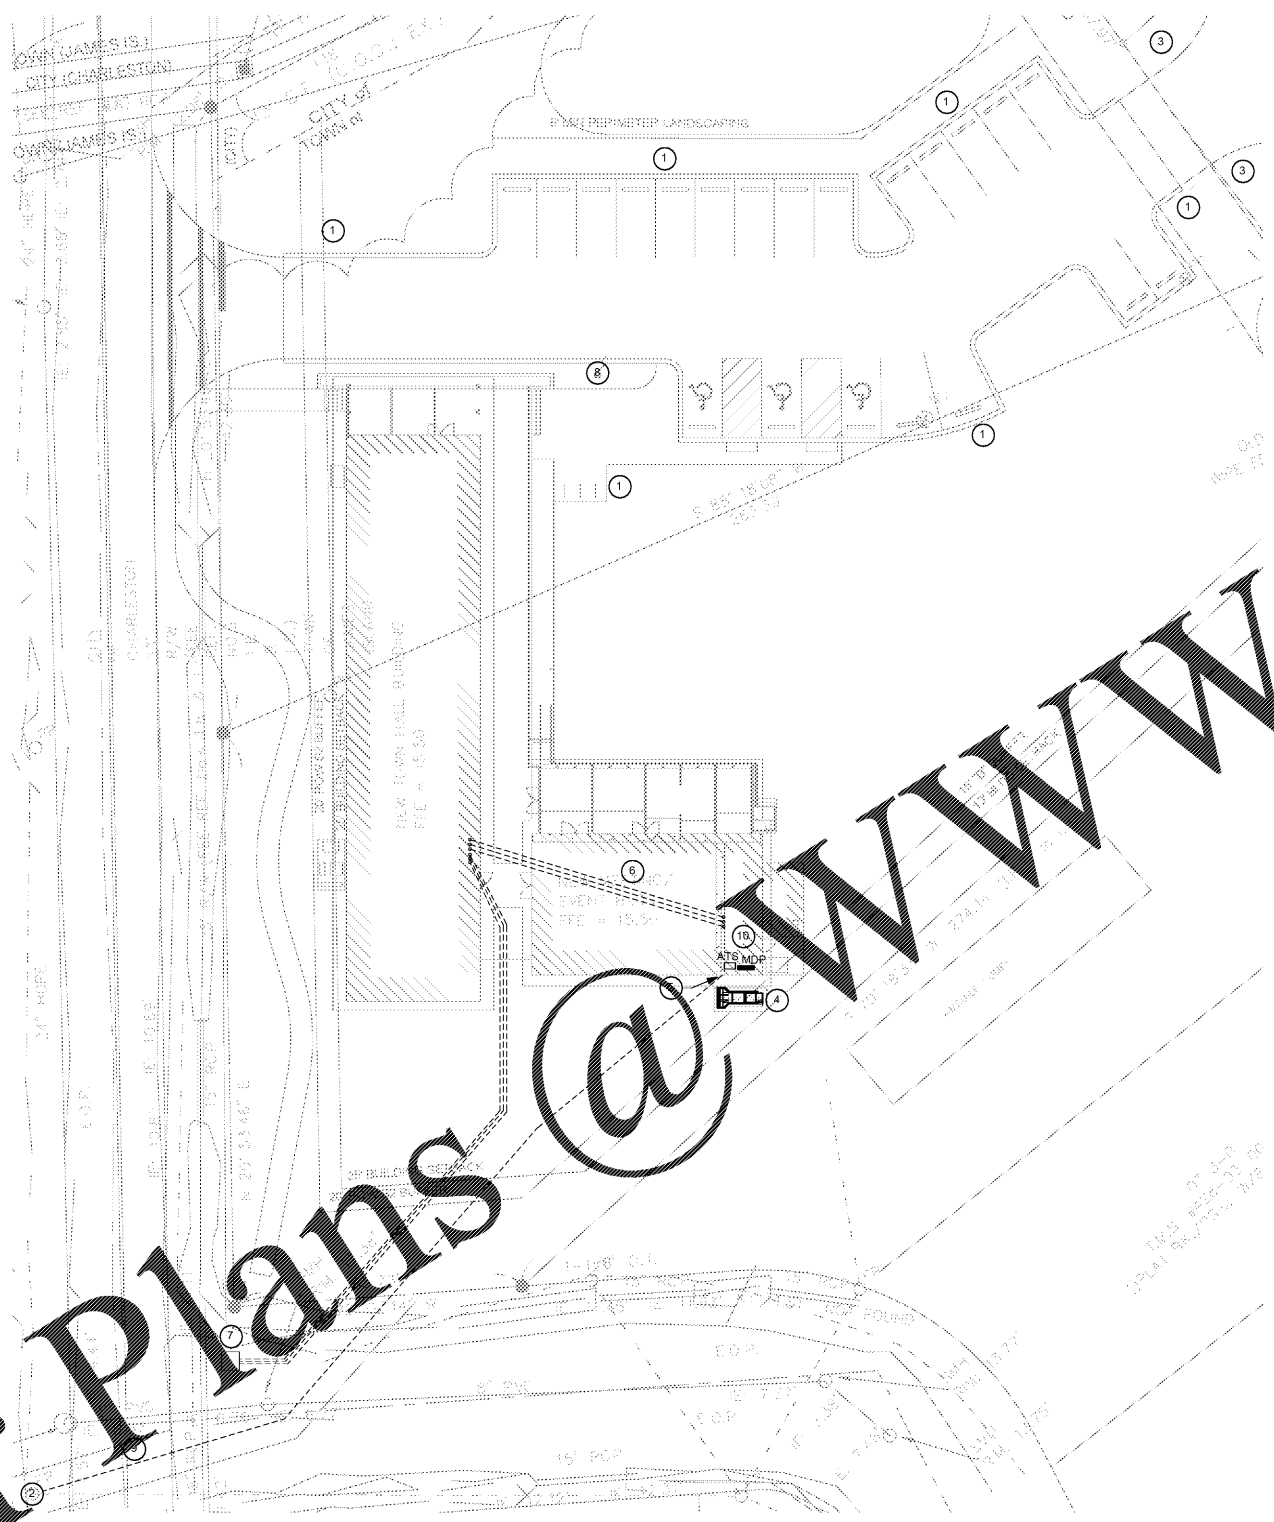

1 E100 - ELECTRICAL SITE PLAN  
E100 SCALE: 1" = 20'-0"

Order Plans @ [www.lidivine.com](http://www.lidivine.com)