


Order Plans @

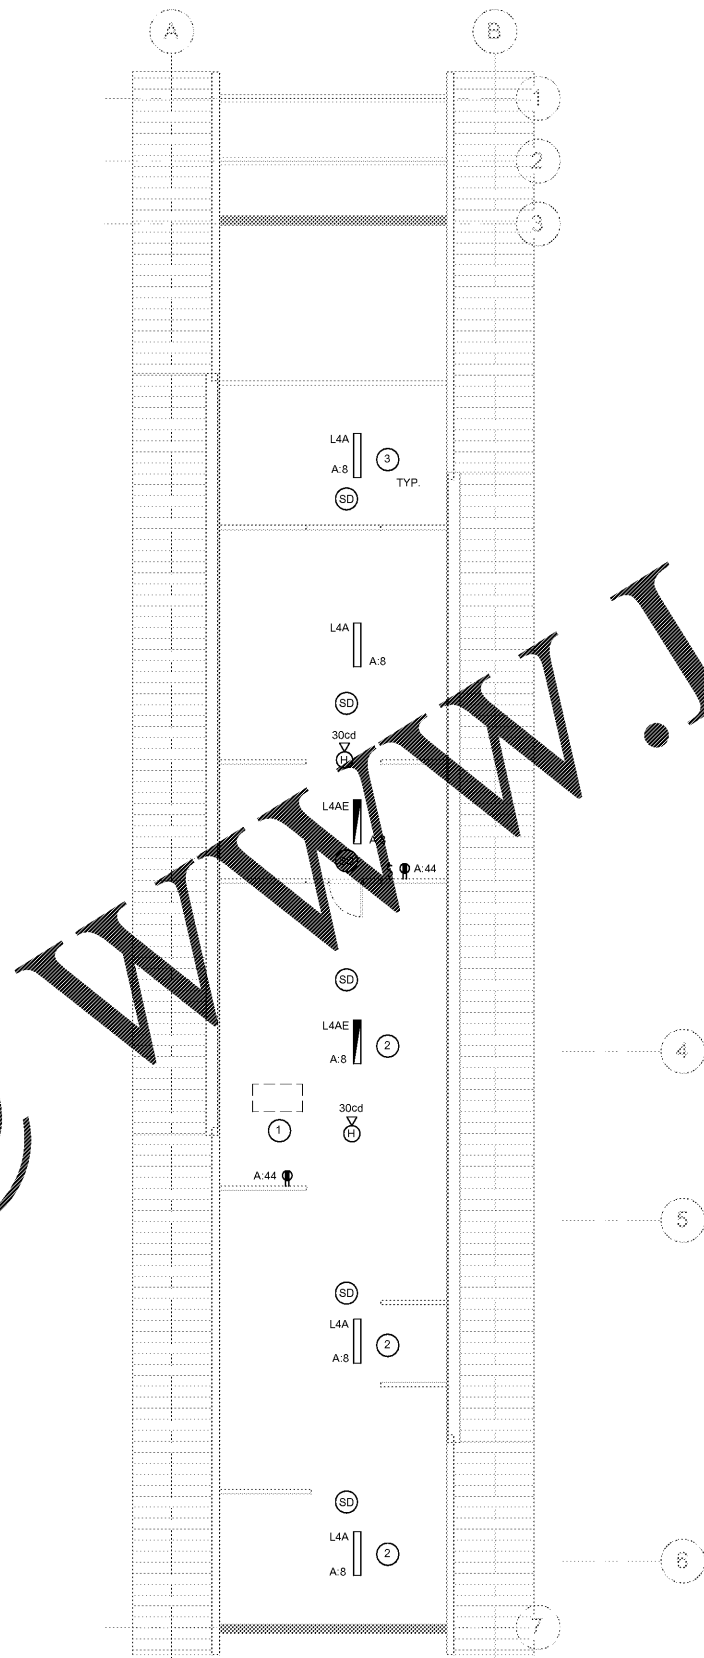


1 ATTIC ELECTRICAL PLAN
E104 SCALE: 1/8" = 1'-0"


KEY NOTES

- ① ATTIC ACCESS. REFER TO ARCHITECTURAL PLANS FOR EXACT LOCATION.
- ② FIXTURES SHALL BE CONTROLLED FROM FIRST FLOOR LIGHT SWITCH LOCATED IN CORRIDOR COR 1.
- ③ ALL ATTIC FIXTURES SHALL BE SURFACE MOUNTED TO STRUCTURE.

GENERAL NOTES

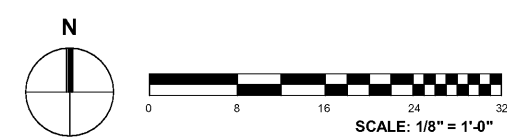

147 Wappoo Creek Drive Suite 400
Charleston, SC 29412
P 843.762.2222

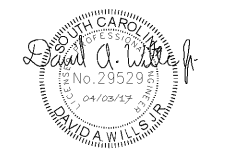

Revision	Date	Description

Town of James Island
**James Island
Town Hall**
1122/1126 Dills Bluff Road
Charleston, SC.

Project Number:	15169-00
Checked By:	DAW
Drawn By:	MCG
Date:	04/03/17
Scale:	1/8" = 1'-0"

E104
**ATTIC ELECTRICAL
PLAN**