


KEY NOTES

- ① LIGHT FIXTURE SHALL BE MOUNTED TO TOP EDGE OF STRUCTURAL STEEL CHANNEL. TYPICAL FOR ALL TYPE 'N' FIXTURES. REFER TO ARCHITECTURAL DETAIL 7/A801 FOR MOUNTING INFORMATION.

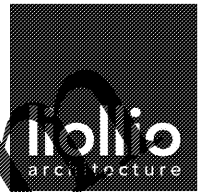

147 Wappoo Creek Drive Suite 400
Charleston, SC 29412
P 843.762.2222




GENERAL NOTES

Revision Date	Description

Town of James Island
**James Island
Town Hall**
1122/1126 Dills Bluff Road
Charleston, SC.

Project Number:	15169-00
Checked By:	DAW
Drawn By:	MCG
Date:	04/03/17
Scale:	1/4" = 1'-0"

E500
ELECTRICAL
ELEVATIONS &
ENLARGED VIEWS

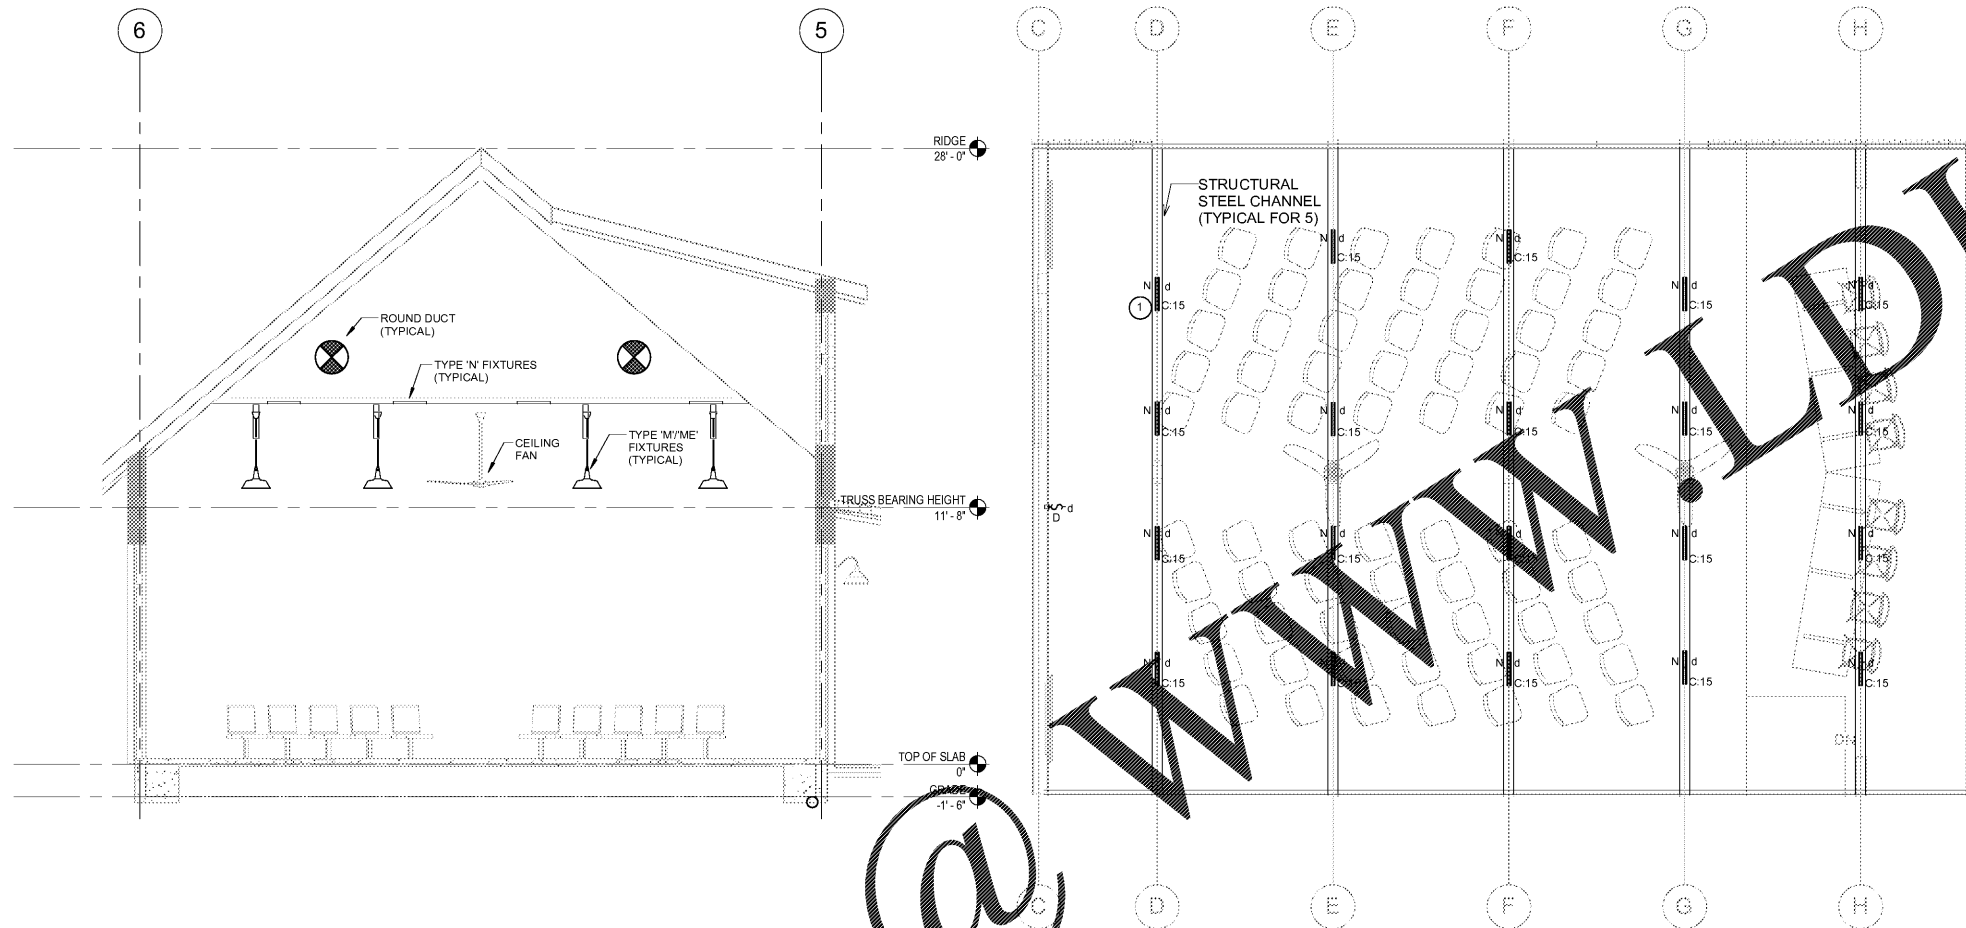

① COUNCIL CHAMBERS ELEVATION
E500 SCALE: 1/4" = 1'-0"

② COUNCIL CHAMBERS CEILING ACCENT LIGHTING PLAN
E500 SCALE: 1/4" = 1'-0"

Order Plans @