



FLEX DUCT SUPPORT DETAIL

NOT TO SCALE

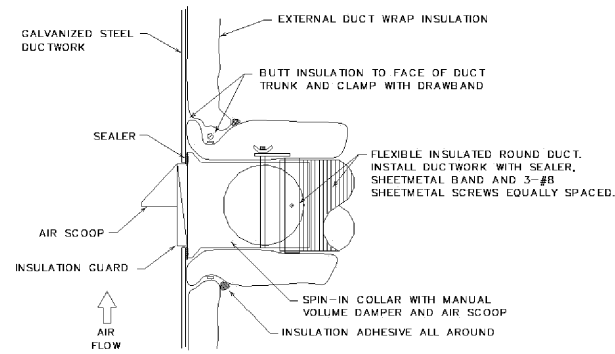


ROUND DUCT SPIN-IN DETAIL

NOT TO SCALE

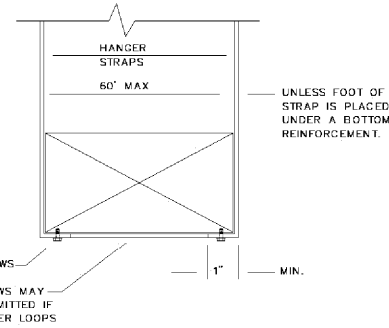


DUCT SUPPORT DETAILS

NOT TO SCALE

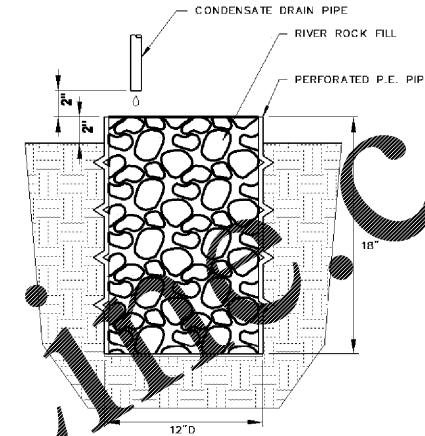


CONDENSATE FRENCH DRAIN DETAIL

NOT TO SCALE

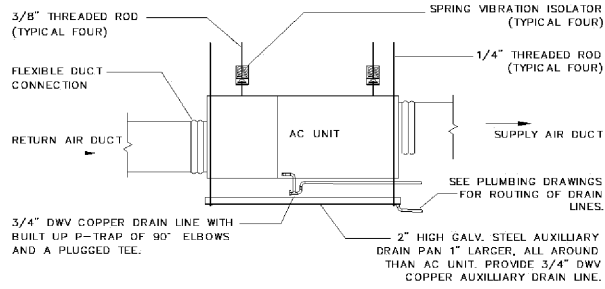


AIR HANDLER HANGING DETAIL

NOT TO SCALE

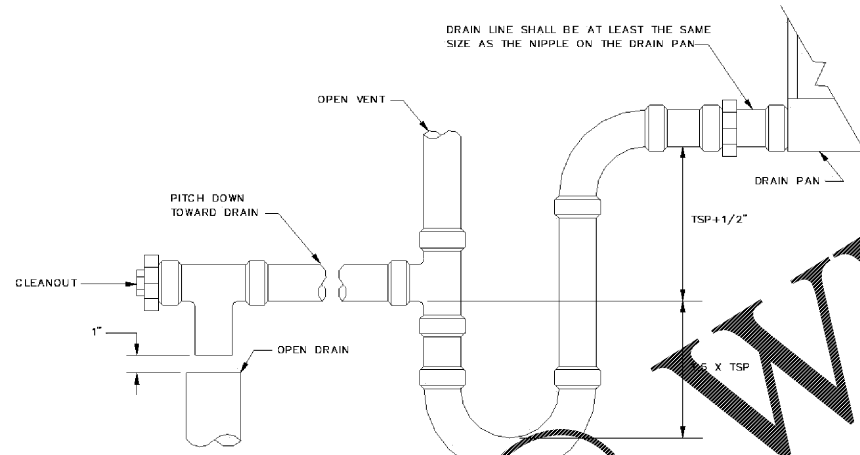


TYPICAL A/C UNIT DRAIN TRAP

NOT TO SCALE

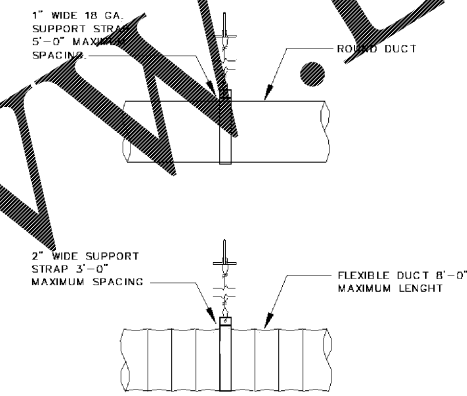


DUCT SUPPORT DETAILS

NOT TO SCALE

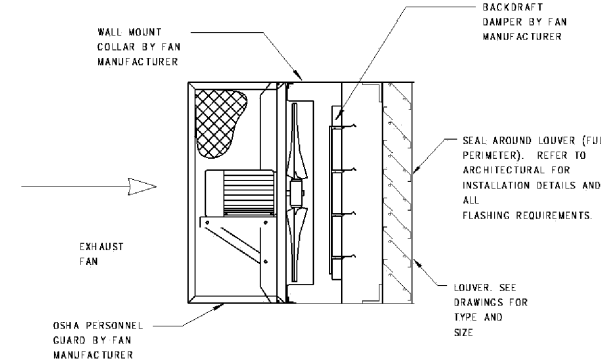


SIDEWALL FAN DETAIL

NOT TO SCALE

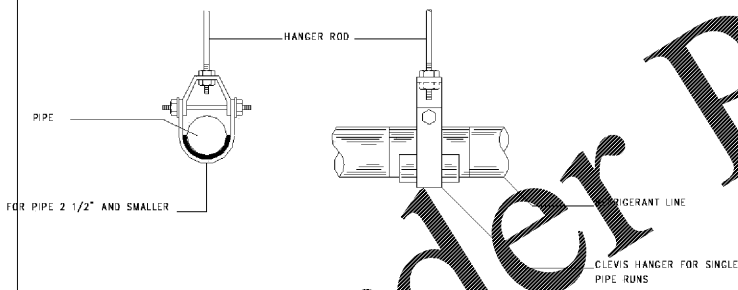


REFRIGERANT LINE SUPPORT DETAIL

NOT TO SCALE

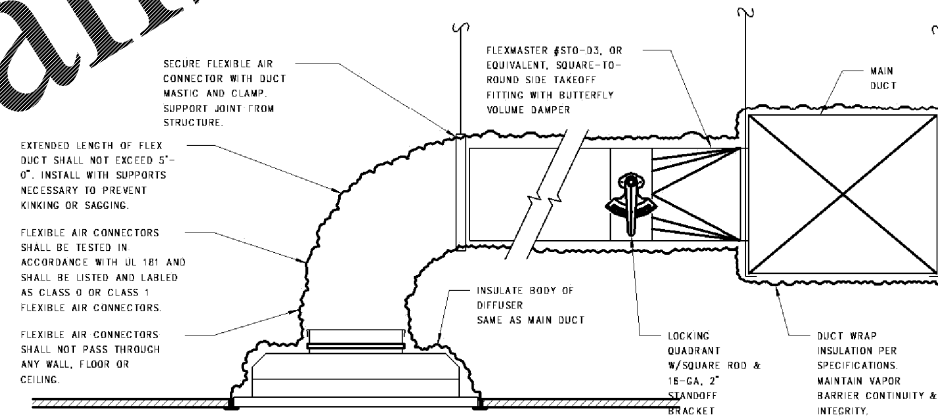

FLEXIBLE AIR CONNECTION DETAIL

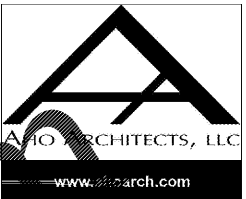

Express Oil Change & Tire Engineers
Single Building Right Hand Oil Change
Augusta, GA

FINAL

No.	Description	Date

© 2017 Aho Architects, LLC. All Rights Reserved.

MECHANICAL DETAILS

Project number 16031
Date 03/29/17
Drawn by JJH
Checked by CJD

M201

Scale 1/8" = 1'-0"

3/29/2017 1:31:53 PM