

Express Oil Change & Tire Engineers
Single Building Right Hand Oil Change
Augusta, GA

FINAL


No.	Description	Date

© 2017 Aho Architects, LLC. All Rights Reserved.

PLUMBING FLOOR PLAN

Project number	16031
Date	03/29/17
Drawn by	JJH
Checked by	CJD

P101
Scale 1/4" = 1'-0"

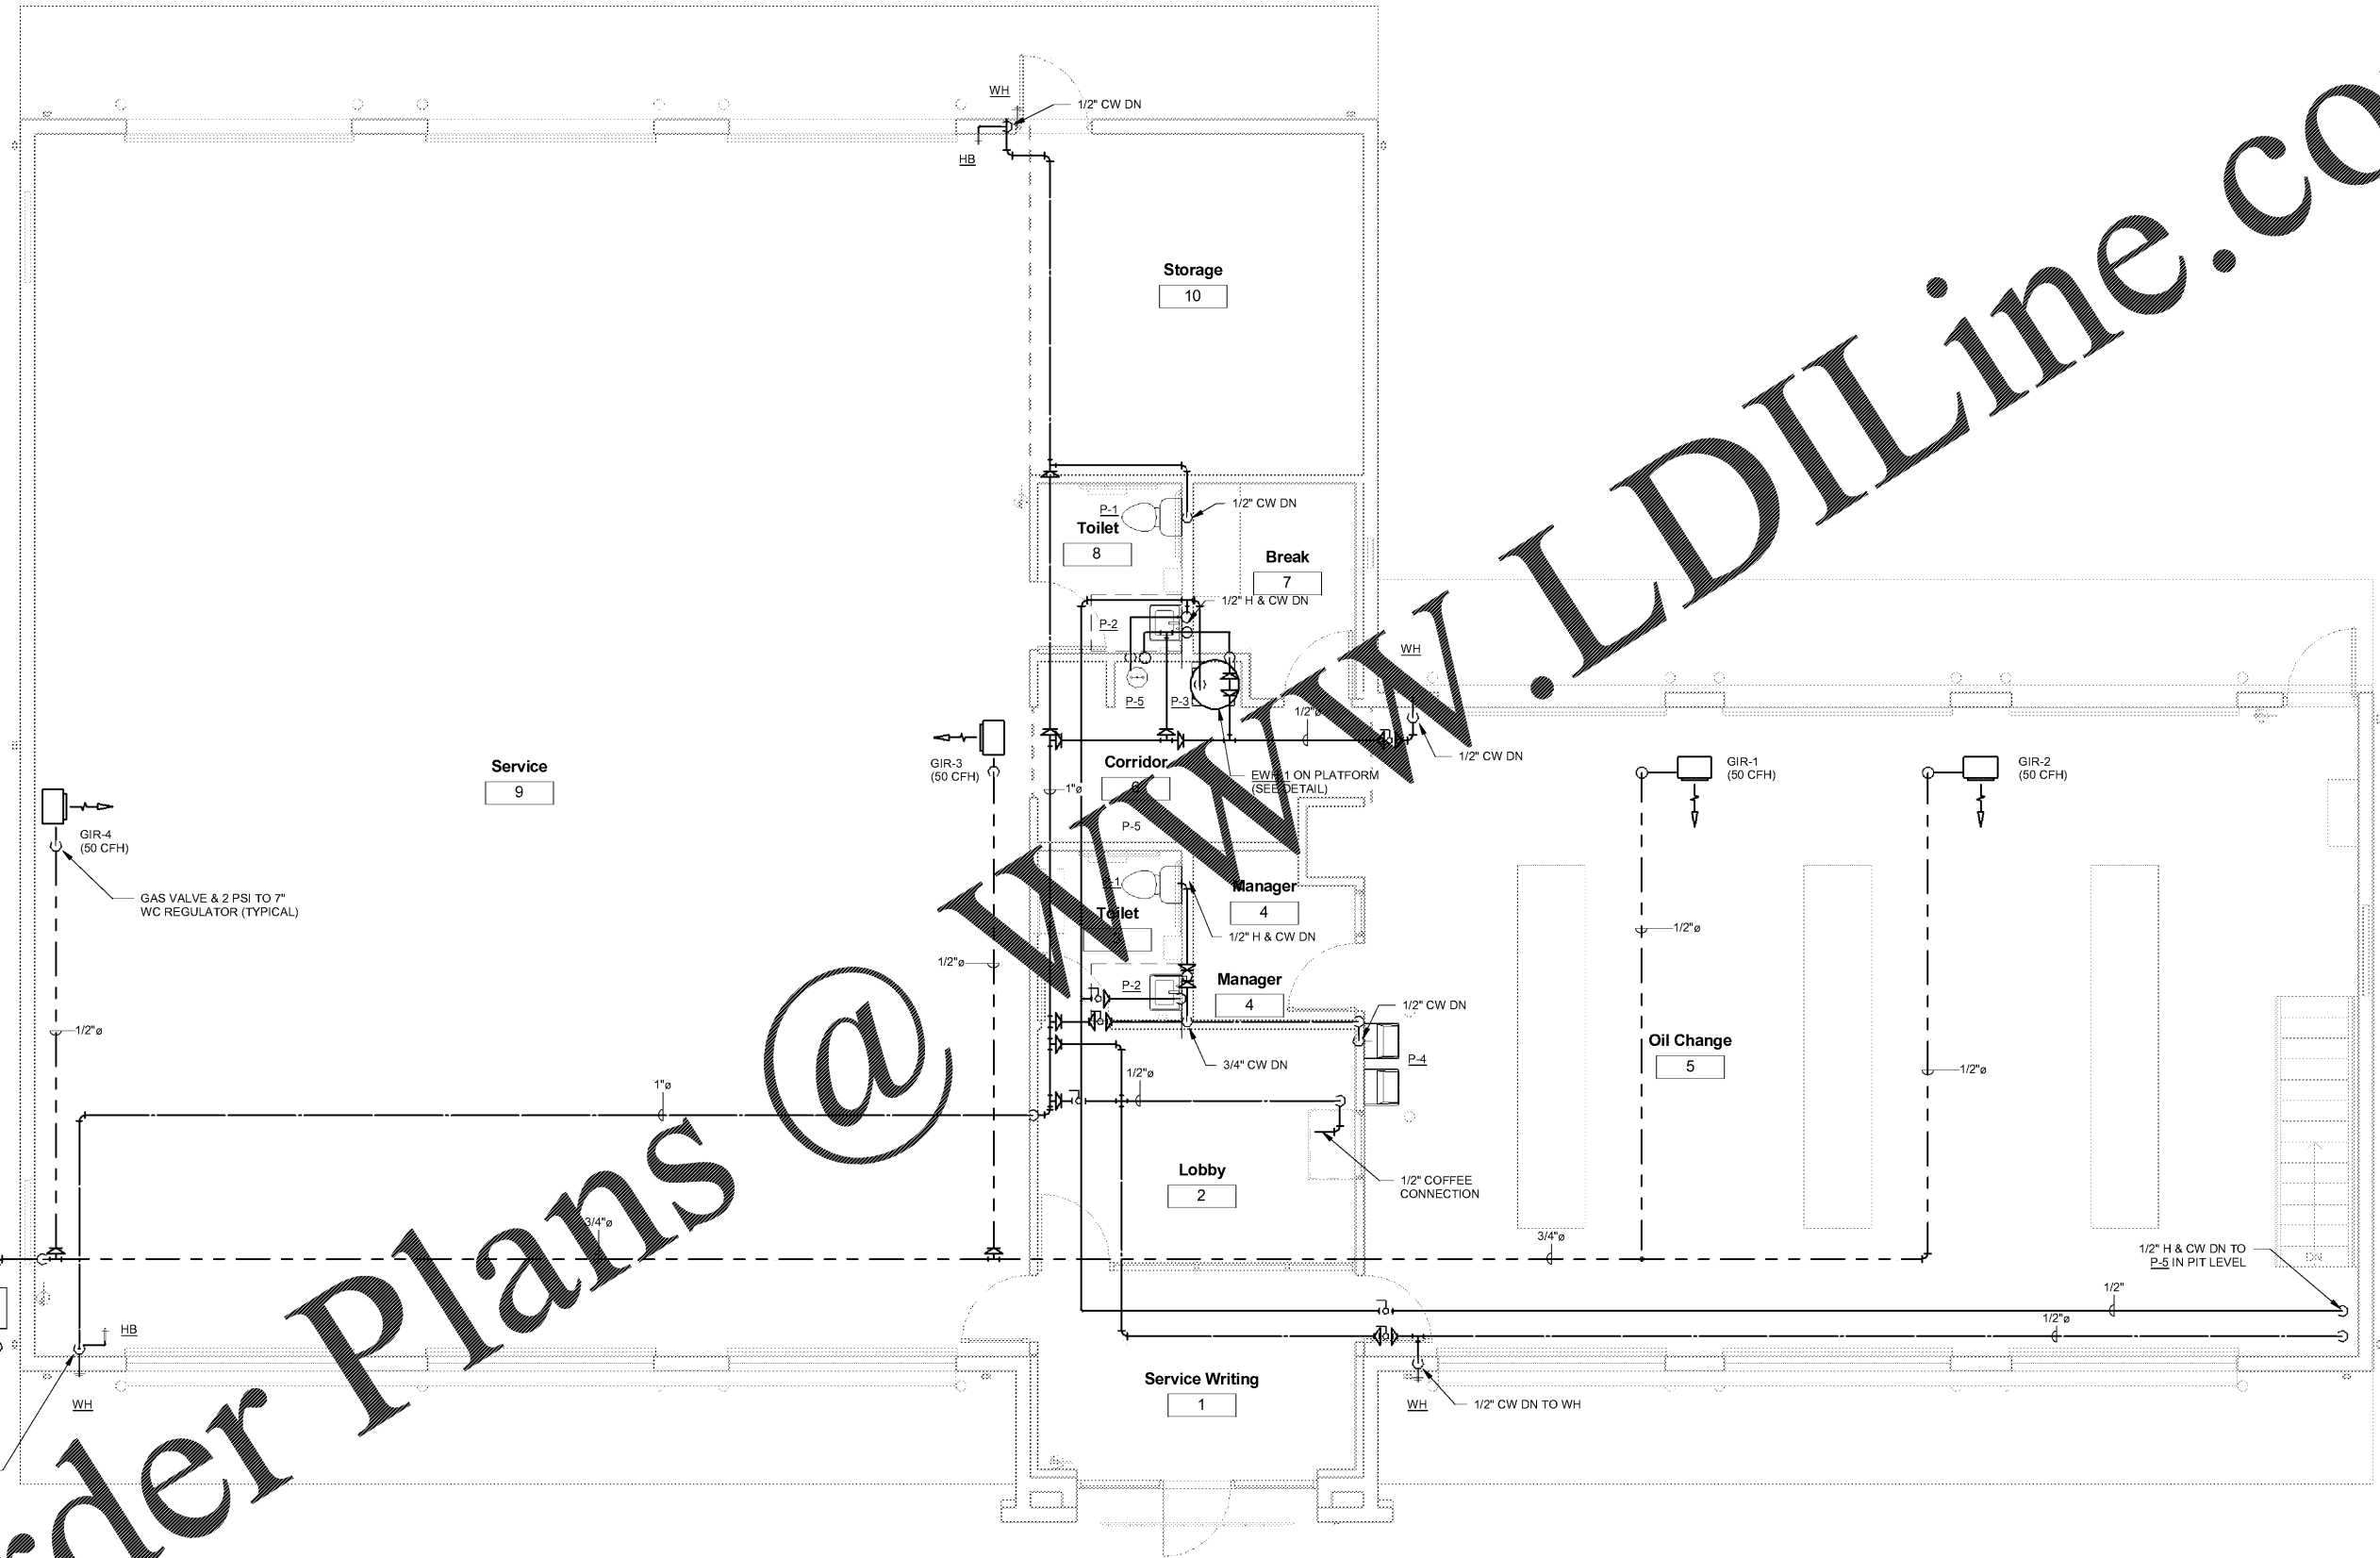

GAS METER:
INLET PRESSURE - VERIFY
OUTLET PRESSURE - 2 PSI
TOTAL FLOW - 200 CFM
LONGEST RUN - 125'

1" WATER METER WITH PRV:
MAIN BALL VALVE 18" A.F.F.

PLUMBING FLOOR PLAN
1/4" = 1'-0"

