

Express Oil Change & Tire Engineers
Single Building Right Hand Oil Change
Augusta, GA

FINAL

No.	Description	Date



© 2017 Aho Architects, LLC. All Rights Reserved.

LIGHTING FLOOR PLAN

Project number 16031
Date 03/29/2017
Drawn by MAH
Checked by ATV

E201

Scale As indicated

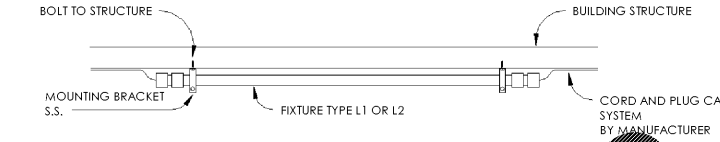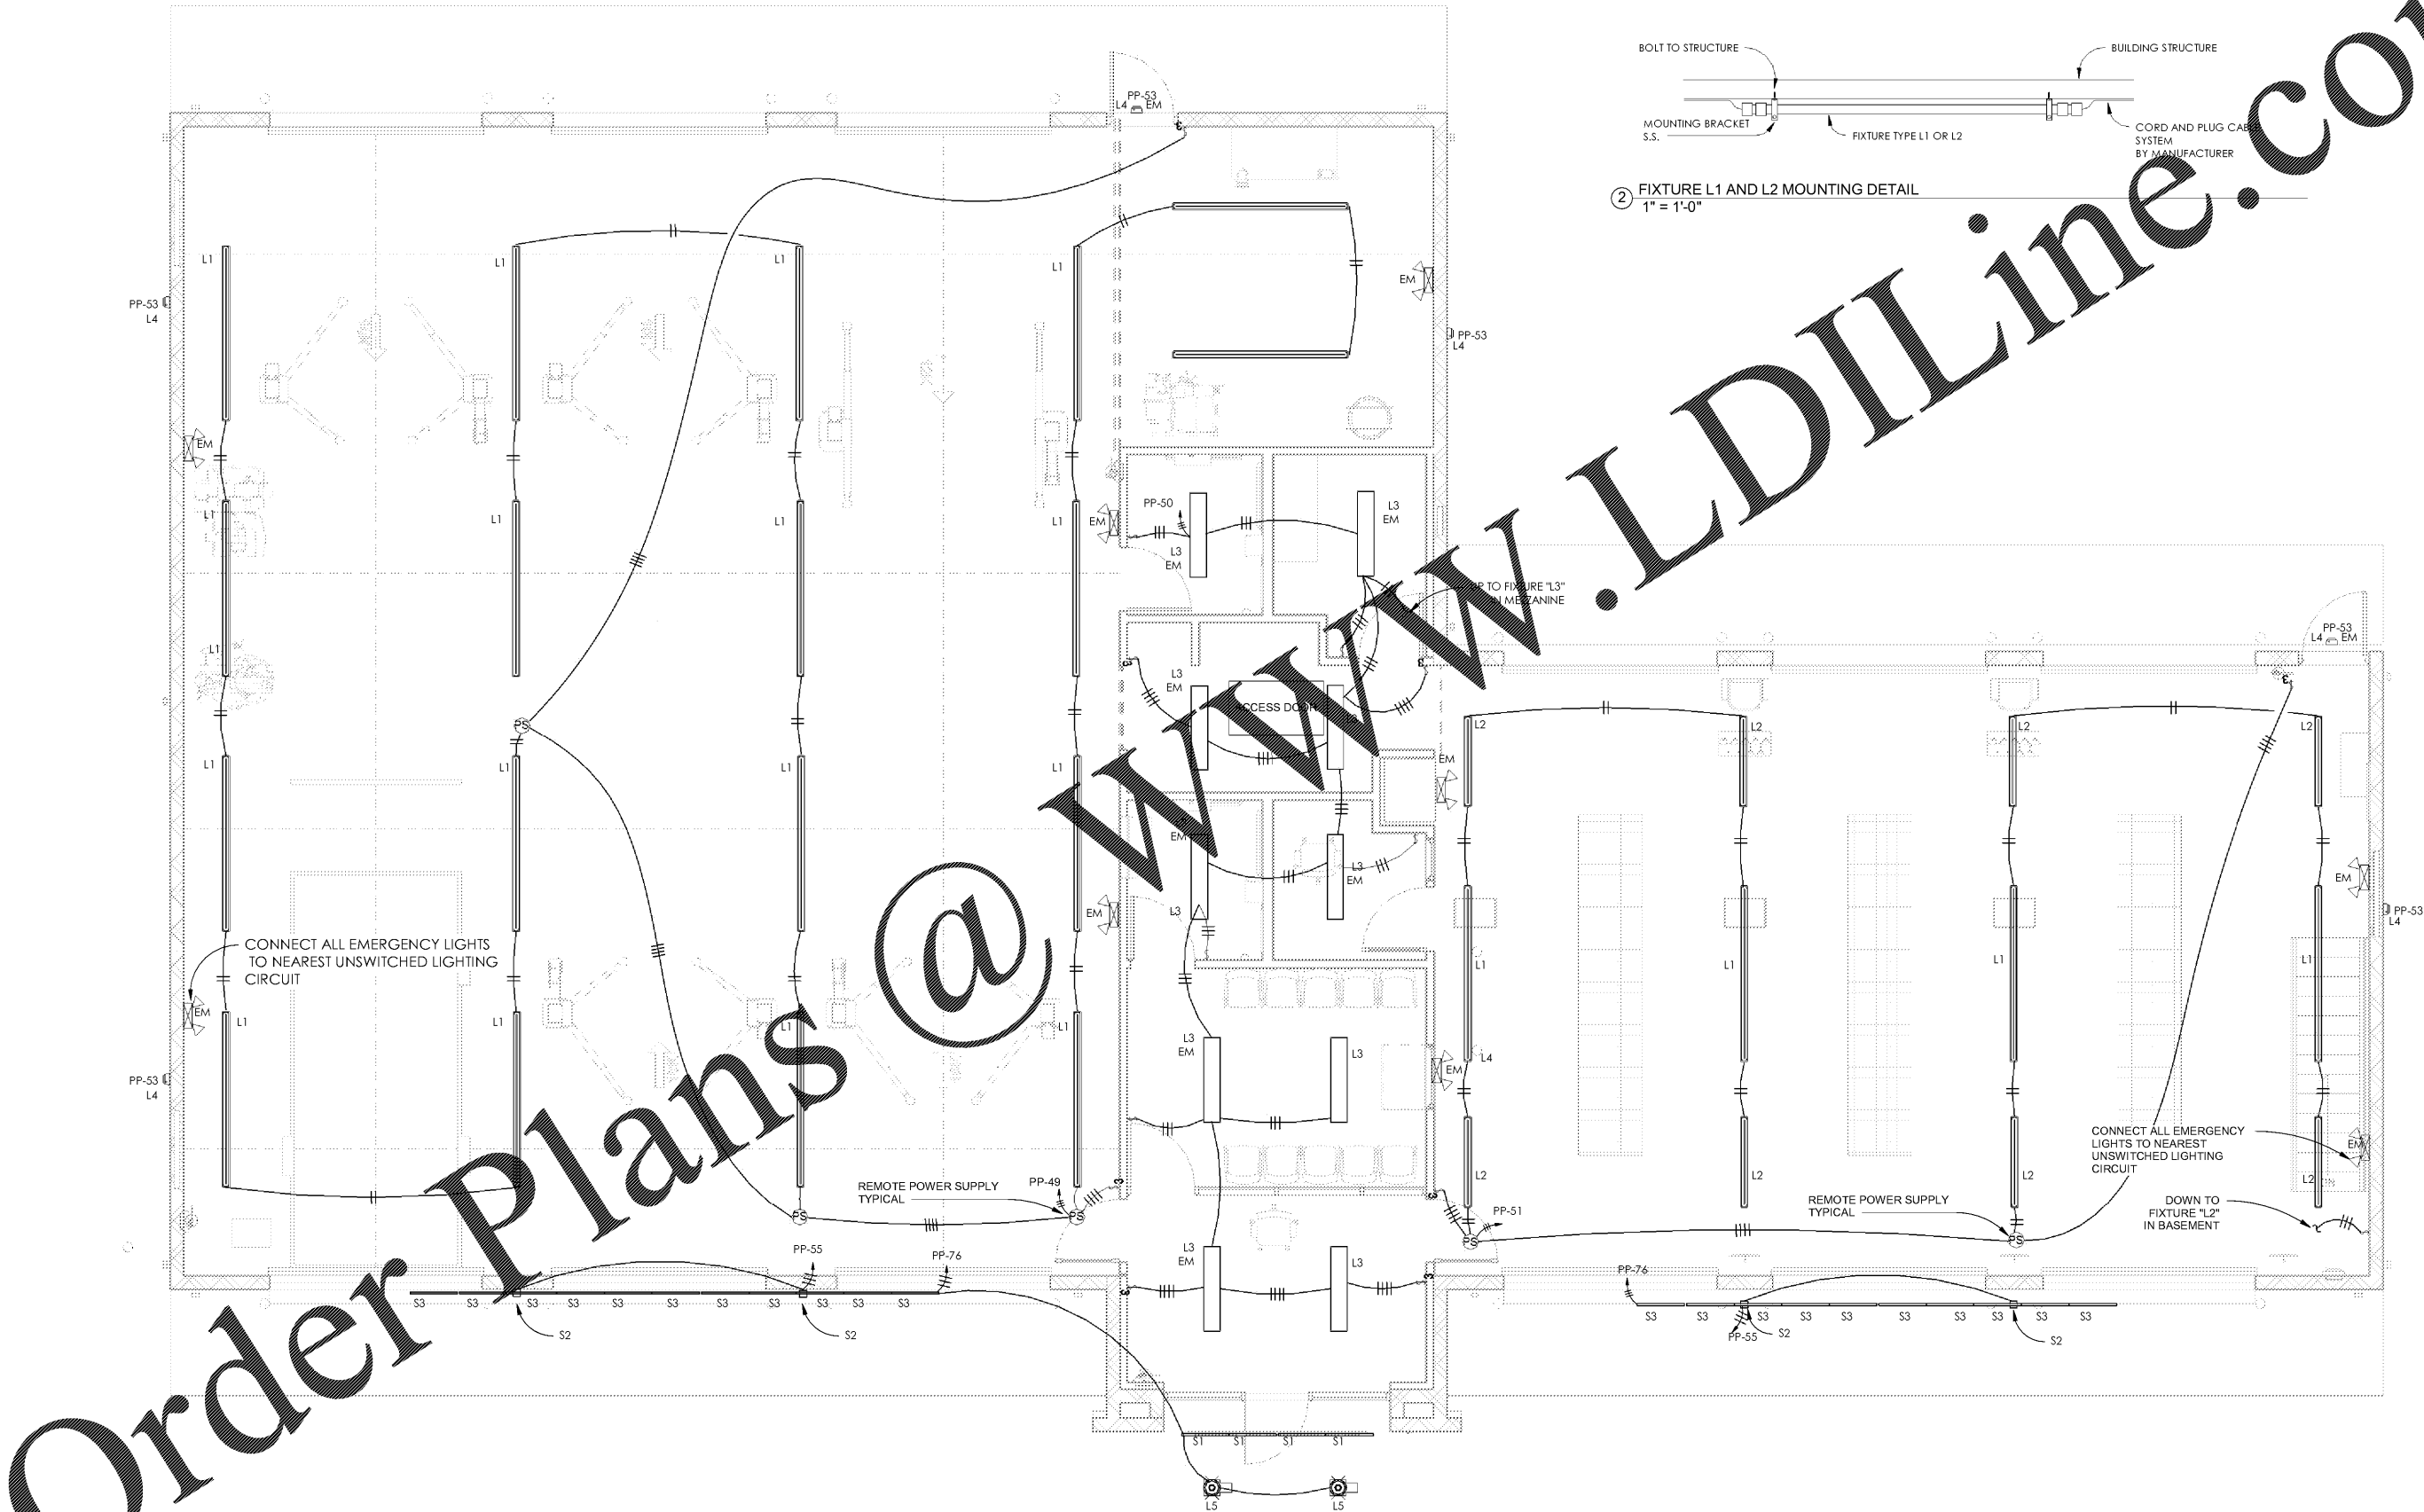

② FIXTURE L1 AND L2 MOUNTING DETAIL
1" = 1'-0"

① LIGHTING FLOOR PLAN
1/4" = 1'-0"



Order Plans @ www.LDILine.com