




④ LIGHTING MEZZ FLOOR PLAN  
1/4" = 1'-0"

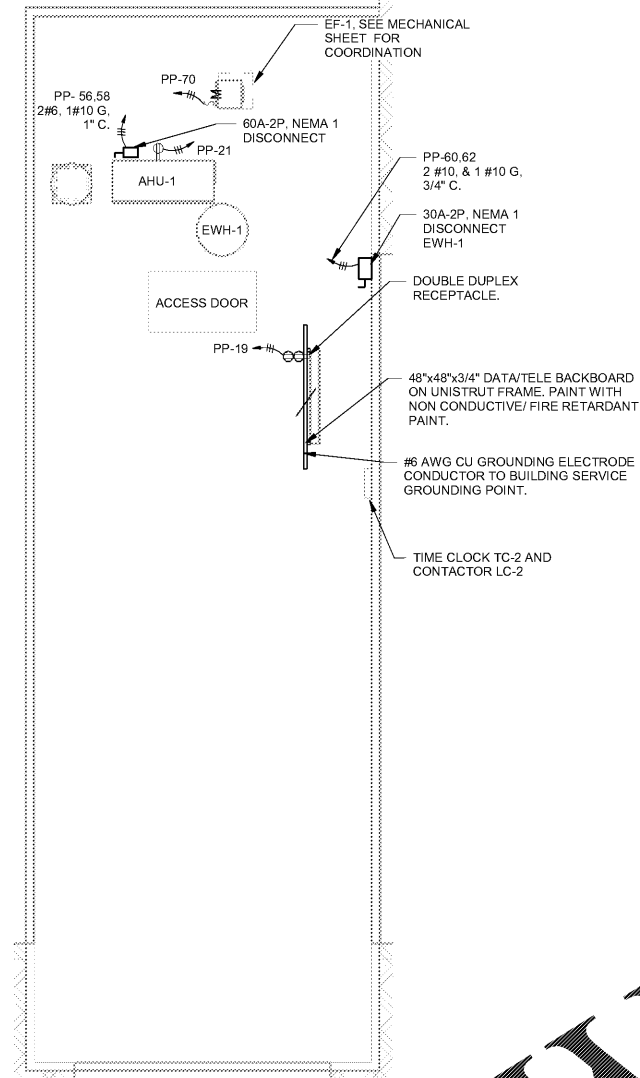


③ POWER & AUXILIARY MEZZ FLOOR PLAN  
1/4" = 1'-0"

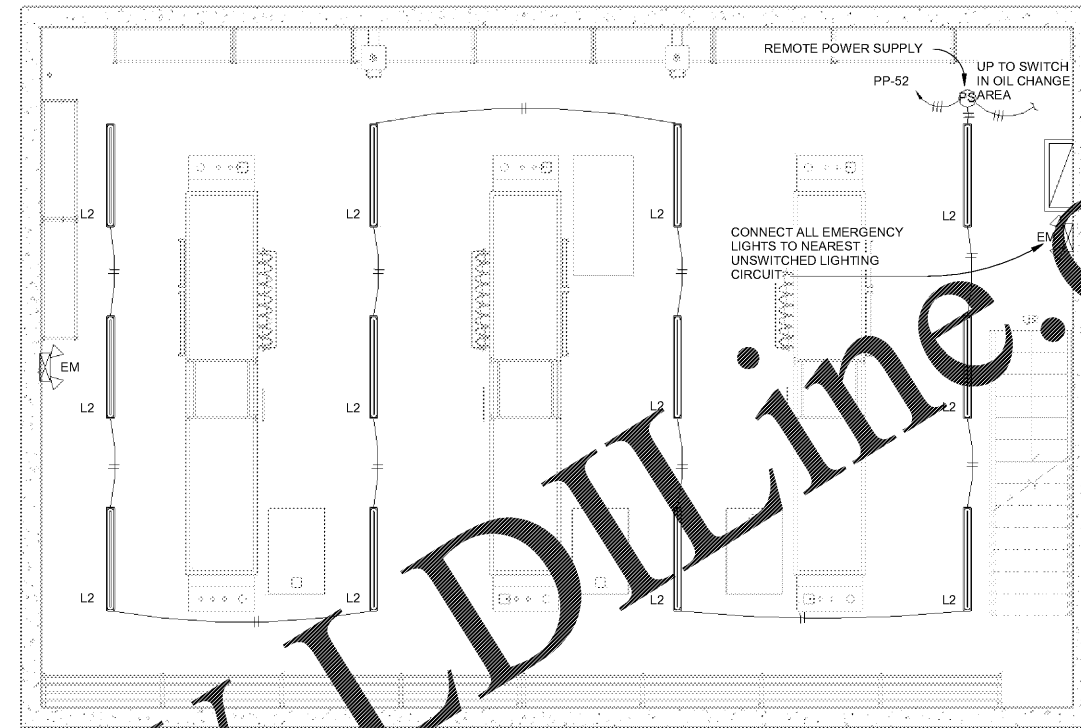

① LIGHTING PIT FLOOR PLAN  
1/4" = 1'-0"

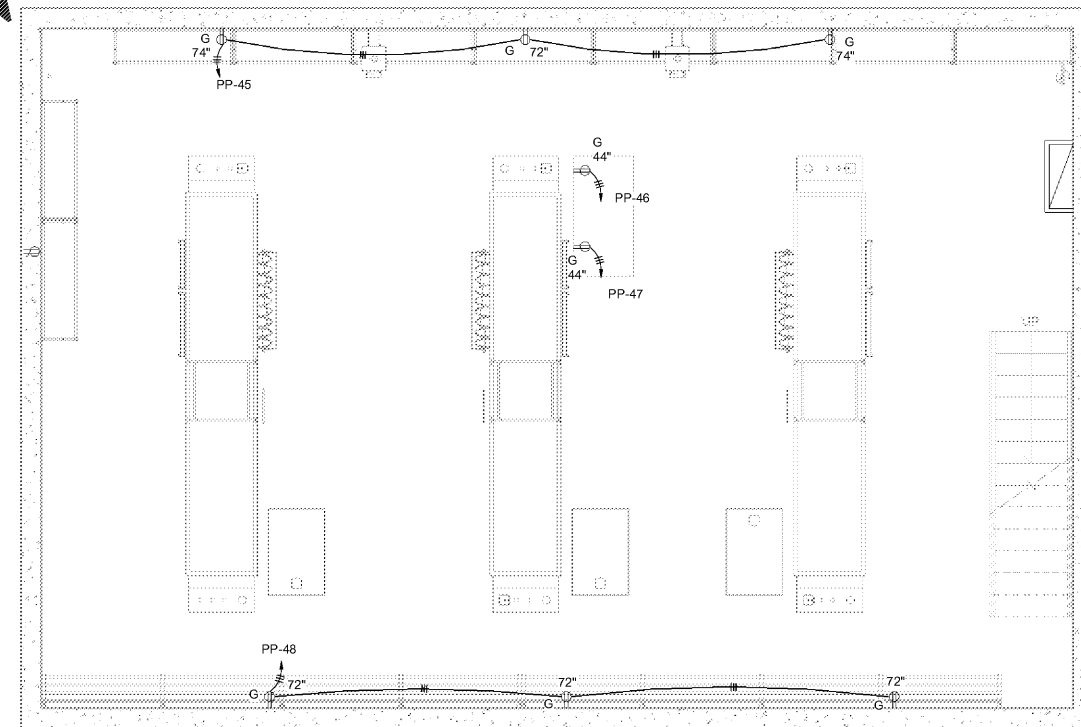

② POWER & AUXILIARY PIT FLOOR PLAN  
1/4" = 1'-0"

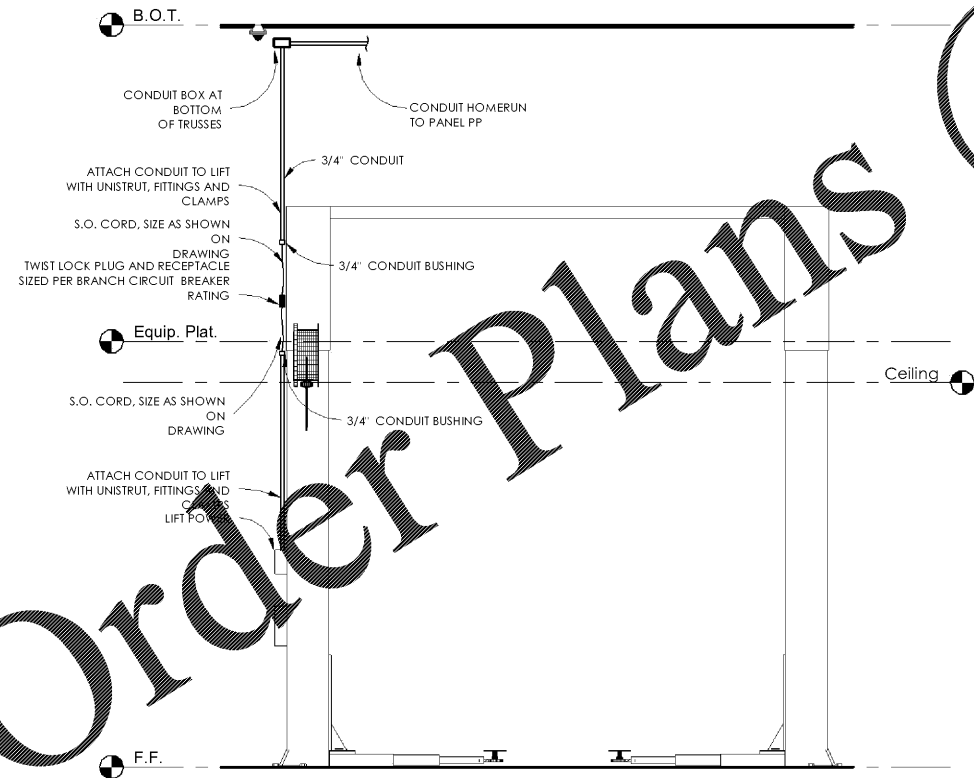

⑤ OC - LIFT POWER DETAIL  
1/2" = 1'-0"

Order Plans @

WWW.LDILine.com



Express Oil Change & Tire Engineers  
Single Building Right Hand Oil Change  
Augusta, GA

FINAL

No.	Description	Date

© 2017 Aho Architects, LLC. All Rights Reserved.

PIT/MEZZANINE FLOOR PLANS

Project number 16031  
Date 03/29/2017  
Drawn by MAH  
Checked by ATV

E203

Scale As indicated

