

ELECTRICAL NOTES:
 ALL WIRING BY LANDLORD UNLESS OTHERWISE NOTED.
 ALL OUTLET COVERS AND FACEPLATES SHOWN TO BE WHITE, EXCEPT TOE KICK AT LOZIER FIXTURES

EMS SYSTEM:
 BY POWERHOUSE. COORDINATE ALL REQUIREMENTS WITH FIVE BELOW CPM.

FIRE ALARM NOTE:
 L.L. SHALL INSTALL A FIRE ALARM SYSTEM IN ACCORDANCE W/ THE APPLICABLE CODE. IF A FIRE ALARM MONITOR IS REQUIRED, THE MONITORING SERVICES SHALL BE PROVIDED BY L.L. AND ALL WORK PERFORMED BY L.L.'S F.A. CONTRACTOR. IF IT IS AN INDEPENDENT FIRE ALARM PANEL, L.L. TO PROVIDE MONITORING FOR FIRST 30 DAYS, THEN TENANT TO TAKE OVER.


NOTES:
 A - SIGNAL BELL SHALL BE MOUNTED ABOVE CEILING NEAR STOREFRONT, EDWARDS - #EDW730
 B - SIGNAL BELL PUSH BUTTON TO SIGNAL BELL NEAR STOREFRONT TRANSFORMER & P.B. 48" A.F.F., CIRCUIT B:30 EDWARDS #EDW592.

1 ELECTRICAL POWER PLAN

SCALE: 3/16" = 1'-0"

- CONDUIT RUN CONCEALED IN CEILING OR WALLS OR RUN EXPOSED IN NON CEILING AREAS
- RIGID CONDUIT RUN UNDER OR IN FLOOR SLAB
- 12 VOLT DC EMERGENCY WIRING, 2 #10-3/4
- HOME RUN TO PANELBOARD, "A" INDICATES PANEL NO., "N" INDICATES CIR. NO. (2 #12 PLUS EQUIPMENT GROUNDING CONDUCTOR)
- SLASH MARKS INDICATE NO. OF CONDUCTOR IN RACEWAY IF MORE THAN TWO (DOES NOT INCLUDE EQUIPMENT GROUNDING CONDUCTOR)
- DUPLEX RECEPTACLE, 158-125, HUBBELL #5262, WHITE UNLESS NOTED
- DUPLEX OUTLET WITH GROUND FAULT INTERRUPTER, 36" AFF
- DOUBLE DUPLEX RECEPTACLE, NEMA 5-15R
- SINGLE POLE WALL SWITCH, 20A (OR 277) VOLT, HUBBELL #1221-L, 4" AFF
- TRIPLESS WALL SWITCH, 20A-125 (OR 277) VOLT, HUBBELL #1223-L, 4" AFF
- SHOW WINDOW RECEPTACLE- WALL MOUNTED AT 12'-6" A.F.F. TO BOTTOM OF RECEPTACLE
- JUNCTION BOX
- EMS (SITE SAGE)
- SCISSOR SWITCH, NON FUSED UNLESS OTHERWISE NOTED
- PHONE BACKBOARD (SIX AS REQ'D) PROVIDE ONE SEPARATE 3/4" CONDUIT FROM BACKBOARD TO CEILING CAVITY ABOVE.
- PUSHBUTTON & TRANSFORMER
- BUZZER & TRANSFORMER
- 7-DAT TIME CLOCK - TORK #W100L
- FIRE ALARM SYSTEM IONIZATION TYPE SMOKE DETECTOR AND DUCT DETECTOR HOUSING AND REMOTE INDICATING DEVICE. LOCATED REMOTE INDICATOR IN CEILING BELOW UNIT. PROVIDE AUXILIARY CONTACT AS REQUIRED TO SHUTDOWN AIR HANDLING EQUIPMENT ASSOCIATED WITH ABOVE 2000 CFM AND IN RETURN AIR DUCTS ABOVE 15,000 CFM.
- TELEPHONE OUTLET, PROVIDE CONDUIT AND PULL WIRE TO BACKBOARD
- DATA OUTLET
- TELEPHONE DATA OUTLET
- (E)(R) EXISTING / RELOCATED
- (E)(A) EXISTING / ABANDON
- SMOKE DETECTOR TEST
- SDT

A ELECTRICAL LEGEND

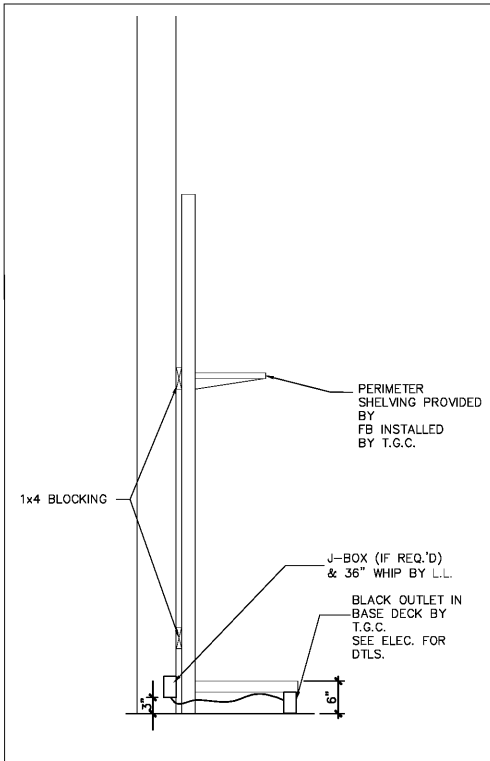

B SEC. @ PERIMETER SHELVING

CONSULTANTS

Professional Certification:
 I certify that these documents were prepared or approved by me, and that I am a duly licensed professional engineer under the laws of the State of Georgia, license number 30266, expiration date December 31, 2018.

ARCHITECTURAL SEAL

DATE ISSUE

NO.	DATE	REVISION	NAME

PROJECT NAME / LOCATION

five BELOW
 FAYETTEVILLE PAVILION
 110 PAVILION PARKWAY, SPACE 110A
 FAYETTEVILLE, GA 30214

PROJECT INFORMATION

DATE: APRIL 07, 2017
 PROJECT NO. 170238
 DELIVERY TYPE: V-BOX

DRAWN:
CHECKED:

SHEET TITLE / NUMBER
 POWER PLAN

E1.0