


CONSTRUCTION PLANS FOR:
MASJID AL-MOMINEEN
 837 NORTH INDIAN CREEK DRIVE, CLARKSTON,
 DEKALB COUNTY GEORGIA. 30021

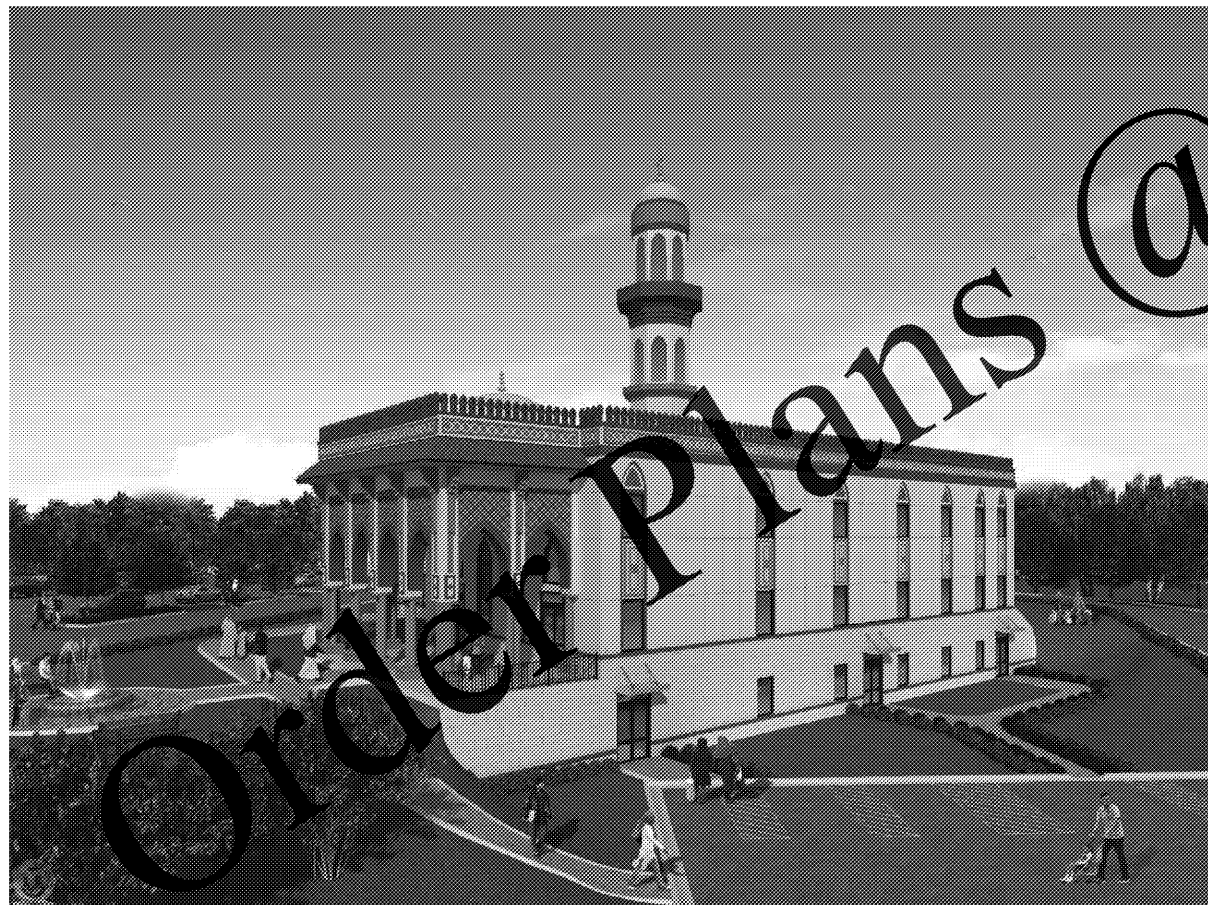

NORTH - WEST VIEW



SOUTH - WEST VIEW

PROJECT DIRECTORY:

SITE ADDRESS:
 837 NORTH INDIAN CREEK DRIVE
 CLARKSTON, DEKALB COUNTY
 GEORGIA. 30021

OWNER:
 MASJID AL-MOMINEEN
 837 NORTH INDIAN CREEK DRIVE
 CLARKSTON, DEKALB COUNTY
 GEORGIA. 30021

GENERAL CONTRACTORS & BUILDERS:
 BLACKWATER CONSTRUCTION GROUP, LLC
 2200 SATELLITE BLVD.
 DULUTH, GA

DESIGN TEAM:
 24 HOUR CONTACT:
 IMRAN NIAZI
 PHONE: 404-964-3569
 niaz@bellsouth.net

DESIGN CONSULTANTS:
 OM DESIGN SOLUTIONS LLC.
 PHONE: 404-740-7589
 info@omdesignsolutions.com

ARCHITECT OF RECORD:
 ROBERT J LARA, AIA
 8450 SW 201 ST.
 CUTLER BAY, FL 33189
 r_lara@bellsouth.net

STRUCTURAL:
 ENGQUEST INC.
 3580 ENGINEERING DRIVE, STE. 175
 PEACHTREE CORNERS, GA 30092
 PHONE: 404-797-1952
 david.t@engquest.com

ELECTRICAL, MECHANICAL & PLUMBING:
 ENGQUEST INC.
 3580 ENGINEERING DRIVE, STE. 175
 PEACHTREE CORNERS, GA 30092
 PHONE: 404-797-1952
 babujkazi@gmail.com

PROJECT INFORMATION AND SCOPE:

THE PROJECT SCOPE ENTAILS CONSTRUCTION OF A NEW RELIGIOUS WORSHIP BUILDING.

THE PROPOSED BUILDING WOULD BE TWO STORY HIGH BUILDING WITH A BASEMENT CONCRETE, CMU BLOCKS AND STEEL CONSTRUCTION. THE BUILDING WILL ACCOMMODATE MAIN PRAYER HALL, DINING HALL, KITCHEN LIBRARY, OFFICES AND ACCESSORY SPACES AS PER THE REQUIREMENTS OF THE MOSQUE.

THE SITE IS ALREADY DEVELOPED AND BUILDING PAD READY. THE PARKING, UTILITIES, STORM WATER SYSTEM ARE IN PLACE. THERE IS AN EXISTING TEMPORARY WORSHIP BUILDING IS LOCATED ON THE SITE. THE NEW BUILDING WOULD BE CONSTRUCTED IN PLACE OF THE EXISTING TEMPORARY BUILDING

INDEX OF DRAWINGS

ARCHITECTURAL

SHEET #	DESCRIPTION
CS	COVER SHEET
CD-01	LIFE SAFETY AND CODE DATA
CD-02	LIFE SAFETY AND CODE DATA
CD-08	LIFE SAFETY AND CODE DATA
A100	GENERAL NOTES
A101	ARCHITECTURAL SITE PLAN
A102	BASEMENT PLAN
A103	FIRST FLOOR PLAN
A104	SECOND FLOOR PLAN
A105	ROOF PLAN
A106	BASEMENT REFLECTED CEILING PLANS
A107	FIRST FLOOR REFLECTED CEILING PLANS
A108	SECOND FLOOR REFLECTED CEILING PLANS
A109	STAIRS - 1 DETAILS
A110	STAIRS - 2 DETAILS
A111	DOOR WINDOW SCHEDULE
A201	FRONT ELEVATION
A202	REAR ELEVATION
A203	LEFT ELEVATION
A204	RIGHT ELEVATION
A300	BUILDING SECTION
A301	BUILDING SECTION
A302	BUILDING SECTION
A303	WALL SECTIONS
A304	WALL SECTIONS
A305	UL DETAILS
A101	ADA DETAILS

STRUCTURAL

S001	STRUCTURAL NOTES
S002	STRUCTURAL NOTES
S003	STRUCTURAL NOTES
S004	GENERAL DESIGN DETAILS
S101	FOUNDATION PLAN
S111	SLAB PLAN
S121	FIRST FLOOR FOUNDATION PLAN
S122	FIRST FLOOR FRAMING PLAN
S131	SECOND FLOOR FRAMING PLAN
S141	ROOF FRAMING PLAN
S142	ROOF FRAMING PLAN - PORCH
S401	STAIR FRAMING
S402	CMU REINFORCING PLANS
S501	DETAILS AT CONCRETE WALL AND FOOTING

E502	MIRAB DETAIL
E503	NORTH CMU WALL SECTION
E504	STRUCTURAL DETAILS
E505	PORCH FRAMING DETAILS
E506	STRUCTURAL DETAILS
E601	ROOF UPLIFT DIAGRAM

ELECTRICAL

E100	LEGEND, SYMBOL AND SCHEDULE
E101	FIRE ALARM LEGEND & RISER DIAGRAMS
E200	ELECTRICAL SPECIFICATIONS
E201	FIRE ALARM SPECIFICATIONS
E301	BASEMENT LIGHTING PLAN
E302	FIRST FLOOR LIGHTING PLAN
E303	SECOND FLOOR LIGHTING PLAN
E401	BASEMENT POWER PLAN
E402	FIRST FLOOR POWER PLAN
E403	SECOND FLOOR POWER PLAN
E404	ROOF POWER PLAN
E501	BASEMENT FIRE ALARM PLAN
E502	FIRST FLOOR FIRE ALARM PLAN
E503	SECOND FLOOR FIRE ALARM PLAN
E600	ELECTRICAL DETAILS
E701	ELECTRICAL ONE LINE DIAGRAM
E702	ELECTRICAL PANEL SCHEDULE
E703	ELECTRICAL PANEL SCHEDULE
E704	ELECTRICAL PANEL SCHEDULE & CONCHECK

MECHANICAL


M00	MECHANICAL GENERAL NOTES
M100	BASEMENT MECHANICAL PLAN
M200	FIRST FLOOR MECHANICAL PLAN
M300	SECOND FLOOR MECHANICAL PLAN
M400	ROOF MECHANICAL PLAN
M500	MECHANICAL SCHEDULE
M600	MECHANICAL GAS RISER DIAGRAM
M700	MECHANICAL DETAILS

PLUMBING

P00	PLUMBING GENERAL NOTES
P100	DOMESTIC WATER PLAN - BASEMENT
P200	DOMESTIC WATER PLAN - FIRST FLOOR
P300	DOMESTIC WATER PLAN - SECOND FLOOR
P400	SANITARY SEWER PLAN - BASEMENT
P500	SANITARY SEWER PLAN - FIRST FLOOR
P600	SANITARY SEWER PLAN - SECOND FLOOR
P700	RISER DIAGRAM - DOMESTIC WATER
P800	RISER DIAGRAM - SANITARY SEWER
P900	PLUMBING DETAILS

ABBREVIATIONS:

A.A.	AMERICAN WITH DISABILITIES ACT
A.F.F.	ABOVE FINISHED FLOOR
ARCH.	ARCHITECTURAL
BO.	BOARD
BL.	BUILDING
CL.	CLEAR
CMU	CONCRETE MASONRY UNIT
COL.	COLUMN
CONC.	CONCRETE
CONST.	CONSTRUCTION
CONT.	CONTINUOUS
C.P.T.	CARPET
DIA.	DIAMETER
DIM.	DIMENSION
DN.	DOWN
DET.	DETAIL
ELEC.	ELECTRICAL
ELEV.	ELEVATION
EQ.	EQUAL
EXTS.	EXISTING
EXT.	EXTERIOR
F.E.	FIRE EXTINGUISHER
FIXT.	FIXTURE
FT.	FOOT/FEET
G.S.F.	GROSS SQUARE FOOT
G.M.B.	GYPSUM MALL BOARD
GYF.	GYPSUM
H.C.	HOLLOW CORE/HANDICAP
H.M.	HOLLOW METAL
HT.	HEIGHT
LF.	LINEAR FEET
MFR.	MANUFACTURER
MTL.	METAL
C.L.	CENTER LINE
N/A	NOT APPLICABLE
N.I.C.	NOT IN CONTRACT
O.C.	ON CENTER
O.D.	OUTSIDE DIAMETER
PLYWD.	PLYWOOD
PROJ.	PROJECT/PROJECTION
PT.	PAINT
P.T.	PRESSURE TREATED
QTY.	QUANTITY
R.C.P.	REFLECTED CEILING PLAN
R.O.	ROUGH OPENING
SCHED.	SCHEDULE
SECT.	SECTION
S.F.	SQUARE FOOTAGE
SIM.	SIMILAR
SPEC.	SPECIFICATION
SQ.	SQUARE
STD.	STANDARD
TEMP.	TEMPORARY
T.O.	TOP OF
T.O.S.	TOP OF STEEL
T.O.W.	TOP OF WALL
TYF.	TYPICAL
UNC.	UNLESS NOTED OTHERWISE
V.I.F.	VERIFY IN FIELD
V.C.T.	VYNNIL COMPOSITION TILE
V.O.J.	VERIFY ON JOB
W/TH	WITH
W/O	WITH OUT
W.C.	WATER CLOSET
W.D.	WOOD
W.H.	WATER HEATER
WT.	WEIGHT

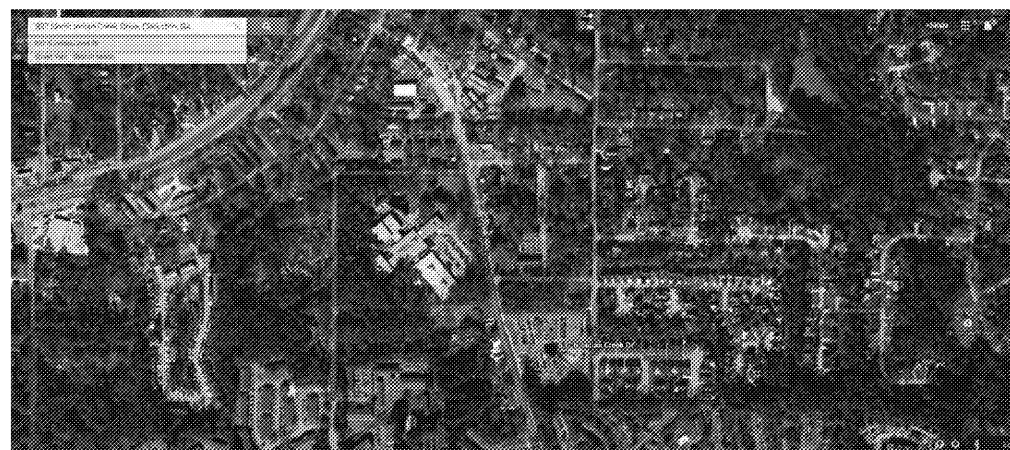

LOCATION MAP SITE

DESIGN BUILD
 BLACKWATER CONSTRUCTION GROUP, LLC
 2200 SATELLITE BLVD., DULUTH, GA 31609

DESIGN CONSULTANTS
 OM DESIGN SOLUTIONS LLC
 3580 ENGINEERING DRIVE, SUITE 175, PEACHTREE CORNERS, GA 30092
 Phone: 404-740-7589

ARCHITECT OF RECORD
 ROBERT J LARA, AIA
 8450 SW 201 ST.
 CUTLER BAY, FL 33189

Nov 9 2014

STRUCTURAL
ENGQUEST
 3580 ENGINEERING DRIVE, SUITE 175
 PEACHTREE CORNERS, GA 30092
 TEL: 404-797-1952
 www.engquest.com

MEP
ENGQUEST
 3580 ENGINEERING DRIVE, SUITE 175
 PEACHTREE CORNERS, GA 30092
 TEL: 404-797-1952
 www.engquest.com

NOTES:

REVISION #	DATE	REMARKS

ISSUE DATE	ISSUED TO	ISSUED FOR
10-02-2014	COUNTY	PERMITS

PROJECT ADDRESS:
MASJID AL-MOMINEEN
 837 NORTH INDIAN CREEK DRIVE
 CLARKSTON, DEKALB COUNTY
 GEORGIA. 30021

LAYOUT:
COVER SHEET

PAPER SIZE: 34X46 (ARCH D)
SCALE: AS NOTED

SHEET NUMBER:
CS