


Order Plans

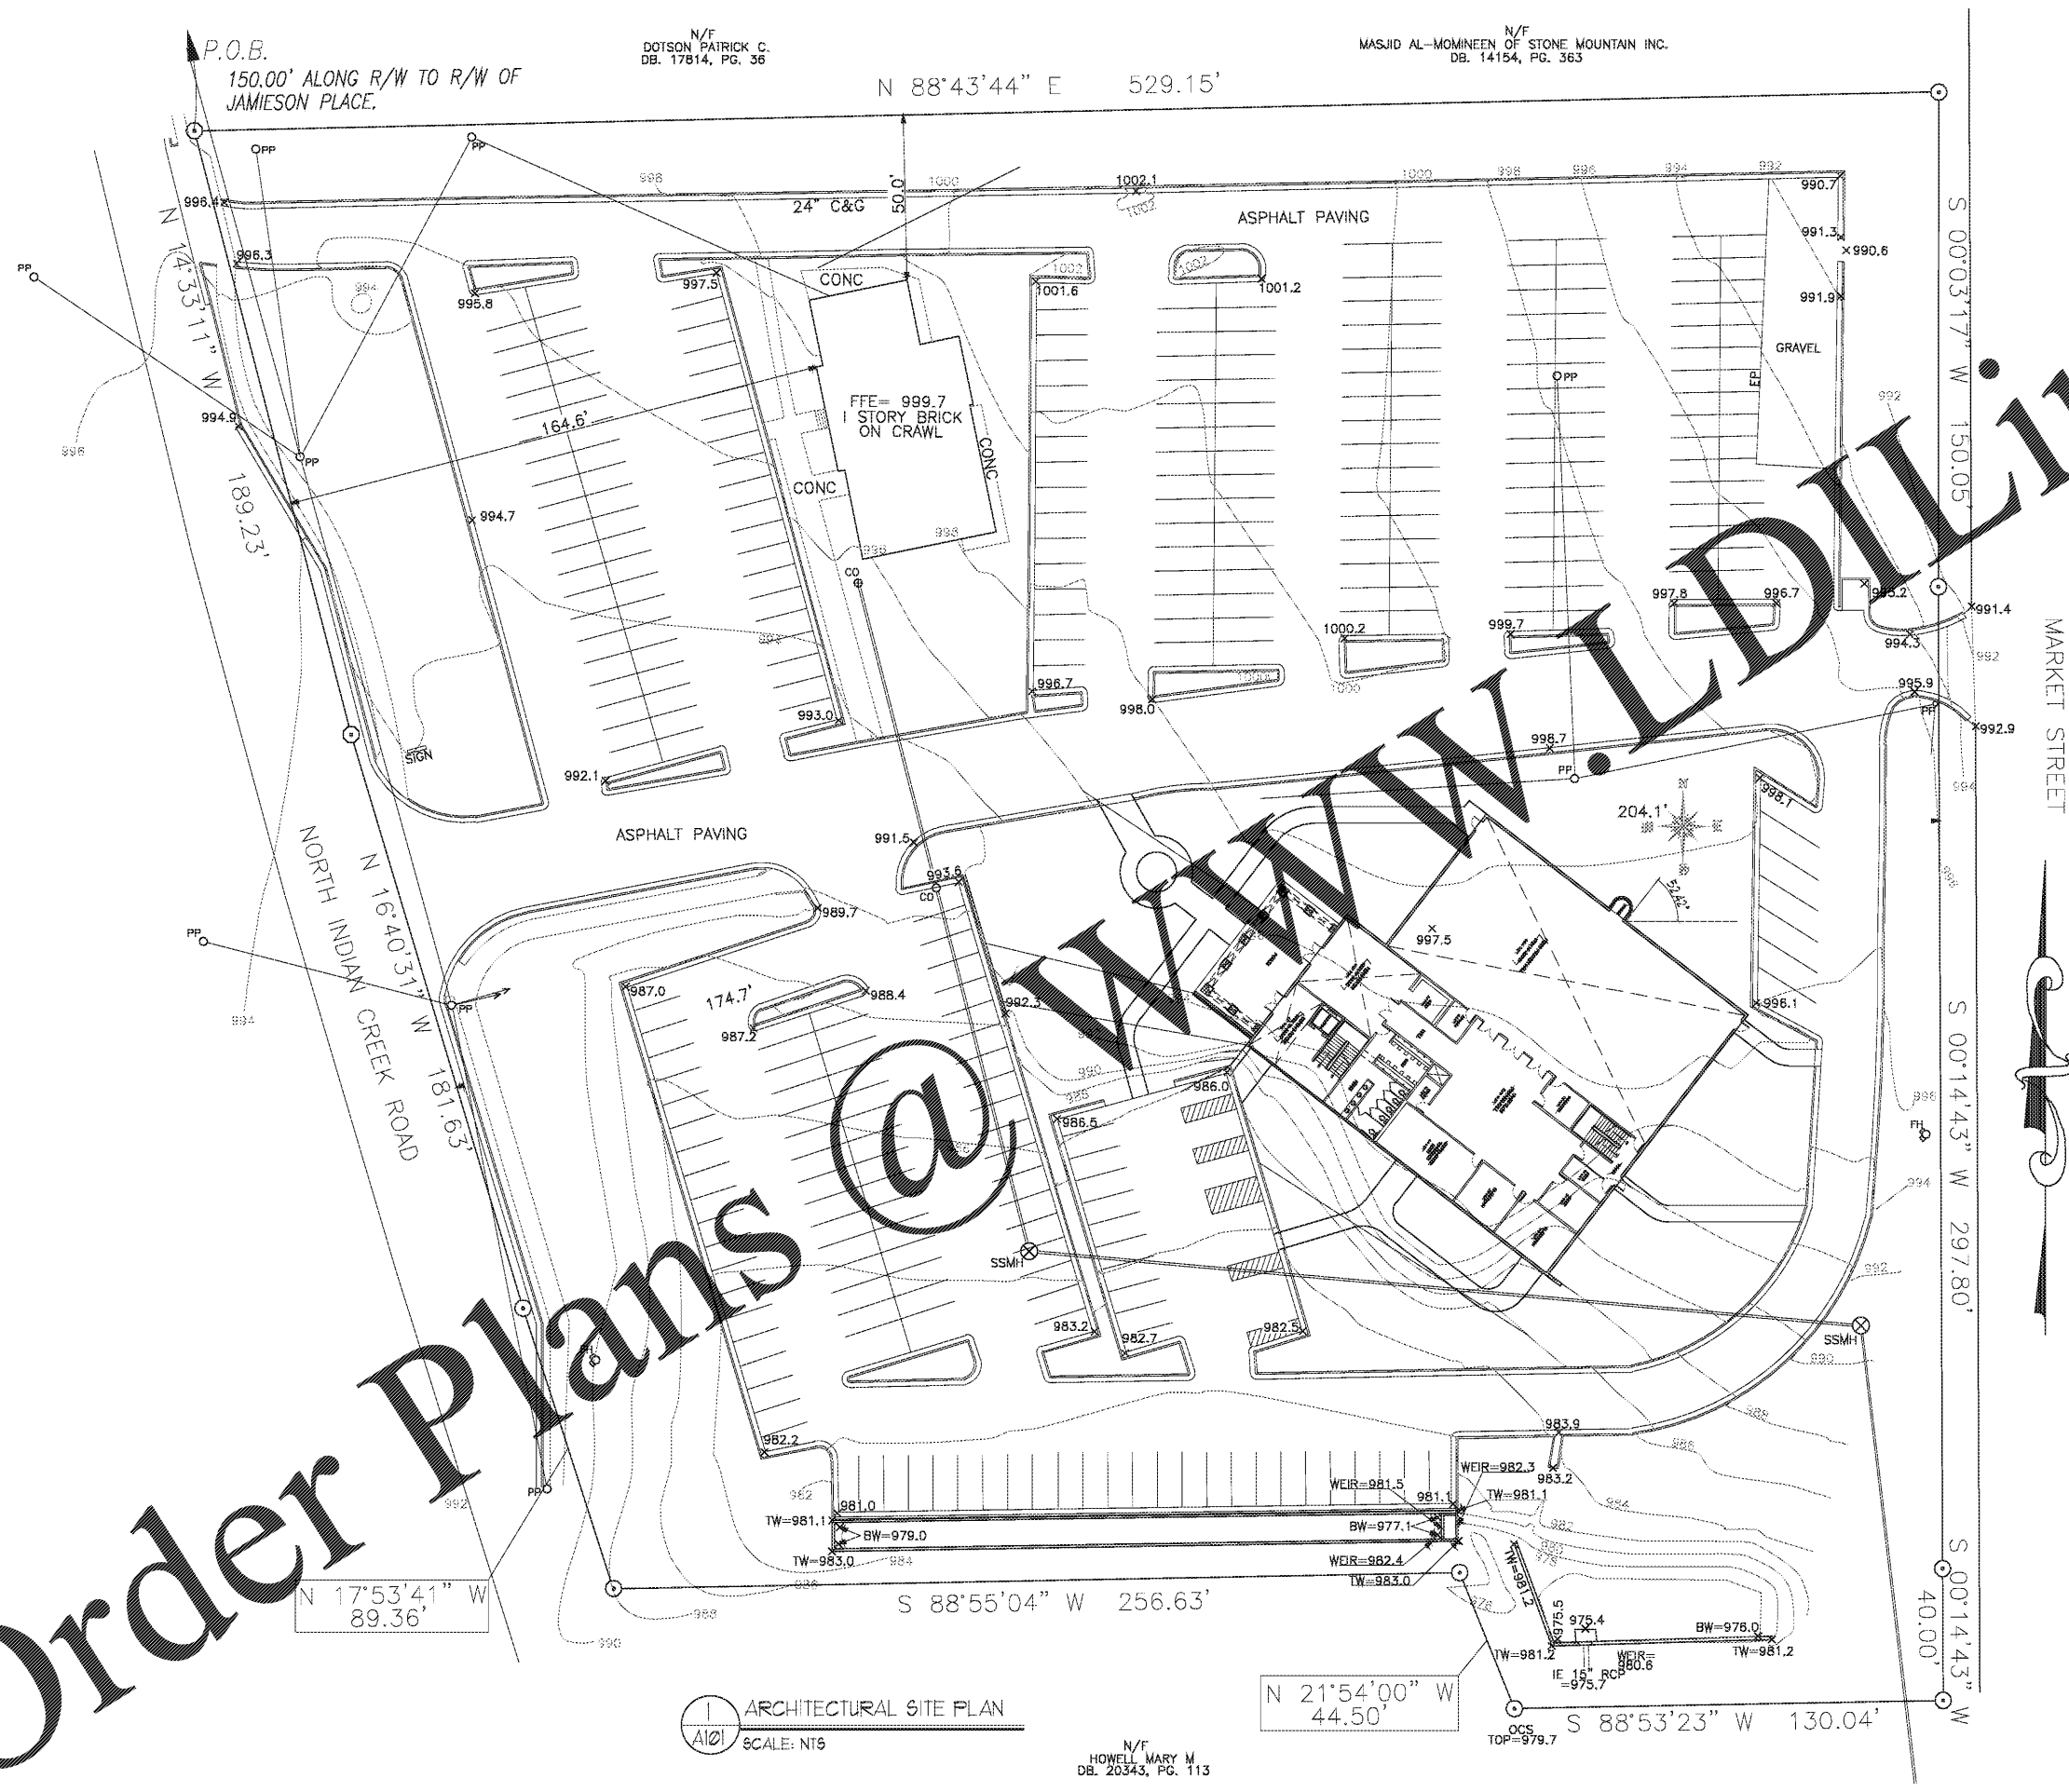

ARCHITECTURAL SITE PLAN
SCALE: NTS

N/F
HOWELL, MARY M
DB. 20343, PG. 113

DESIGN BUILD
BLACKWATER CONSTRUCTION GROUP, LLC
2200 SATELLITE BLVD., DULUTH GA 30099

DESIGN CONSULTANTS
DESIGN SOLUTIONS LLC
www.designsolutions.com
Phone: 404-740-7181

ARCHITECT OF RECORD
ROBERT J LARA, AIA
8450 SW 201 ST.
CUTLER BAY, FL 33189

STATE OF GEORGIA
ROBERT JERRY LARA
REGISTERED ARCHITECT
Nov 9 2014

STRUCTURAL
ENGQUEST
1358 ENGINEERING DRIVE, SUITE 175
PEACHTREE CORNERS, GA 30092
TEL: (478) 966-4678
www.engquest.com

MEP
ENGQUEST
1358 ENGINEERING DRIVE, SUITE 175
PEACHTREE CORNERS, GA 30092
TEL: (478) 966-4678
www.engquest.com

NOTES:

REVISION #	DATE	REMARKS

ISSUE DATE	ISSUED TO:	ISSUED FOR:
10-02-2014	COUNTY	PERMITS

PROJECT ADDRESS:
MASJID AL-MOMINEEN
837 NORTH INDIAN CREEK DRIVE
CLARKSTON, DEKALB COUNTY
GEORGIA, 30021

LAYOUT:
ARCHITECTURAL
SITE PLAN

PAPER SIZE: 24X36 (ARCH D)

SCALE: AS NOTED

SHEET NUMBER:
A101