


Order Plans

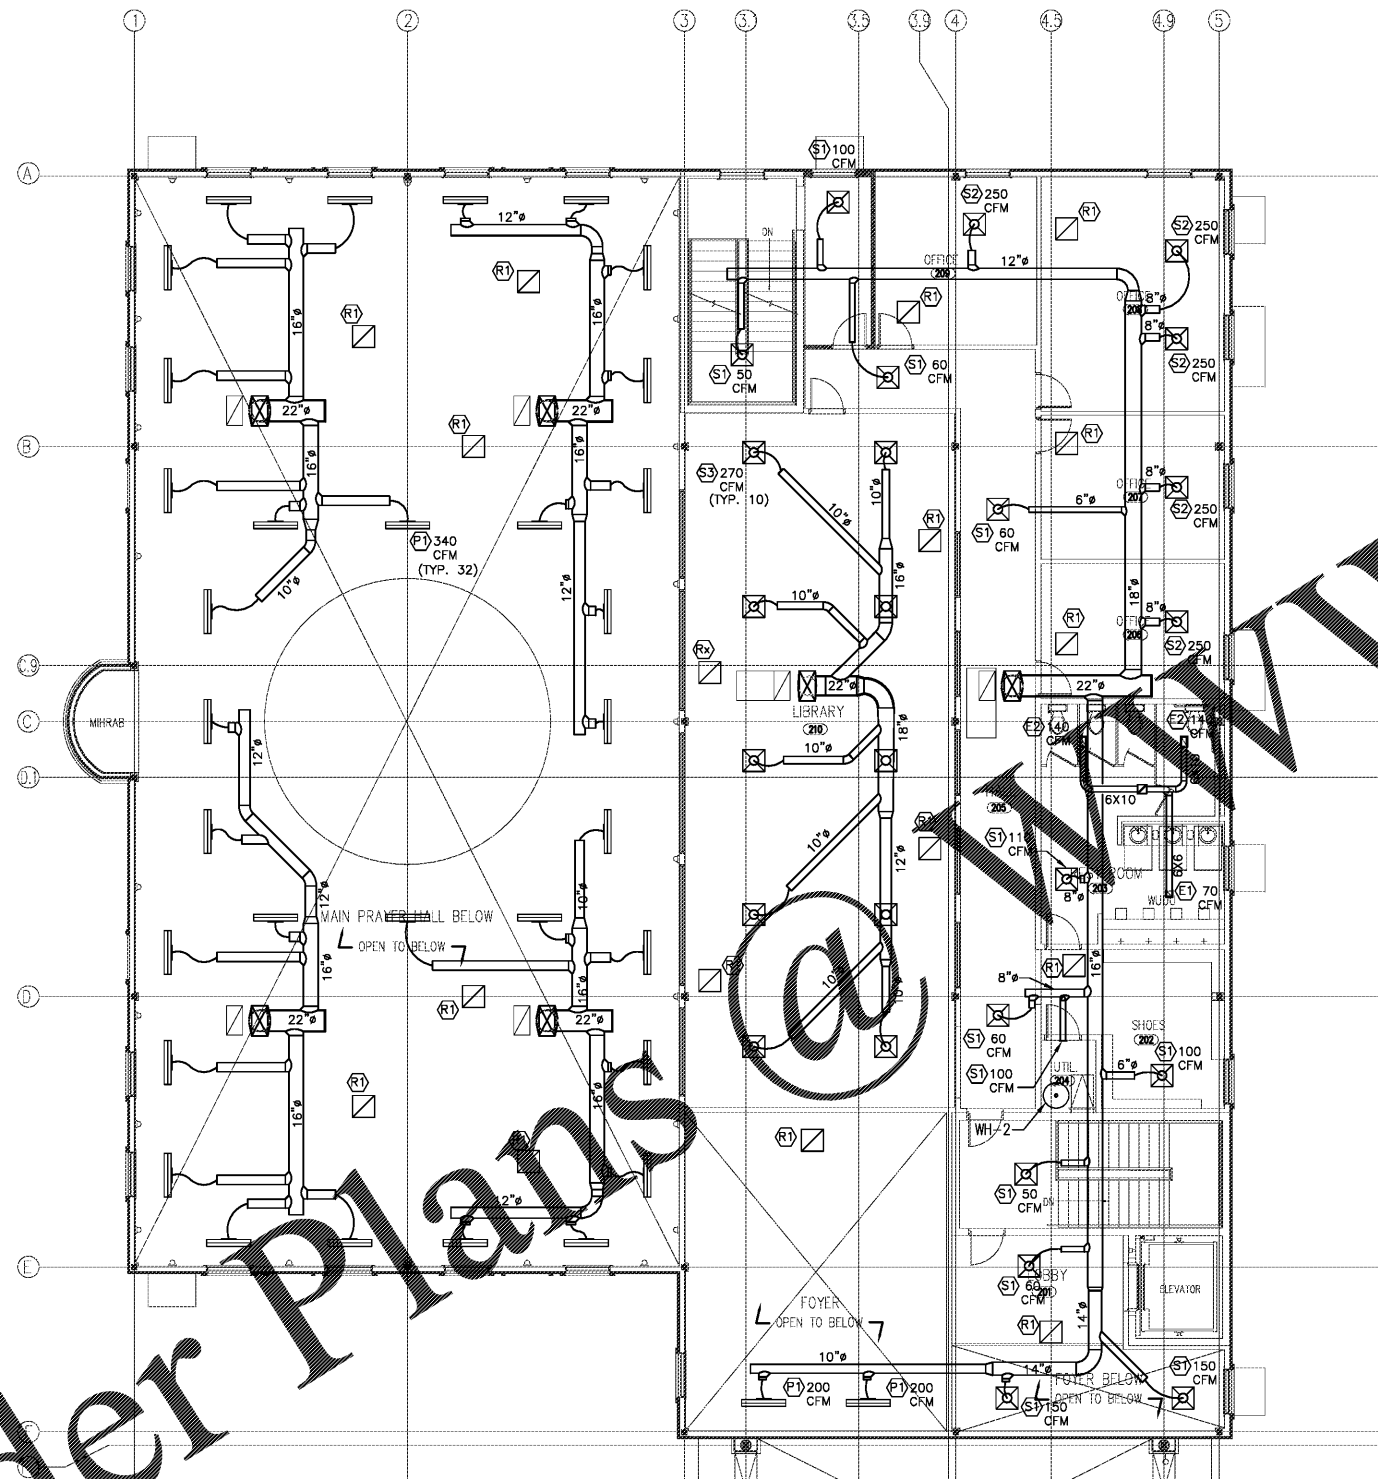

1 MECHANICAL SECOND FLOOR PLAN - HVAC
M102 SCALE: 1/8" = 1'-0"

DESIGN BUILD
BLACKWATER
CONSTRUCTION
GROUP, LLC
2200 SATELLITE BLVD, DULUTH GA
30092
TEL: (770) 455-3569

DESIGN CONSULTANTS
DESIGN
SOLUTIONS LLC
www.designsolutions.com
Phone: 404-740-7587

ARCHITECT OF RECORD
ROBERT J LARA, AIA
8450 SW 201 ST.
CUTLER BAY, FL 33189

STRUCTURAL
ENGQUEST
3550 ENGINEERING DRIVE, SUITE 175
PEACHTREE CORNERS, GA 30092
TEL: (678) 906-4670
www.engquest.com

MEP
ENGQUEST
3550 ENGINEERING DRIVE, SUITE 175
PEACHTREE CORNERS, GA 30092
TEL: (678) 906-4670
www.engquest.com

NOTES:

REVISION #	DATE	REMARKS

ISSUE DATE	ISSUED TO:	ISSUED FOR:
10-22-2014	COUNTY	PERMITS

PROJECT ADDRESS:
MASJID AL-MOMINEEN
837 NORTH INDIAN CREEK DRIVE
CLARKSTON, DEKALB COUNTY
GEORGIA, 30021

LAYOUT:
MECHANICAL HVAC -
SECOND FLOOR PLAN

PAPER SIZE: 24X36 (ARCH D)
SCALE: AS NOTED

SHEET NUMBER:
M102

