

**DESIGN BUILD**  
**BLACKWATER CONSTRUCTION GROUP, LLC**  
 2200 SATELLITE BLVD, DULUTH GA 30092  
 TEL: (770) 455-3569

**DESIGN CONSULTANTS**  
**DESIGN SOLUTIONS LLC**  
 1000 WOODBRIDGE DR, SUITE 100  
 ATLANTA, GA 30328  
 Phone: 404-740-7587

**ARCHITECT OF RECORD**  
**ROBERT J LARA, AIA**  
 8450 SW 201 ST.  
 CUTLER BAY, FL 33189

**STRUCTURAL**  
**ENGQUEST**  
 3550 ENGINEERING DRIVE, SUITE 175  
 PEACHTREE CORNERS, GA 30092  
 TEL: (678) 906-4670  
 www.engquest.com

**MEP**  
**ENGQUEST**  
 3550 ENGINEERING DRIVE, SUITE 175  
 PEACHTREE CORNERS, GA 30092  
 TEL: (678) 906-4670  
 www.engquest.com

**NOTES:**

REVISION #	DATE	REMARKS


ISSUE DATE	ISSUED TO:	ISSUED FOR:
10-02-2014	COUNTY	PERMITS

**PROJECT ADDRESS:**  
**MASJID AL-MOMINEEN**  
 837 NORTH INDIAN CREEK DRIVE  
 CLARKSTON, DEKALB COUNTY  
 GEORGIA, 30021

**LAYOUT:**  
**MECHANICAL GAS - ROOF PLAN**

**PAPER SIZE:** 24X36 (ARCH D)  
**SCALE:** AS NOTED

**SHEET NUMBER:**  
**M203**

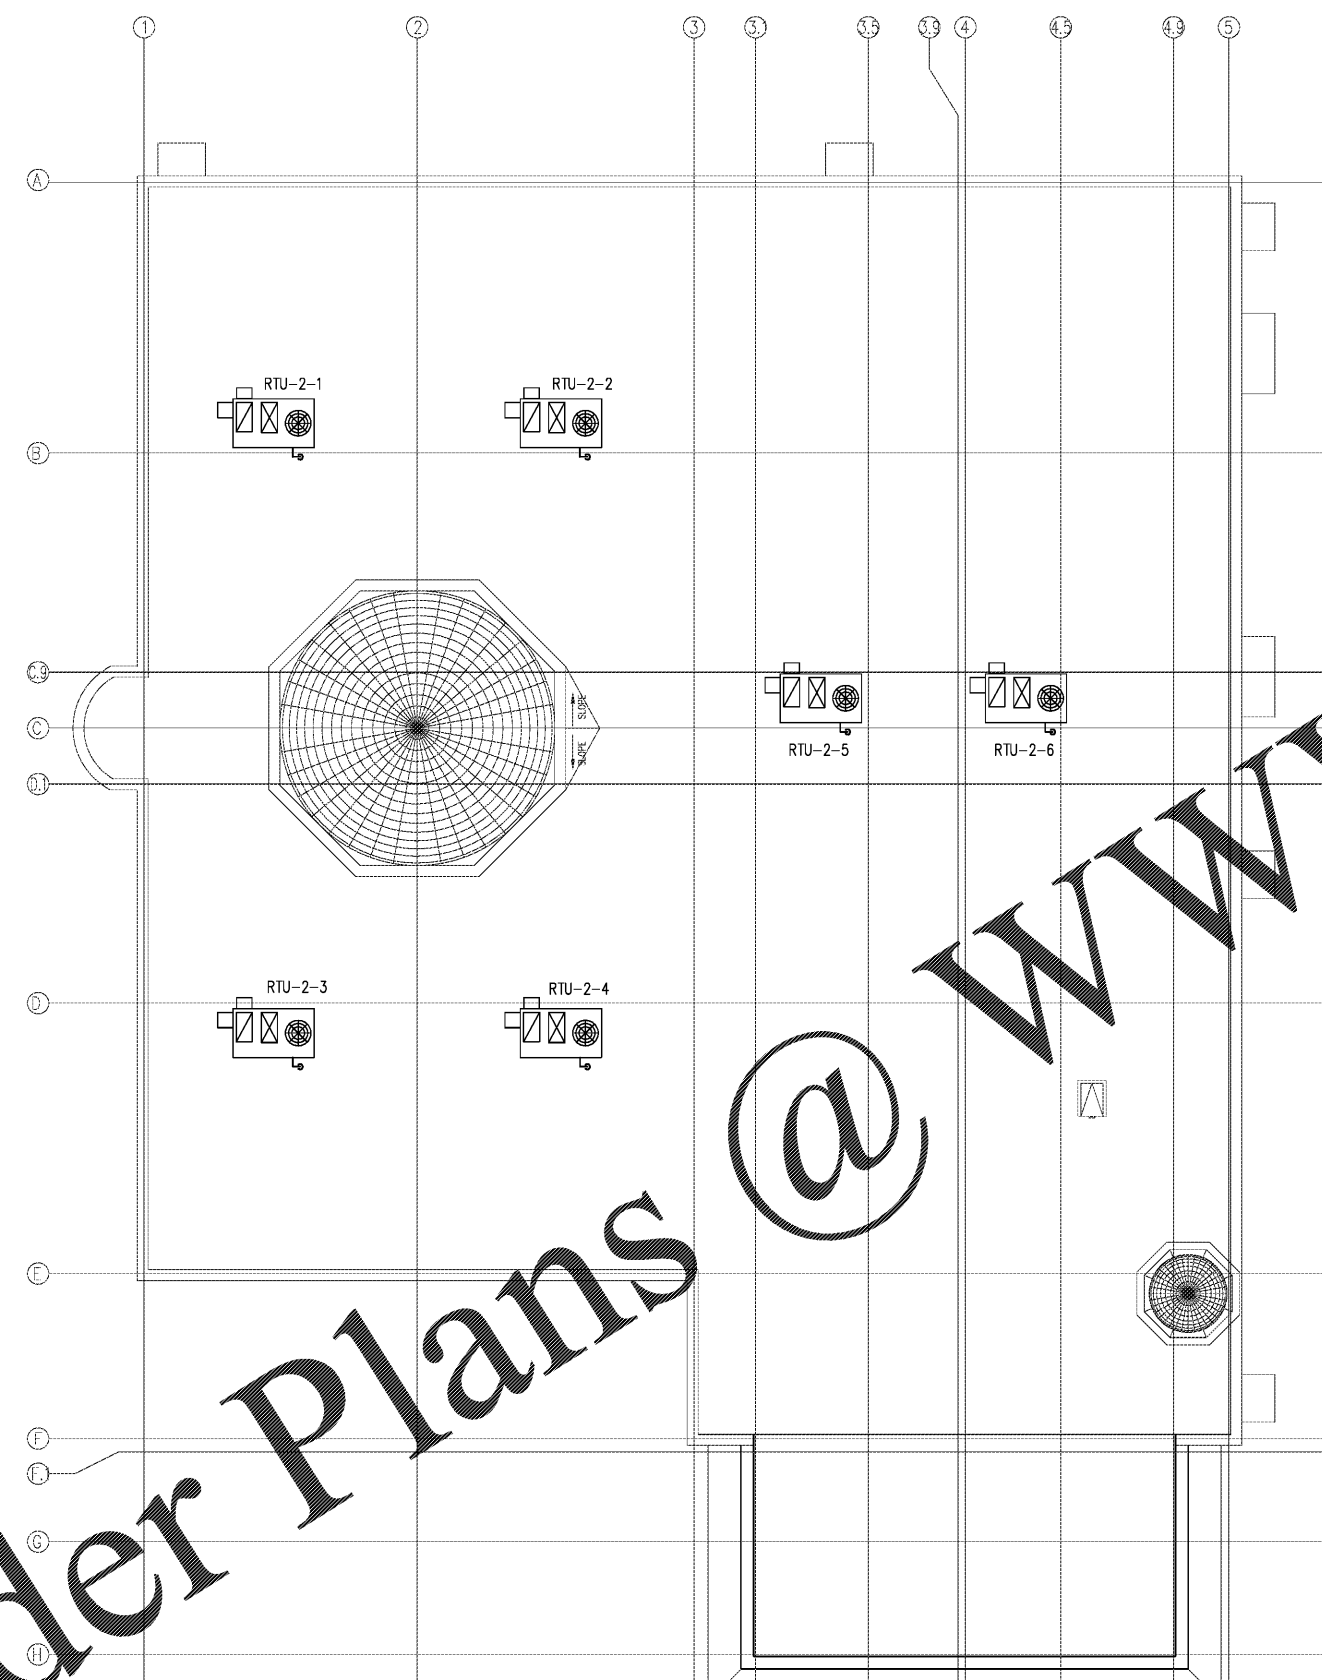

Order Plans @

**1** MECHANICAL ROOF PLAN - GAS PIPING  
 M203 SCALE: 1/8" = 1'-0"

