

DESIGN BUILD
BLACKWATER CONSTRUCTION GROUP, LLC
 2200 SATELLITE BLVD, DULUTH GA 30084
 TEL: (770) 412-3569

DESIGN CONSULTANTS
DESIGN SOLUTIONS LLC
 1000 SOUTHWEST CORNERS, SUITE 175
 PEACHTREE CORNERS, GA 30092
 TEL: (678) 906-4670
 www.designsolutions.com

ARCHITECT OF RECORD
ROBERT J LARA, AIA
 8450 SW 201 ST.
 CUTLER BAY, FL 33189

STRUCTURAL
ENGQUEST
 3550 ENGINEERING DRIVE, SUITE 175
 PEACHTREE CORNERS, GA 30092
 TEL: (678) 906-4670
 www.engquest.com

MEP
ENGQUEST
 3550 ENGINEERING DRIVE, SUITE 175
 PEACHTREE CORNERS, GA 30092
 TEL: (678) 906-4670
 www.engquest.com

NOTES:

REVISION #	DATE	REMARKS


ISSUE DATE	ISSUED TO:	ISSUED FOR:
10-22-2014	COUNTY	PERMITS

PROJECT ADDRESS:
MASJID AL-MOMINEEN
 837 NORTH INDIAN CREEK DRIVE
 CLARKSTON, DEKALB COUNTY
 GEORGIA, 30021

LAYOUT:
PLUMBING DOM. WATER - FIRST FLOOR PLAN

PAPER SIZE: 24X36 (ARCH D)
SCALE: AS NOTED

SHEET NUMBER:
P101

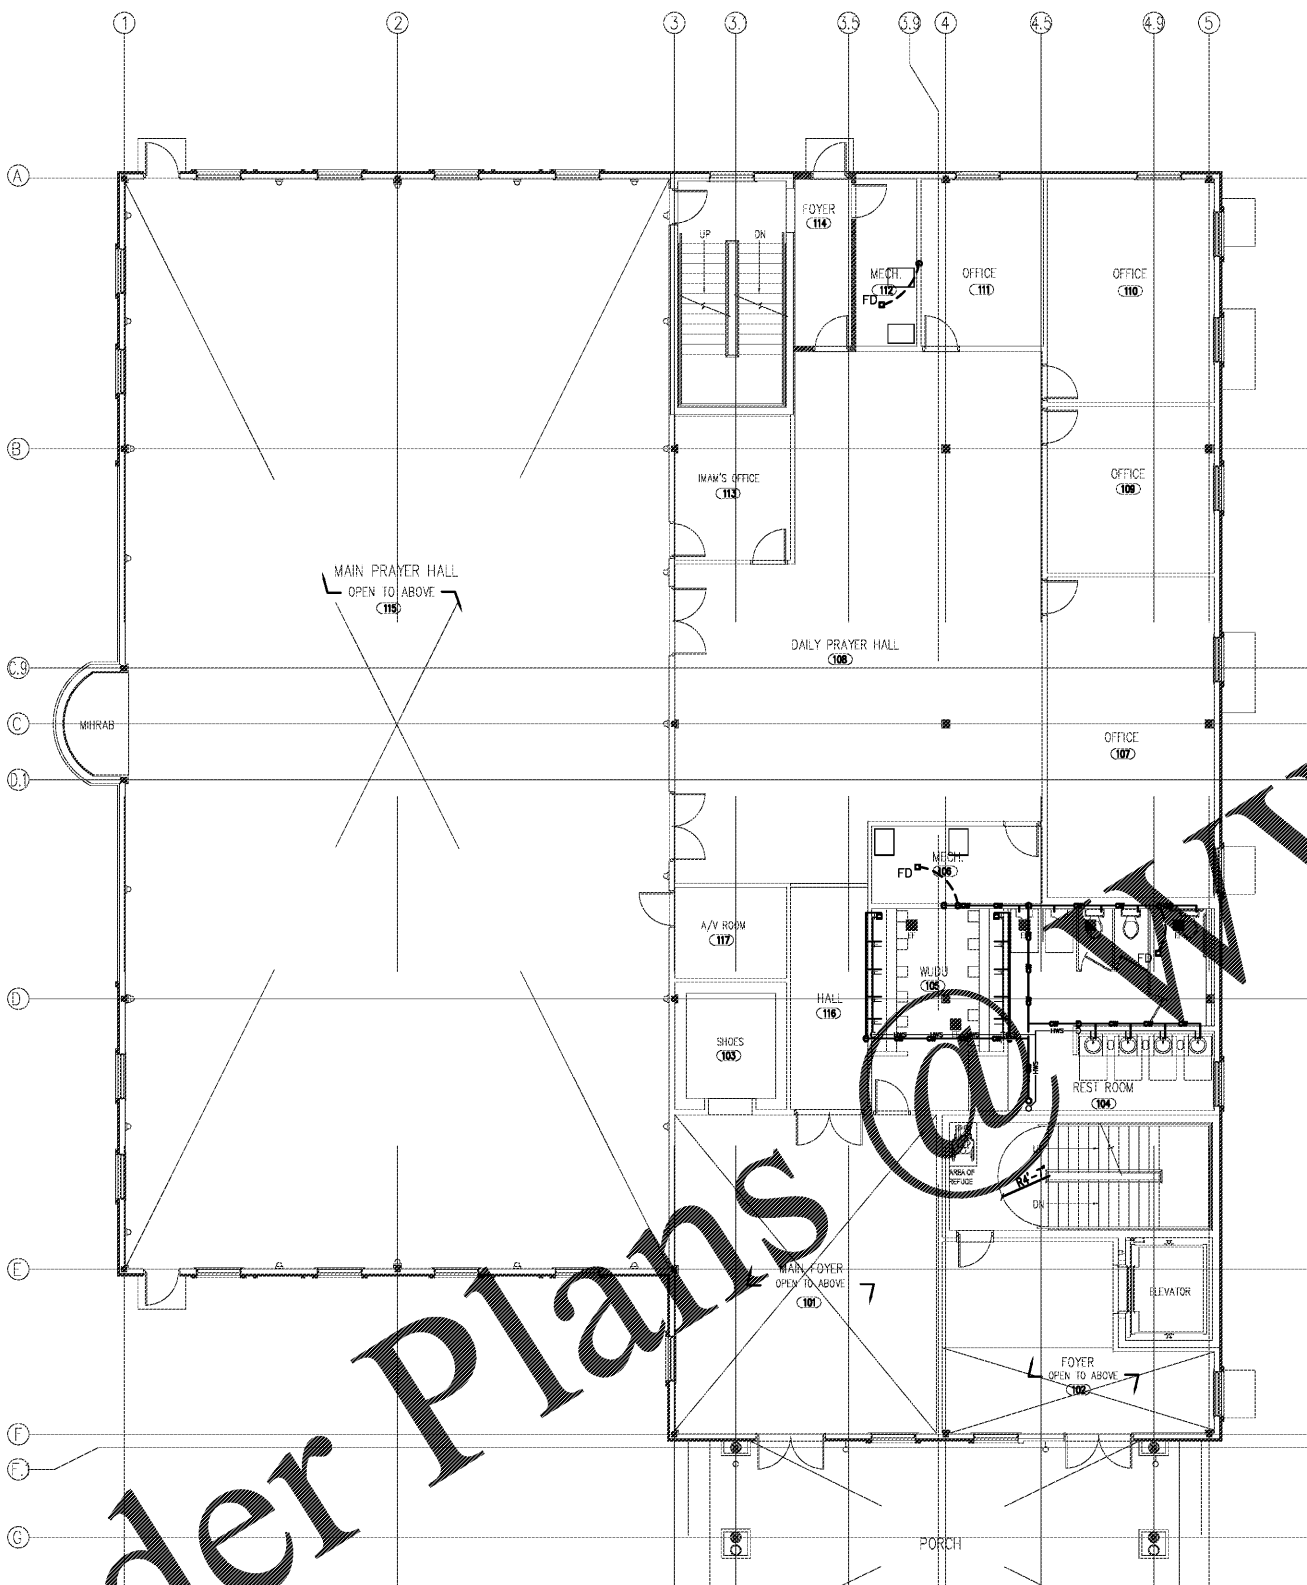

1 PLUMBING FIRST FLOOR PLAN - DOMESTIC WATER
 P101 SCALE: 1/8" = 1'-0"

