




CAPAC, INC.
CORPORATE ARCHITECTURE
HARRISON STREET
SAN FRANCISCO, CA 94105

REPS. ID.: 000054156

STORE NUMBER: 4458
STORE LOCATION:
VINELAND
8231 VINELAND AVENUE
SUITE 2151
ORLANDO, FLORIDA 32821

DESIGN TYPE: P3
GENERATION: 17Q12
PROTOTYPE DATE: 07/18/16
OPENING: 2017

CONSULTANT INFO:
EBA
EBA Consulting Engineers
6615 Vaught Ranch Road, Suite 100
Austin, Texas 78730-2314 USA
512.744.4400 main 512.744.4444 fax
www.eba.com
State of Registration: FLORIDA
Firm Registration No. 26645
EBA Project No. 20169549

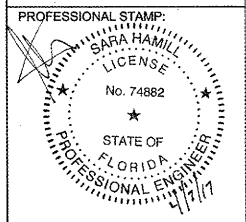

ARCHITECT INFO:
B|R|R
architecture
ARCHITECT OF RECORD: BRR ARCHITECTURE, INC.
6707 ANTIPOCH PLAZA, SUITE 200, NEARHAM, KANSAS 66204

ISSUE TYPE:
PERMIT/BID: 04/07/17


REVISIONS:

DRAWN BY: DPR
A/E JOB NUMBER: 65013011

TITLE SHEET:
LIGHTING PLAN

SHEET NUMBER:

E1-1

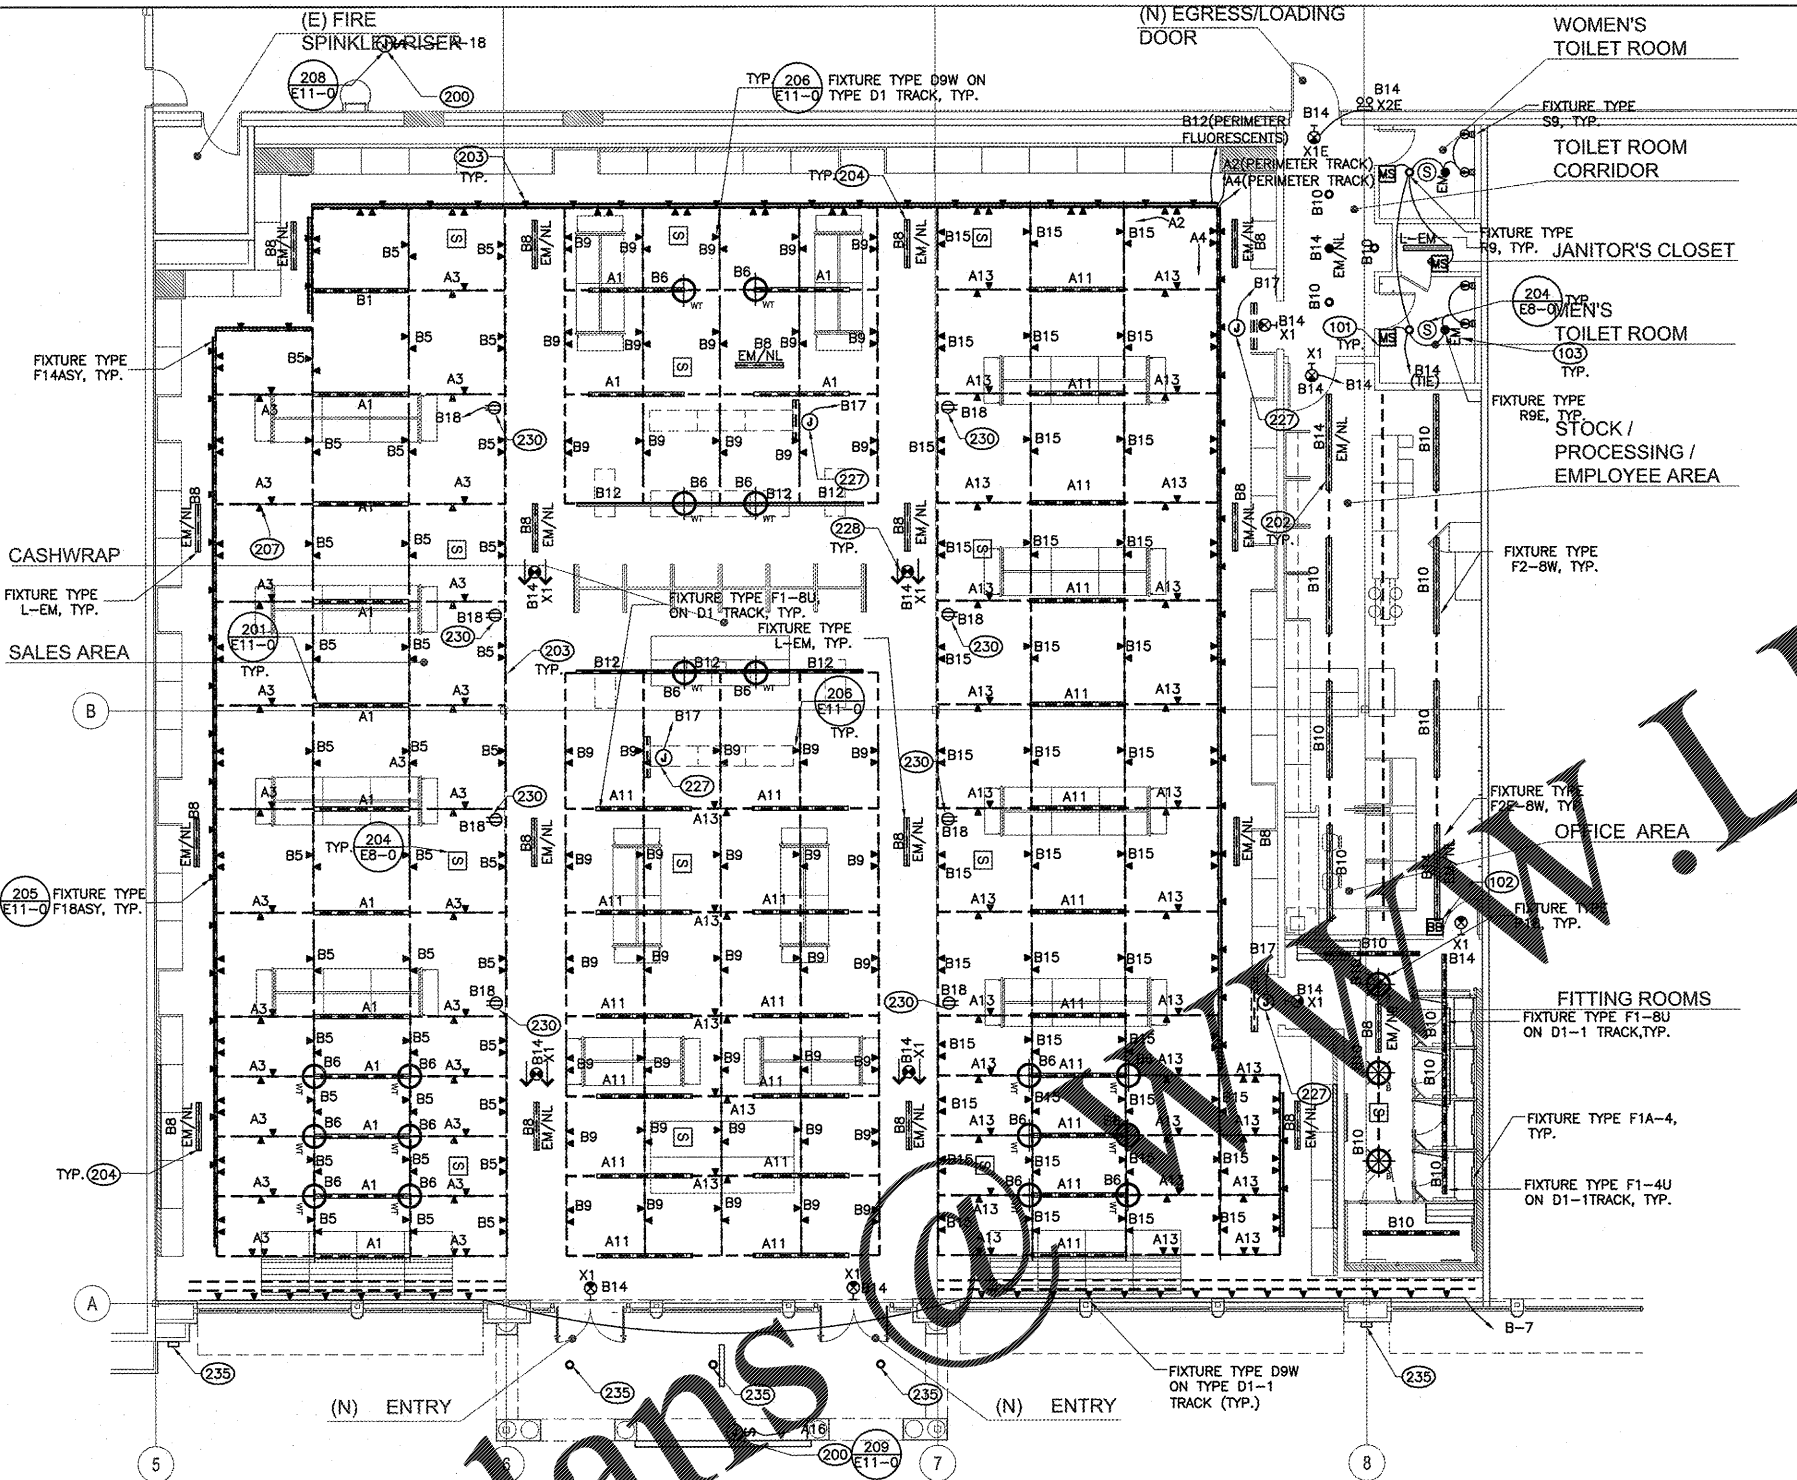

LIGHTING FIXTURE LEGEND

	NEW FLUORESCENT FIXTURE
	NEW EMERGENCY FLUORESCENT FIXTURE
(EM)	GC TO PROVIDE EXTRA HOT TO EMERGENCY FIXTURE HEAD CONTACTOR
(EM/NL)	NIGHT LIGHT

NOTE:
G.C. TO REFERENCE ARCHITECTURAL REFLECTED CEILING PLAN ON SHEET A1-1b FOR LOCATIONS OF ALL LIGHT FIXTURES, SIGNS AND A2-0 SERIES FOR EXTERIOR AND STOREFRONT ELEVATION.
G.C. TO REFER CONTACTOR SCHEDULE SHEET E9-1 FOR THE SCENE

LIGHTING CODED NOTES SCHEDULE

Coded	Mark	Type	Manufacturer/Model	Color	Mount Height	Use	Notes
101	MS		Watt Stopper PW100	White	44" A.F.F.	Auto Shut-off	Set for 15 minutes
102	BB		From TCS BAYSYS. See M8-0	White	44" A.F.F.	Shut-off override	Lighting override 2 hours
103		Designates emergency lighting. Provide separate unswitched hot circuit to emergency ballast in J-box.					
200		J-box, toggle switch and power for sign mounted on cavity side of horizontal tube steel member. Junction box by landlord. G.C. to make all final connections. Verify exact location with GC prior to rough-in. Refer to signage details for further requirements.					
202		Designates emergency/night lighting for back of house. To be circuited ahead of switching.					
203		New track lighting. Unistrut to run length of track. Drill through unistrut to power track. Field verify that the location and mounting heights do not conflict with existing field conditions prior to installation. Refer to light fixture schedule on sheet E4-0 for lighting information.					
204		Designates emergency/night lighting for sales floor. Lights to be off during business hours and come on when the scene 2 turns off and comes on in case of a power outage. Wire separate hot legs to battery and ballast. Hot leg for ballast to be run through normally open portion of the scene 2 contactor. Hot leg for battery is not switched.					
207		Track light to be mounted on unistrut. See architectural drawings. All unistrut to be hung with 3/8" threaded rod, typ.					
227		J-box at deck for power to signage. Coordinate location with GC prior to rough-in.					
228		Contractor shall provide J-box and supports as required for exit sign.					
230		Receptacle for mobile printer mounted on the side of unistrut that is suspending track.					
235		Relamp existing fixtures at exterior storefront.					

NOTE:
ALL TRACK HEADS THAT RUN FRONT-TO-BACK WITHIN THE STORE, WILL BE MOUNTED TO DUAL CIRCUIT TRACK WITH ONLY ONE LINE HOT. ALL TRACK HEADS THAT RUN SIDE-TO-SIDE WITHIN THE STORE, WILL BE MOUNTED TO DUAL CIRCUIT TRACK WITH TWO LINES HOT.