

**CASHWRAP GENERAL NOTES**


- COORDINATE AND CONFIRM LOCATIONS OF DEVICES AND CONDUIT STUB-UPS WITH G.C., ARCHITECTURAL DRAWINGS AND CASHWRAP SHOP DRAWINGS.
- REFER TO CONDUIT RISER DIAGRAM FOR EMPTY CONDUIT SIZES.
- FINAL CONNECTIONS, HUBS, AND WIRING FOR POS AND TELEPHONE SYSTEMS ARE PROVIDED AND INSTALLED BY SPENCER ENGINEERING AND LUCENT TECHNOLOGY RESPECTIVELY.
- FINAL CONNECTIONS AND WIRING FOR MUSIC SYSTEM ARE PROVIDED AND INSTALLED BY MUSIC VENDOR.
- CONDUIT ROUTING IS SHOWN FOR SCHEMATIC PURPOSES ONLY. CONTRACTOR TO FIELD VERIFY ALL CONDUIT ROUTING PRIOR TO INSTALLATION.

**CASHWRAP CODED NOTES**

- 213** CONDUIT FOR CASHWRAP POWER, CASHWRAP IG POWER, DATA, AND PHONE/VOLUME CONTROL/BUZZER REQUIREMENTS. SEE POWER PLAN SHEET E1-0 FOR CIRCUIT NUMBERS.
- 400** FLOOR BOX FOR POWER & DATA. HUBBELL CFB2G30 OR EQUAL FLUSH ALUMINUM COVER

**CASHWRAP WIRING LEGEND**

- TRENCHED CONDUIT AND WIRES BY G.C.
- POWER CIRCUITS TO CASHWRAP BY G.C.
- LOW VOLTAGE WIRES AND CONDUIT BY G.C.
- CIRCUITS IN CASHWRAP BY G.C.

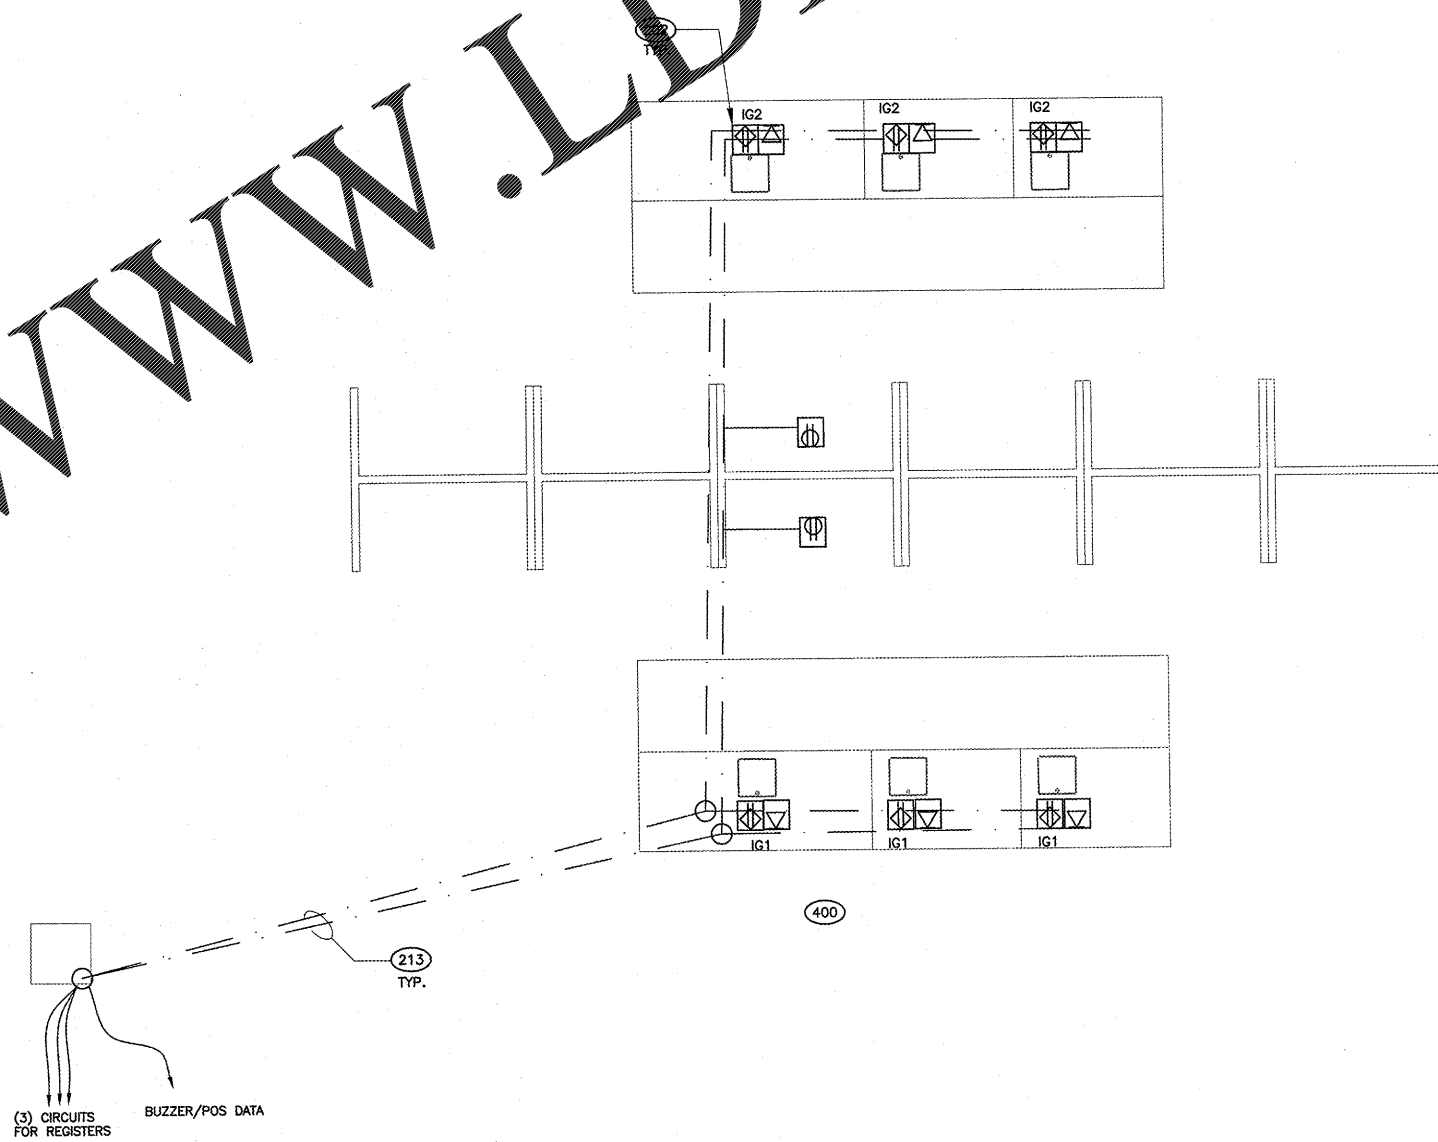

6-TERMINAL INLINE CASHWRAP PLAN LAYOUT

NOT TO SCALE  
202

NEW STORE

**OLD NAVY**

CAF, INC.  
CORPORATE ARCHITECTURE  
HARRIS STREET  
SAN FRANCISCO, CA 94105

REPS. ID: 0000054156

STORE NUMBER: 4458  
STORE LOCATION: VINELAND  
8231 VINELAND AVENUE  
SUITE 2151  
ORLANDO, FLORIDA 32821

DESIGN TYPE: P3  
GENERATION: 17Q12  
PROTOTYPE DATE: 07/18/16  
OPENING: 2017


CONSULTANT INFO:



EEA Consulting Engineers  
6615 Vaught Ranch Road, Suite 100  
Austin, Texas 78730-2316 USA  
512.744.4400 main 512.744.4444 fax  
www.eeace.com

State of Registration: FLORIDA  
Firm Registration No. 26645  
EEA Project No. 20169549

PROFESSIONAL STAMP:

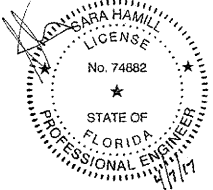

ARCHITECT INFO:

**B | R | R**  
architecture

ARCHITECT OF RECORD: BRR ARCHITECTURE, INC.  
6700 ANTOCH PLAZA, SUITE 300, MERRILL, KANSAS 66504

ISSUE TYPE:

PERMIT/BID: 04/07/17

REVISIONS:

DRAWN BY: DPR

A/E JOB NUMBER: 65013011

TITLE SHEET:  
CASHWRAP DETAILS

SHEET NUMBER:

**E6-0**