


**NOTES:**  
 1. SEE SHEET M-0.01 FOR MECHANICAL PLUMBING NOTES, LEGEND AND ABBREVIATIONS.

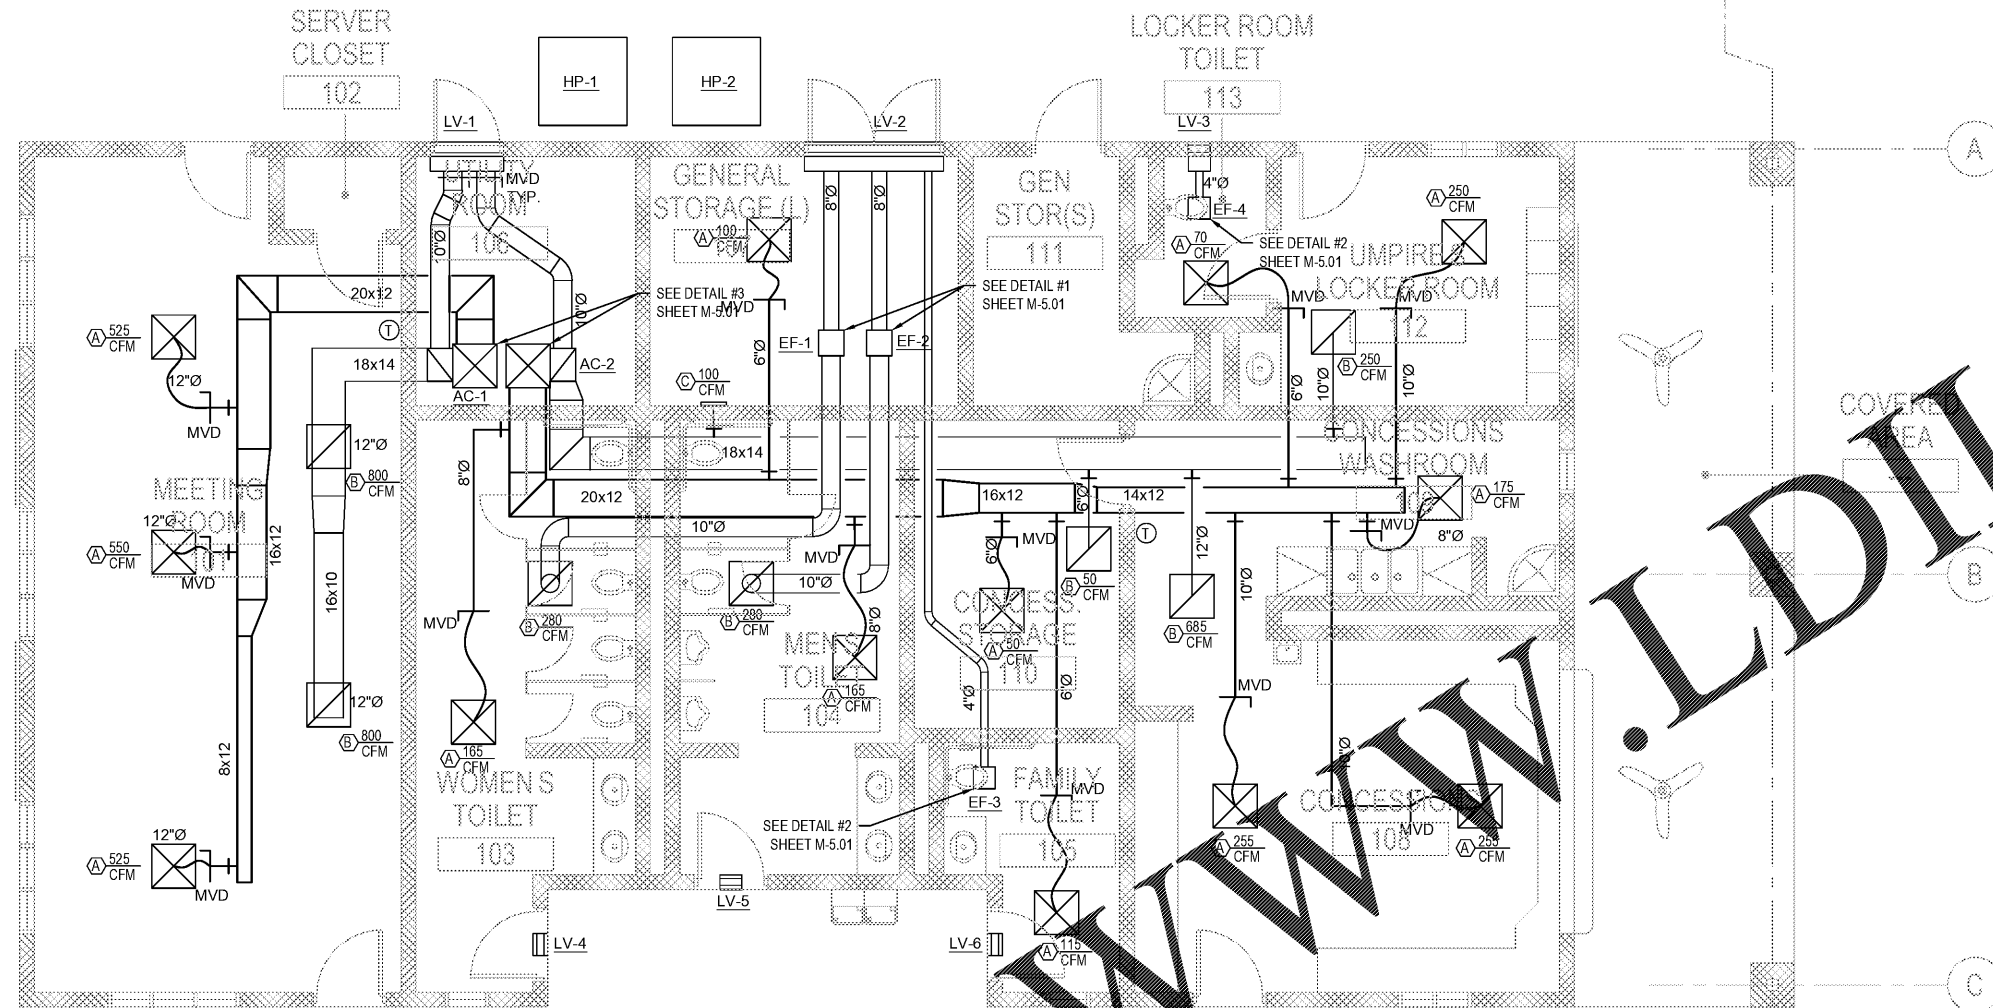

1 FIELDHOUSE HVAC PLAN  
 SCALE: 1/4" = 1'-0"

Order Plans @

WWW.LDILine.com

Robert and Company  
 Engineers, Architects, Planners  
 225 Franklin Street, N.E. International Tower  
 Atlanta, Georgia 30303  
 404-577-4000 FAX 404-577-7119


**SKYLINE**  
 ENGINEERING & CONSTRUCTION  
 P-888.706.0061 F-770.217.7530 www.skyline-ec.com

SYMBOL	DATE	BY	REVISION

PRELIMINARY  
 PRELIMINARY  
 PRELIMINARY

City of  
**Dunwoody**  
 BASEBALL FACILITIES AT  
 BROOK RUN PARK

 DESIGNED DRAWN CHECKED DATE  
 DF DUB WJB  
 PROJECT NO. C-1610-10 SCALE AS SHOWN  
 DRAWING TITLE FIELDHOUSE HVAC PLAN



DRAWING NO. M-1.01  
 SHEET OF

RAC #: 1700200