
 


- NOTES:**
- SEE SHEET M-001 FOR MECHANICAL PLUMBING NOTES, LEGEND AND ABBREVIATIONS.
 - REFER TO SHEET P-6.01 AND P-9.01 FIXTURE CONNECTION SCHEDULES.

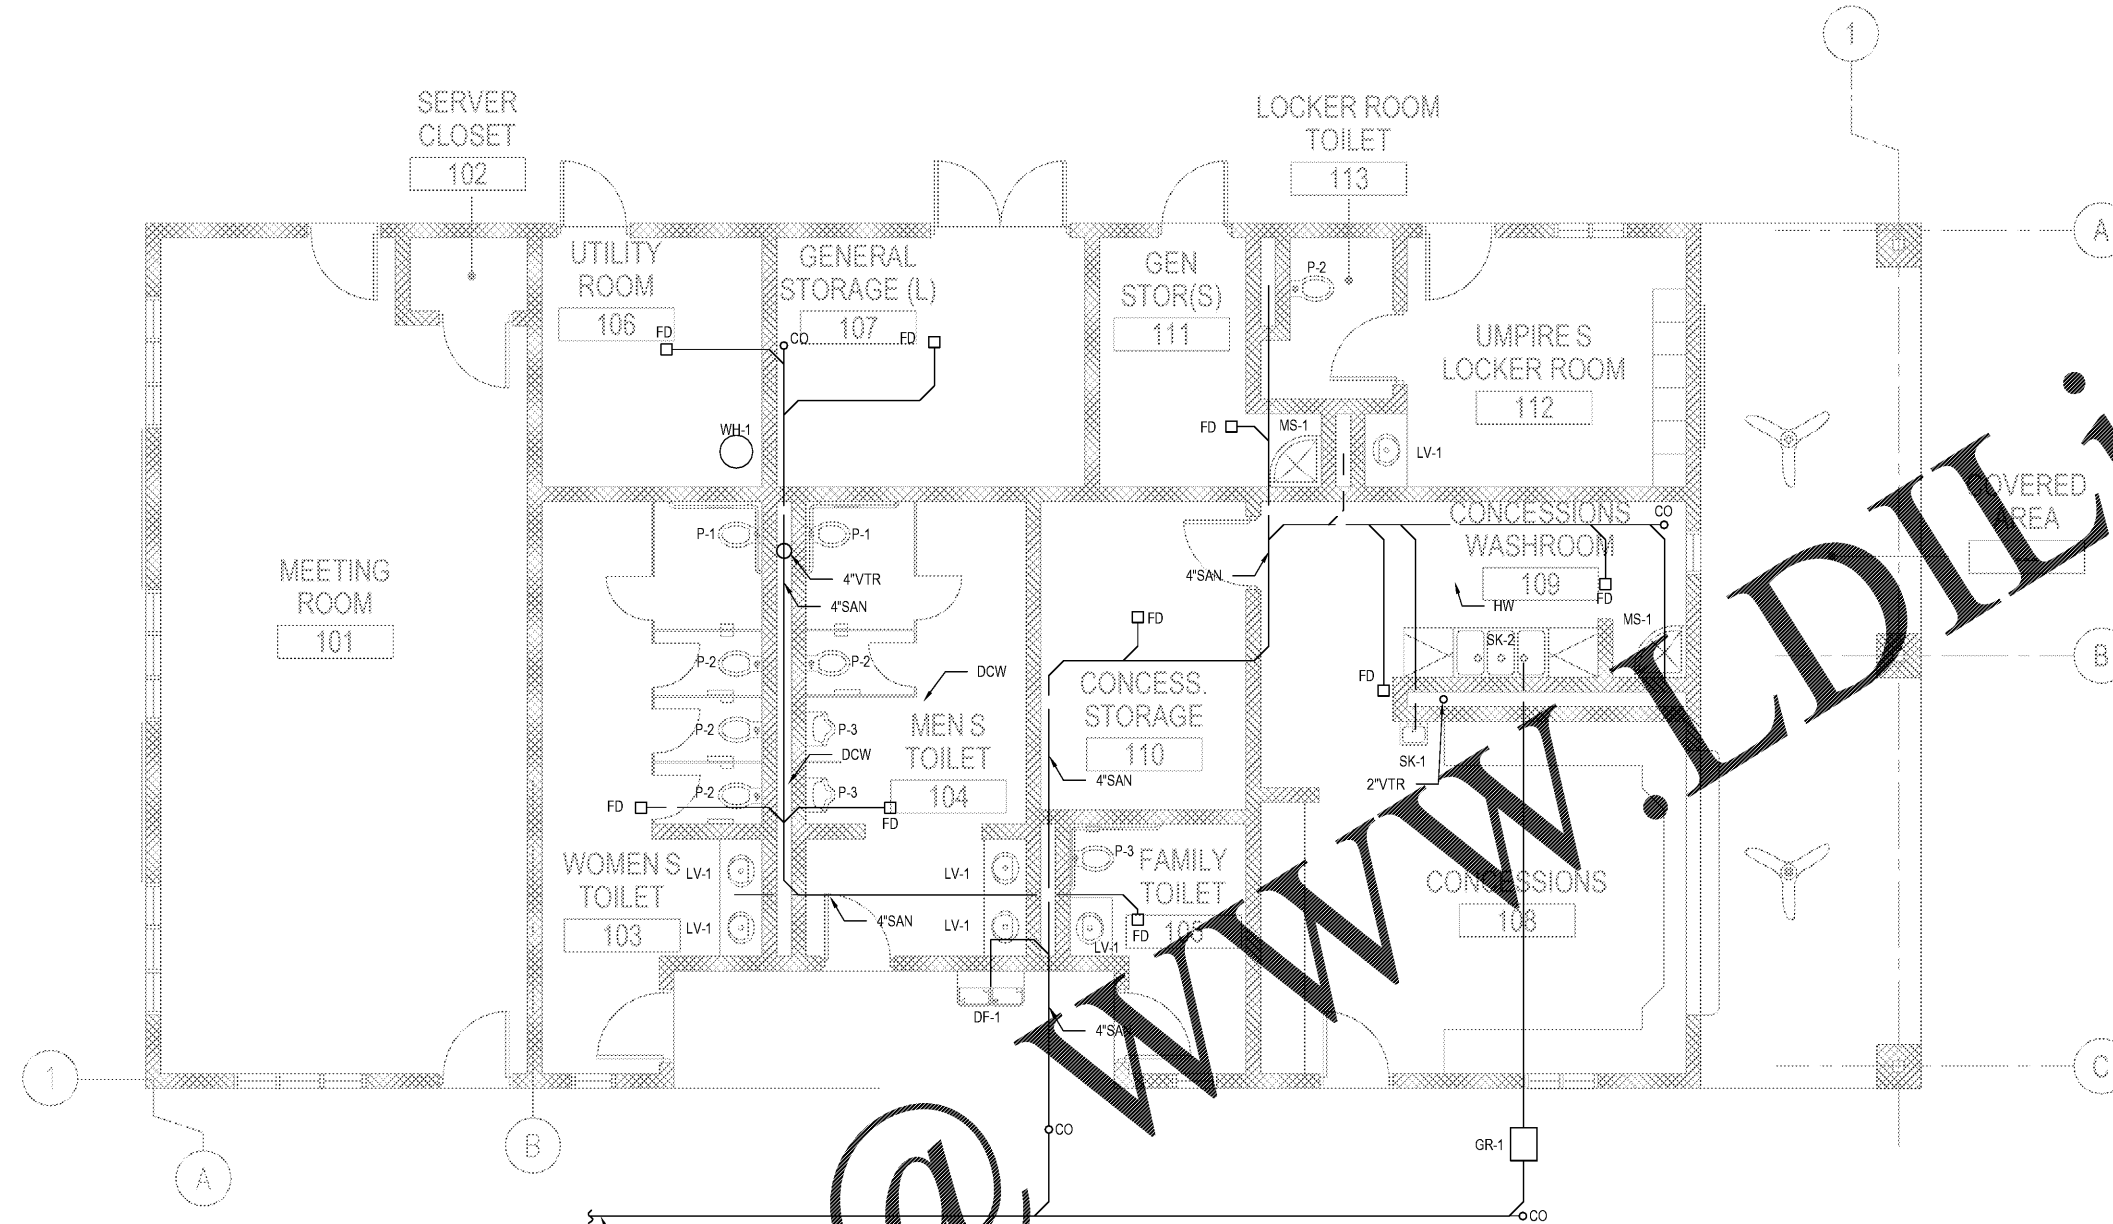

UG SAN. REF. TO CIVIL UTILITY PLAN, SHEET C-4.0

FIELDHOUSE SANITARY WASTE PLAN
SCALE: 1/4" = 1'-0"



Order Plans @

WWW.LDLine.com

Robert and Company
Engineers, Architects, Planners
225 Franklin Street, N.E. International Tower
Atlanta, Georgia 30303
404-577-4000 FAX 404-577-7119

SKYLINE
ENGINEERING & CONSTRUCTION
P-888.706.0661 F-770.217.7530 www.skyline-ec.com

SYMBOL	DATE	BY	REVISION

PRELIMINARY
PRELIMINARY
PRELIMINARY

City of
Dunwoody
PROJECT
BASEBALL FACILITIES AT
BROOK RUN PARK

DESIGNED DRAWN CHECKED DATE
DF DUB WJB
PROJECT NO. C-1610-10 SCALE AS SHOWN
DRAWING TITLE FIELDHOUSE SANITARY WASTE PLAN

DRAWING NO. P-1.01
SHEET OF

RAC #: 1700200