



- NOTES:**
- SEE SHEET M-0.01 FOR MECHANICAL PLUMBING NOTES, LEGEND AND ABBREVIATIONS.
 - REFER TO SHEET P-6.01 AND P-9.01 FIXTURE CONNECTION SCHEDULES.

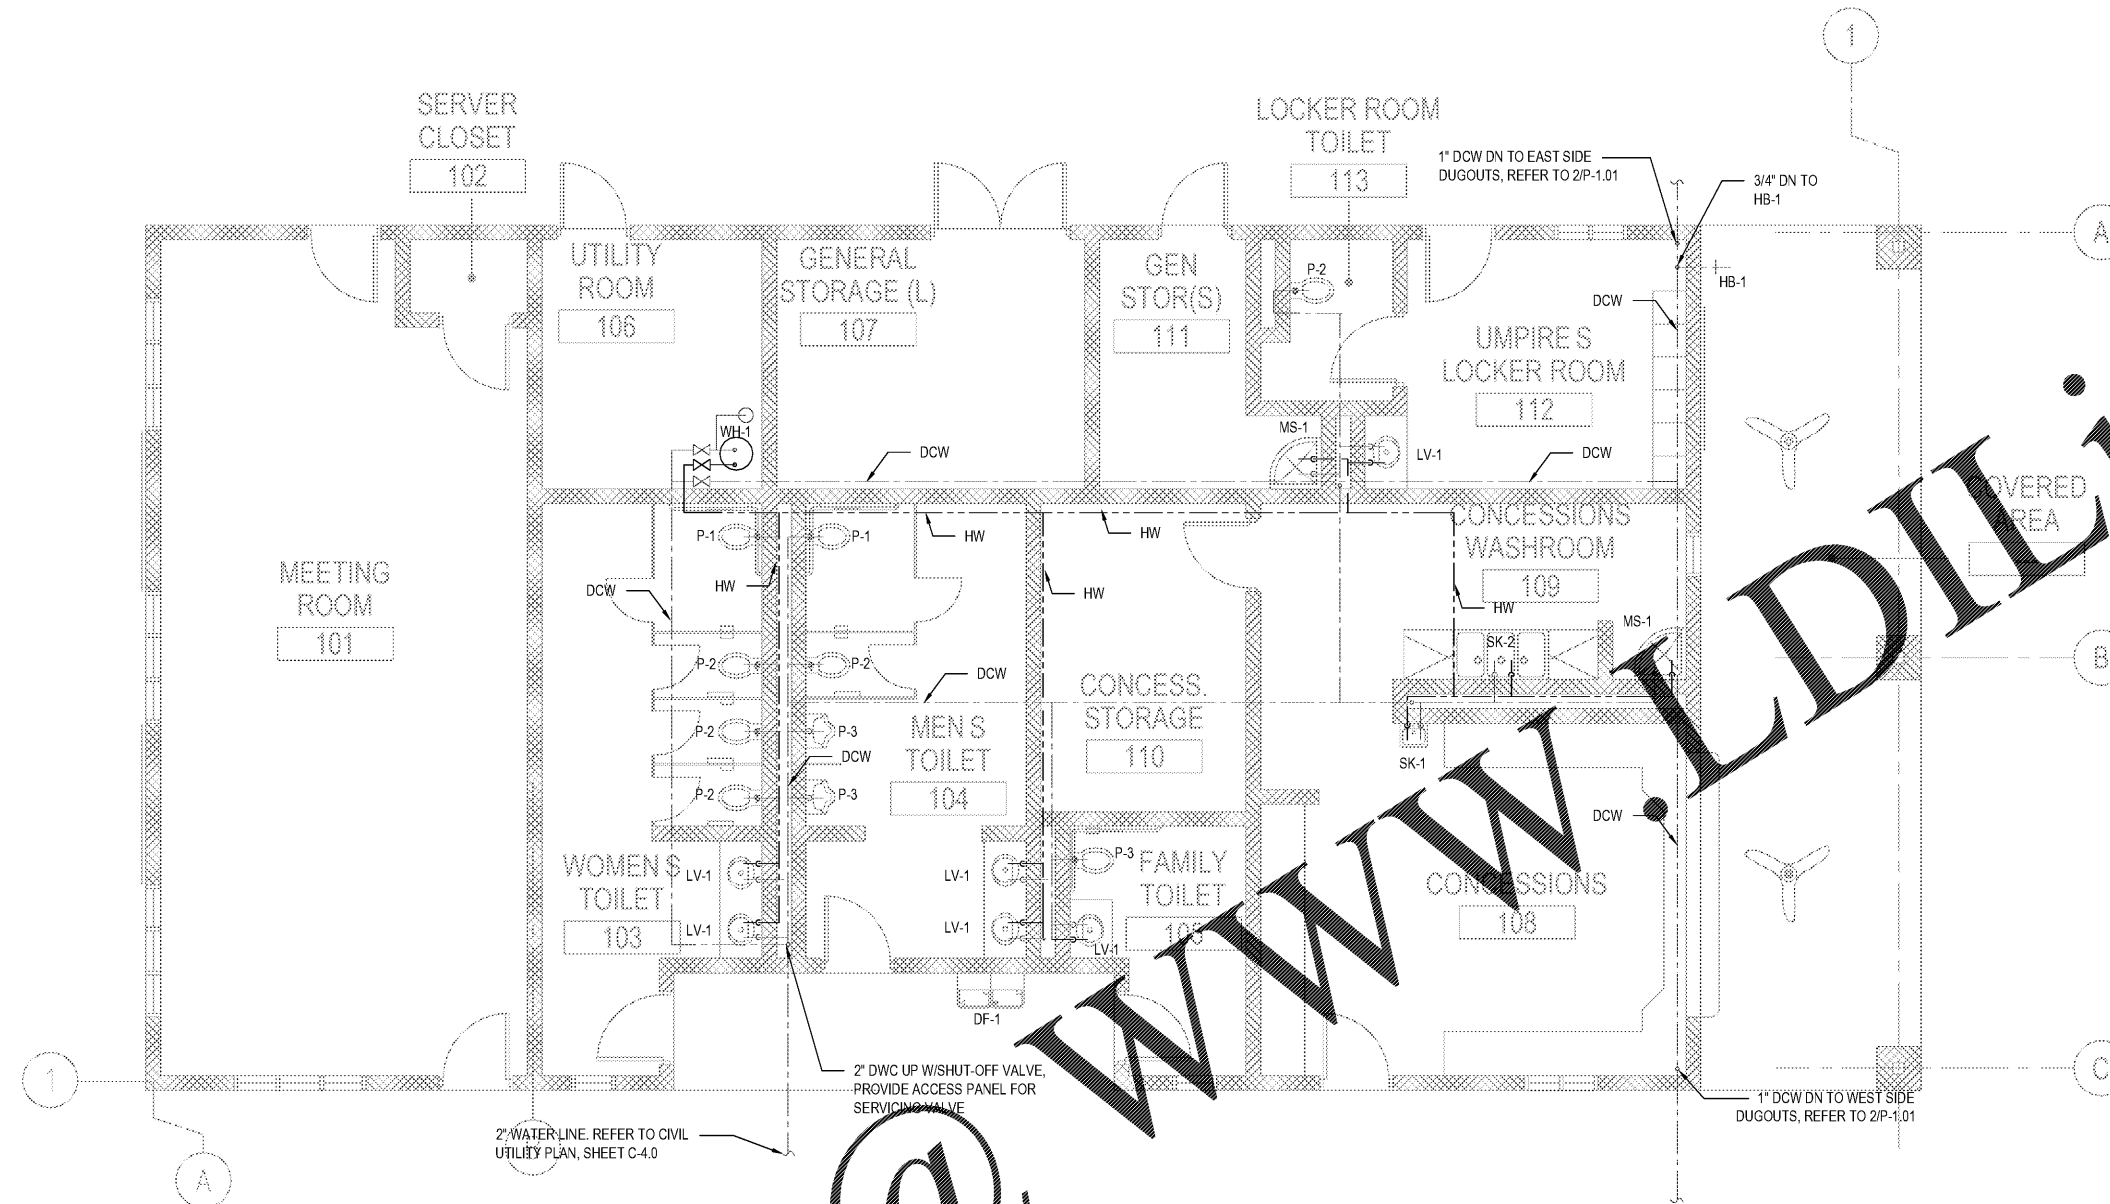


2" WATER LINE. REFER TO CIVIL UTILITY PLAN, SHEET C-4.0

2" DWC UP W/ SHUT-OFF VALVE. PROVIDE ACCESS PANEL FOR SERVICING VALVE

1 FIELDHOUSE DUGOUT WATER SUPPLY PLAN
SCALE: 1/4" = 1'-0"

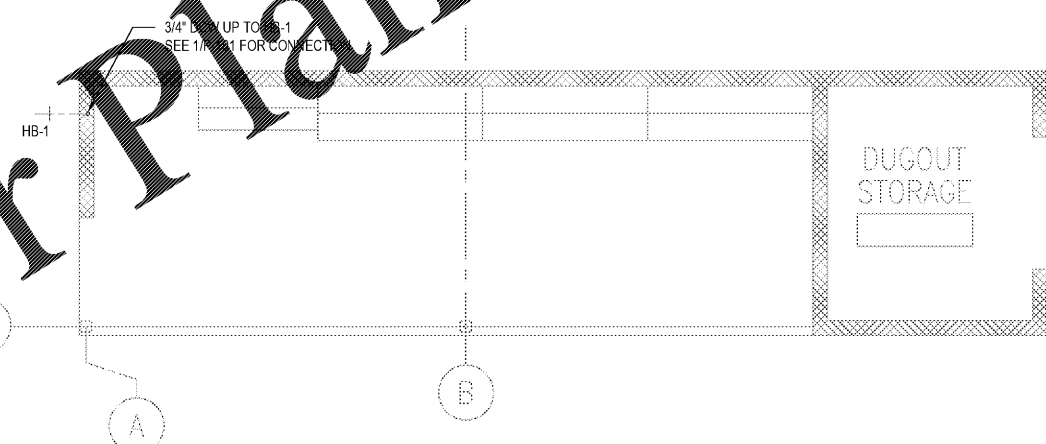

 2 TYPICAL DUGOUT WATER SUPPLY PLAN
SCALE: 1/4" = 1'-0"



Robert and Company
Engineers, Architects, Planners
225 Franklin Street, N.E. International Tower
Atlanta, Georgia 30303
404 577-4000 FAX 404 577-7119

SKYLINE
ENGINEERING & CONSTRUCTION
P-888.706.0061 F-770.217.7530 www.skyline-ec.com

SYMBOL	DATE	BY	REVISION

PRELIMINARY
PRELIMINARY
PRELIMINARY

City of
Dunwoody
BASEBALL FACILITIES AT
BROOK RUN PARK

DESIGNED DRAWN CHECKED DATE
DF DUB WBH
PROJECT NO. C-1610-10 SCALE AS SHOWN
DRAWING TITLE FIELDHOUSE & DUGOUT WATER SUPPLY PLAN

DRAWING NO.
P-1.02
SHEET OF

RAC #: 1700200

Order Plans @ www.WLDLine.com