


1 ELECTRIC WATER HEATER DETAIL
SCALE: NONE

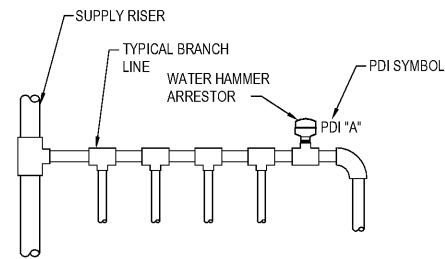


NOTES:


- PREFERRED INSTALL WATER HAMMER ARRESTORS AT THE END OF BRANCH LINE BETWEEN THE LAST TWO FIXTURES SERVED.
- ONE WATER HAMMER ARRESTOR PER 20' LINE, AND ANOTHER FOR BRANCHES OVER 20' IN LENGTH.
- THE SUM OF FIXTURE UNIT RATING OF UNITS OVER 20' IN LENGTH SHALL BE EQUAL TO OR GREATER THAN THE DEMAND OF THE BRANCHES.

WATER HAMMER ARRESTOR SCHEDULE						
PDI SYMBOL	A	B	C	D	E	F
FIXTURE UNIT RATING	1-11	12-32	33-60	61-113	114-154	155-330

3 WATER HAMMER ARRESTOR INSTALLATION DETAIL
SCALE: NONE

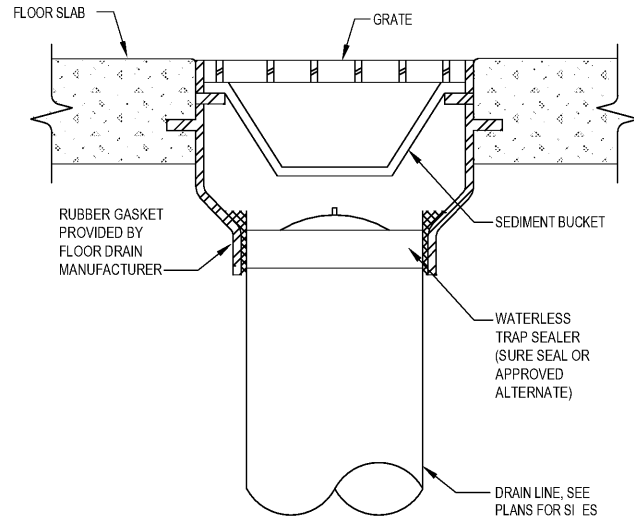

2 FLOOR DRAIN TRAP SEAL DETAIL
SCALE: NONE

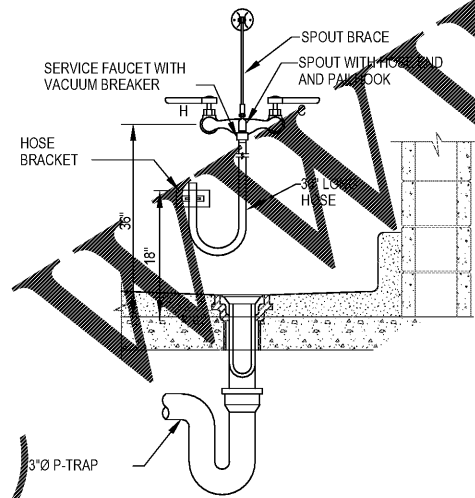

4 MOP SINK DETAIL
SCALE: NONE

NOTES:
1. SEE SHEET M-0.01 FOR MECHANICAL PLUMBING NOTES, LEGEND AND ABBREVIATIONS.

LDI and Company
Engineers, Architects, Planners
225 Foxshire Street, N.E. Atlanta, GA 30316
404-577-4000 FAX 404-577-7119

SKYLINE
ENGINEERING & CONSTRUCTION
P-888.706.0061 F-770.217.7530 www.skyline-ec.com

REVISION	DATE	BY	SYMBOL

PRELIMINARY
PRELIMINARY
PRELIMINARY

City of
Dunwoody
PROJECT
BASEBALL FACILITIES AT
BROOK RUN PARK

DESIGNED DRAWN CHECKED DATE
DF DUB WJB SCALE AS SHOWN
PROJECT NO. C-1610-10
DRAWING TITLE PLUMBING DETAILS

DRAWING NO.
P-5.01
SHEET OF

RAC #: 1700200

Order Plans

@

WWW.LDILine.com