


REVISIONS/ISSUANCES		
NO.	DATE	DESCRIPTION
03.23.17		BID

Willett
Engineering Company
Consulting Structural Engineers
 3528 Habersham at Northlake
 Tucker, Georgia 30084
 Phone: (770) 270-0444

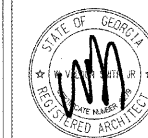

Manley Spangler Smith Architects
 A Professional Corporation

525 East Taylor St.
 P.O. Box 353
 Griffin, Georgia 30224
 Office 770.227.5473
 Fax 770.228.3442

PROJECT:
**Whitewater High School
 Multi-purpose Building**

CLIENT:
 Fayette County
 Schools

SHEET TITLE:
FOUNDATION PLAN

© 2017 Manley Spangler Smith Architects, PC

PROJECT NUMBER: 216028


DATE: 03.23.2017

SCALE: 1/8" = 1'-0"

DRAWN BY: SDV

CHECKED BY: JMW

SHEET NO.:
S1.1

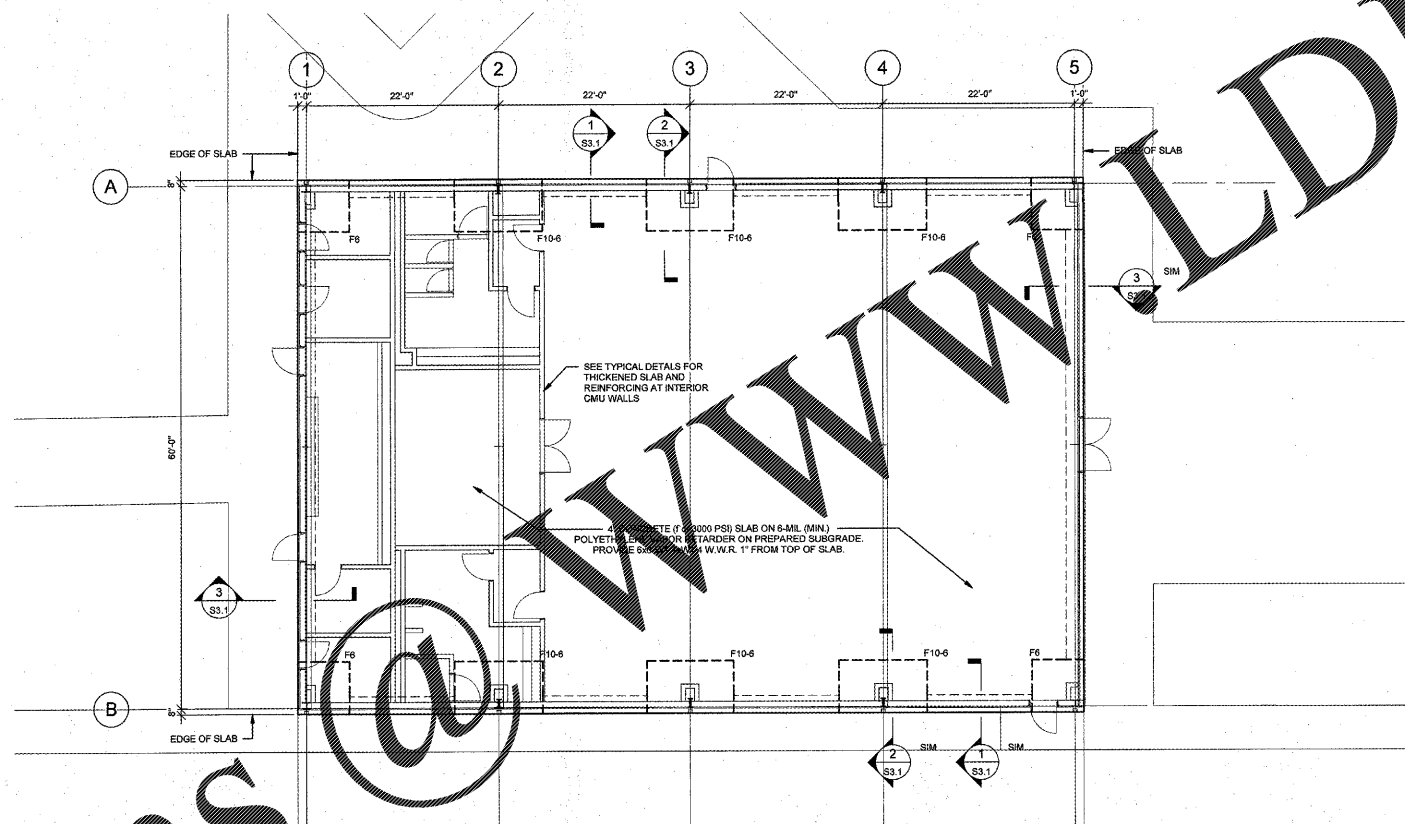

FOUNDATION PLAN

SCALE: 1/8" = 1'-0"

FOOTING SCHEDULE		
TYPE	SIZE	REINFORCING
F6	6'-0" x 6'-0" x 24"	(7) #6 E.W. TOP & BOTTOM
F10-6	10'-0" x 6'-0" x 24"	(7) #6 E.W. TOP & BOTTOM

FOOTING SIZES ARE BASED ON ESTIMATED COLUMN REACTIONS AND SHALL BE USED FOR PRICING PURPOSES ONLY. FINAL FOOTING SIZES ARE CONTINGENT ON "FIELD USE" DRAWINGS, INCLUDING ANCHOR BOLT LAYOUTS AND REACTIONS FROM PRE-ENGINEERED BUILDING MANUFACTURER.

Order Plans

WWW.LDILine.com