

KEYNOTE LEGEND	ROOF LEGEND	SHEET NOTES
7.19 OVERFLOW SCUPPER	⊗ EXHAUST FAN	1. REFER TO MECHANICAL DRAWINGS FOR VENTS AND FLUE LOCATIONS REF 3.4-A4.1
	□ RTU	2. PROVIDE CRICKET AT ALL MECHANICAL EQUIPMENT, RTU'S, ETC. INSTALL ROOFING INSULATION TO ACHIEVE MIN 1/4 INCH PER FOOT SLOPE TO PROVIDE POSITIVE DRAINAGE AROUND UNITS
	▭ AHU	3. PROVIDE BLOCKING AS REQUIRED TO MAINTAIN 6" OF THE CURB ABOVE ROOF AT CRICKETS
		4. REF A4.1 FOR TYPICAL ROOF PENETRATION DETAILS
		5. ALL FIELD INSTALLED SCREWS REQUIRE NEOPRENE WASHERS.

STIPULATION FOR THE...
 THE INFORMATION CONTAINED...
 IS FOR GENERAL INFORMATION...
 AND DOES NOT CONSTITUTE...
 A CONTRACT DOCUMENT...
 THE CONTRACT DOCUMENTS...
 SHALL GOVERN OVER THIS...
 DRAWING.
 CONTRACT NO. 1732-918-2300 / 1732-918-2351
 PROJECT NO. 1732-918-2300 / 1732-918-2351




CONSULTANTS
 WALMART
 APOPKA, FL
 STORE NO: 6894-00
 JOB NUMBER: 09715-006 | PHOTO

ISSUE BLOCK
 3 REV 5 04/07/17

CHECKED BY: MMA
 DRAWN BY: MMA
 FILE NAME: 41_2-A4
 PROTO CYCLE: 102816
 DOCUMENT DATE: 01/29/17

BID SET
 NOT FOR
 CONSTRUCTION

ROOF PLAN
 SHEET: A4

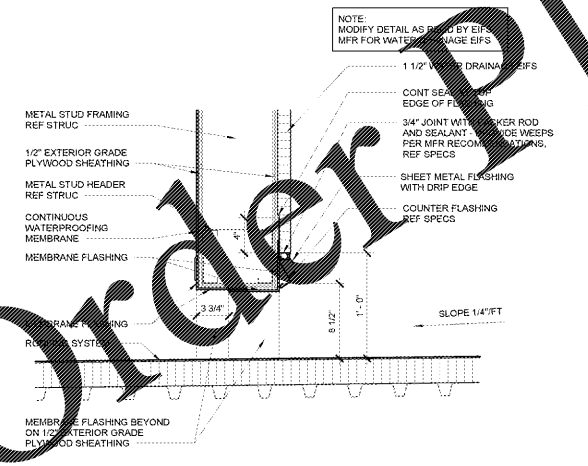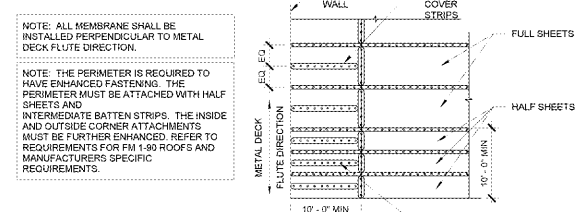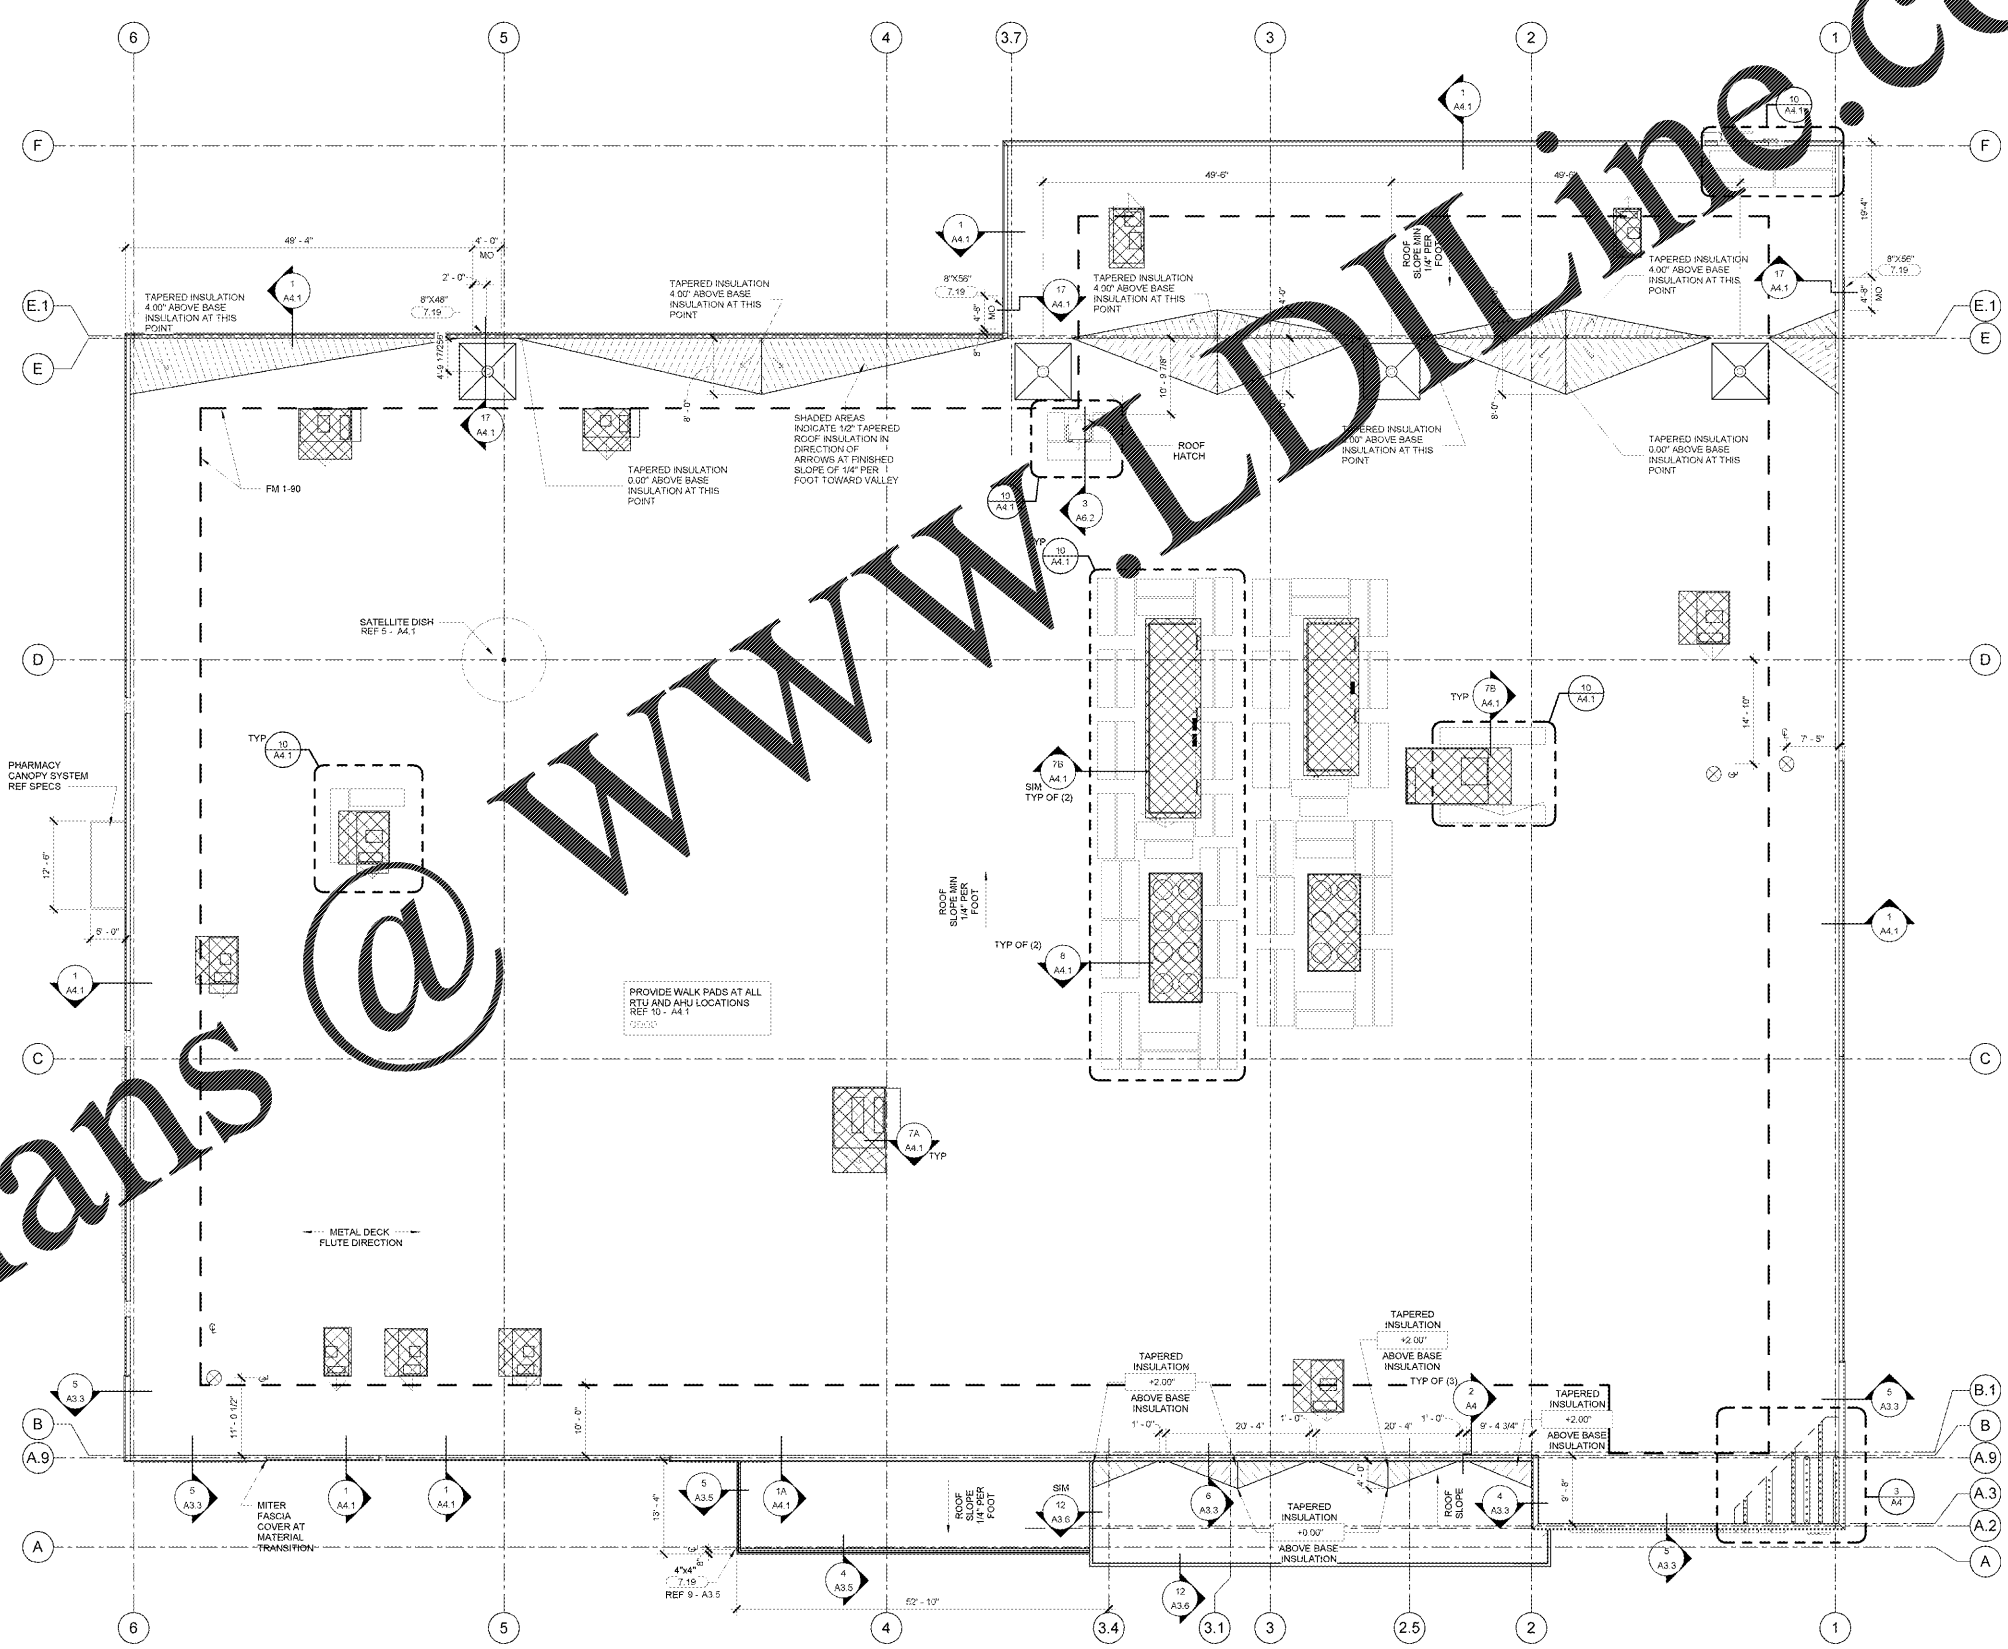

Order Plans @ WWW.LDLINE.COM

1732-918-2300 / 1732-918-2351