



SITE PLAN DESIGN NOTES & KEY PLAN

- | | | |
|-----|---|------------------|
| 1 | PAINTED-DIRECTIONAL-ARROW | DETAIL 1/C-4.0 |
| 2 | PAINTED DRIVE-THRU GRAPHICS | DETAIL 2/C-4.0 |
| 3 | PAINTED-STOP-LINE GRAPHIC | DETAIL 3/C-4.0 |
| 4 | PAINTED HANDICAP PARKING SYMBOL | DETAIL 4/C-4.0 |
| 5 | ACCESSIBLE PARKING STALL | DETAIL 5/C-4.0 |
| 5A | 60" PARKING STALL | DETAIL 5/C-4.0 |
| 5B | PARALLEL PARKING STALL | |
| 6 | DIRECTIONAL SIGNAGE (SEE SIGNAGE PACKAGE) | DETAIL 6/C-4.0 |
| 6A | "STOP" SIGN (SEE SIGNAGE PACKAGE) | DETAIL 6A/C-4.0 |
| 6B | "ACCESSIBLE PARKING" SIGN (SEE SIGNAGE PACKAGE) | DETAIL 6B/C-4.0 |
| 6C | "CURBSIDE DELIVERY" SIGN (SEE SIGNAGE PACKAGE) | |
| 6D | "RIGHT TURN ONLY" SIGN (SEE SIGNAGE PACKAGE) | DETAIL 6D/C-4.0 |
| 6E | "ONE WAY" SIGN (USE APPLICABLE DIRECTION) (SEE SIGNAGE PACKAGE) | DETAIL 6E/C-4.0 |
| 6F | "LEFT TURN ONLY" SIGN (SEE SIGNAGE PACKAGE) | DETAIL 6F/C-4.0 |
| 6G | "PEDESTRIAN CROSSWALK" SIGN (SEE SIGNAGE PACKAGE) | DETAIL 6G/C-4.0 |
| 6H | "DO NOT ENTER" SIGN (SEE SIGNAGE PACKAGE) | DETAIL 6H/C-4.0 |
| 6I | "NO PARKING" SIGN (SEE SIGNAGE PACKAGE) | |
| 6J | "TWO ORDER LANES" SIGN (SEE SIGNAGE PACKAGE) | |
| 6K | "LANES MERGE" SIGN (SEE SIGNAGE PACKAGE) | |
| 7 | SIDEWALK ACCESSIBLE RAMP | DETAIL 7/C-4.0 |
| 8 | CURB RAMP WITH FLARED SIDES | DETAIL 8/C-4.0 |
| 8A | CURB RAMP WITH SHORT FLARED SIDES | DETAIL 8A/C-4.0 |
| 9 | RETURNED CURB ACCESSIBLE RAMP | DETAIL 9/C-4.0 |
| 10 | TRUNCATED DOMES - CAST IN PLACE | DETAIL 10/C-4.0 |
| 11 | TYPICAL CONCRETE SIDEWALK | DETAIL 11/C-4.0 |
| 12 | SIDEWALK WITH CURB & GUTTER SECTION | DETAIL 12/C-4.0 |
| 13 | DRIVE-THRU PLAN | DETAIL 13/C-4.1 |
| 14 | DRIVE-THRU ISOMETRIC | DETAIL 14/C-4.1 |
| 15 | SOLID PLASTIC WHEEL STOP | DETAIL 15/C-4.1 |
| 16 | LANDSCAPE & IRRIGATION PROTECTOR | DETAIL 16/C-4.1 |
| 17A | SPILLING 24" CONCRETE CURB & GUTTER | DETAIL 17A/C-4.1 |
| 17B | CATCHING 24" CONCRETE CURB & GUTTER | DETAIL 17B/C-4.1 |
| 17C | DEPRESSED SPILLING 24" CONCRETE CURB & GUTTER | DETAIL 17C/C-4.1 |
| 17D | DEPRESSED CATCHING 24" CONCRETE CURB & GUTTER | DETAIL 17D/C-4.1 |
| 18 | ROLLOVER/MOUNTABLE CURB | DETAIL 18/C-4.1 |
| 19 | SCREENED REFUSE ENCLOSURE | DETAIL 19/C-4.1 |
| 19A | SCREENED REFUSE ENCLOSURE STAGGERED | DETAIL 19A/C-4.1 |
| 19B | SCREENED REFUSE ENCLOSURE ALTERNATE DRAINAGE | DETAIL 19B/C-4.1 |
| 20 | CONCRETE BOLLARD | DETAIL 20/C-4.1 |
| 21A | TYPICAL PAVEMENT SECTION - MEDIUM DUTY | DETAIL 21A/C-4.2 |
| 21B | TYPICAL PAVEMENT SECTION - HEAVY DUTY | DETAIL 21B/C-4.2 |
| 22 | TRANSVERSE & LONGITUDINAL CONTRACTION JOINT | DETAIL 22/C-4.2 |
| 23 | TRANSVERSE & LONGITUDINAL DOWELED CONSTRUCTION JOINT | DETAIL 23/C-4.2 |
| 24 | CONCRETE APRON @ TRASH ENCLOSURE | DETAIL 24/C-4.2 |
| 25 | CONCRETE PAVING DRIVE-THRU LANE | DETAIL 25/C-4.2 |
| 25A | CONCRETE PAVING CAR PARKING | DETAIL 25A/C-4.2 |
| 26 | STEEL HANDRAIL | DETAIL 26/C-4.2 |
| 27 | TYPICAL ADA RAMP AND HANDRAIL | DETAIL 27/C-4.2 |
| 28 | CONTRACTION JOINT | DETAIL 28/C-4.2 |
| 29 | KEYED CONSTRUCTION JOINT | DETAIL 29/C-4.2 |
| 30 | LONGITUDINAL BUTT JOINT | DETAIL 30/C-4.2 |
| 31 | EXPANSION JOINT | DETAIL 31/C-4.2 |
| 32 | MULTI-LANE DIRECTIONAL GRAPHICS | DETAIL 32/C-4.3 |
| 33 | PAINTED CROSS WALK | DETAIL 33/C-4.3 |
| 34 | MENU BOARD & CANOPY ORDERING STATION | DETAIL 34/C-4.3 |
| 35 | MENU BOARD LOOP DETECTION SYSTEM | DETAIL 35/C-4.3 |
| 36 | 5'x5' LANDING AND ENTRY DOOR FROST SLAB | DETAIL 36/C-4.3 |
| 37 | GREASE TRAP (SEE PLUMBING PLAN) | |
| 38 | ROOF DOWNSPOUT (TO CONNECT TO SITE DRAINAGE SYSTEM) | DETAIL 38/C-4.3 |
| 39 | LANDSCAPED AREA (SEE LANDSCAPE PLAN) | |
| 40 | CLEARANCE BAR (SEE SIGNAGE PACKAGE) | |
| 41 | PAVEMENT STRIPING AREA | DETAIL 41/C-4.3 |
| 42 | THICKENED SLAB EDGE AT RAILING CORE-DRILLS | DETAIL 42/C-4.4 |
| 43 | CONCRETE FLUME | DETAIL 43/C-4.4 |
| 44 | EX. ASPHALT / PROP. CONCRETE INTERFACE | DETAIL 44/C-4.4 |
| 45 | EX./PROP. ASPHALT INTERFACE | DETAIL 45/C-4.4 |
| 46 | EX./PROP. CONCRETE INTERFACE | DETAIL 46/C-4.4 |
| 47 | SINGLE BIKE RACK | DETAIL 47/C-4.4 |
| 48 | RELOCATED TRANSFORMER | |
| 49 | CHICK-FIL-A SIGN (SEE SIGNAGE PACKAGE) | |
| 50 | FLAGPOLE 50' (SEE SIGNAGE PACKAGE) | |
| 51 | RETAINING WALL WITH HANDRAIL ON TOP (HANDRAIL SIMILAR TO DETAIL 26/C-4.2) | |
| 52 | OUTDOOR PATIO SPACE - SEE ARCHITECTURAL PLAN SHEET A-1.1B | |
| 53 | 4" THICK CONCRETE STRIP BETWEEN BUILDING AND BACK | |
| 54 | 4" THICK CONCRETE STRIP BETWEEN CURBS | |
| 55 | 4" WIDE PAINT STRIPE | |
| 56 | CURB & GUTTER AT ACCESSIBLE RAMP | DETAIL 56/C-4.4 |

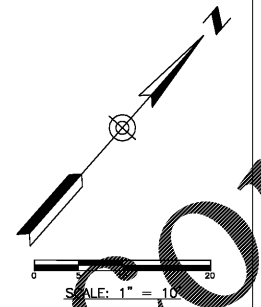

- LEGEND**
- EX. FIRE HYDRANT
 - EX. FIRE HYDRANT
 - PROP. VALVE
 - EX. VALVE
 - PROP. MANHOLE
 - EX. MANHOLE
 - PROP. INLET
 - EX. BOX INLET
 - EX. LIGHT POLE
 - PROP. LIGHT POLE
 - PROP. ACCESSIBLE RAMP - RAMP IS NOT TO BE SCORED OR GROOVED
 - EX. CURB
 - PROP. CURB & GUTTER
 - PROP. MEDIUM DUTY PAVEMENT 21A
 - PROP. HEAVY DUTY PAVEMENT 21B
 - PROP. CONCRETE PAVEMENT/WALK

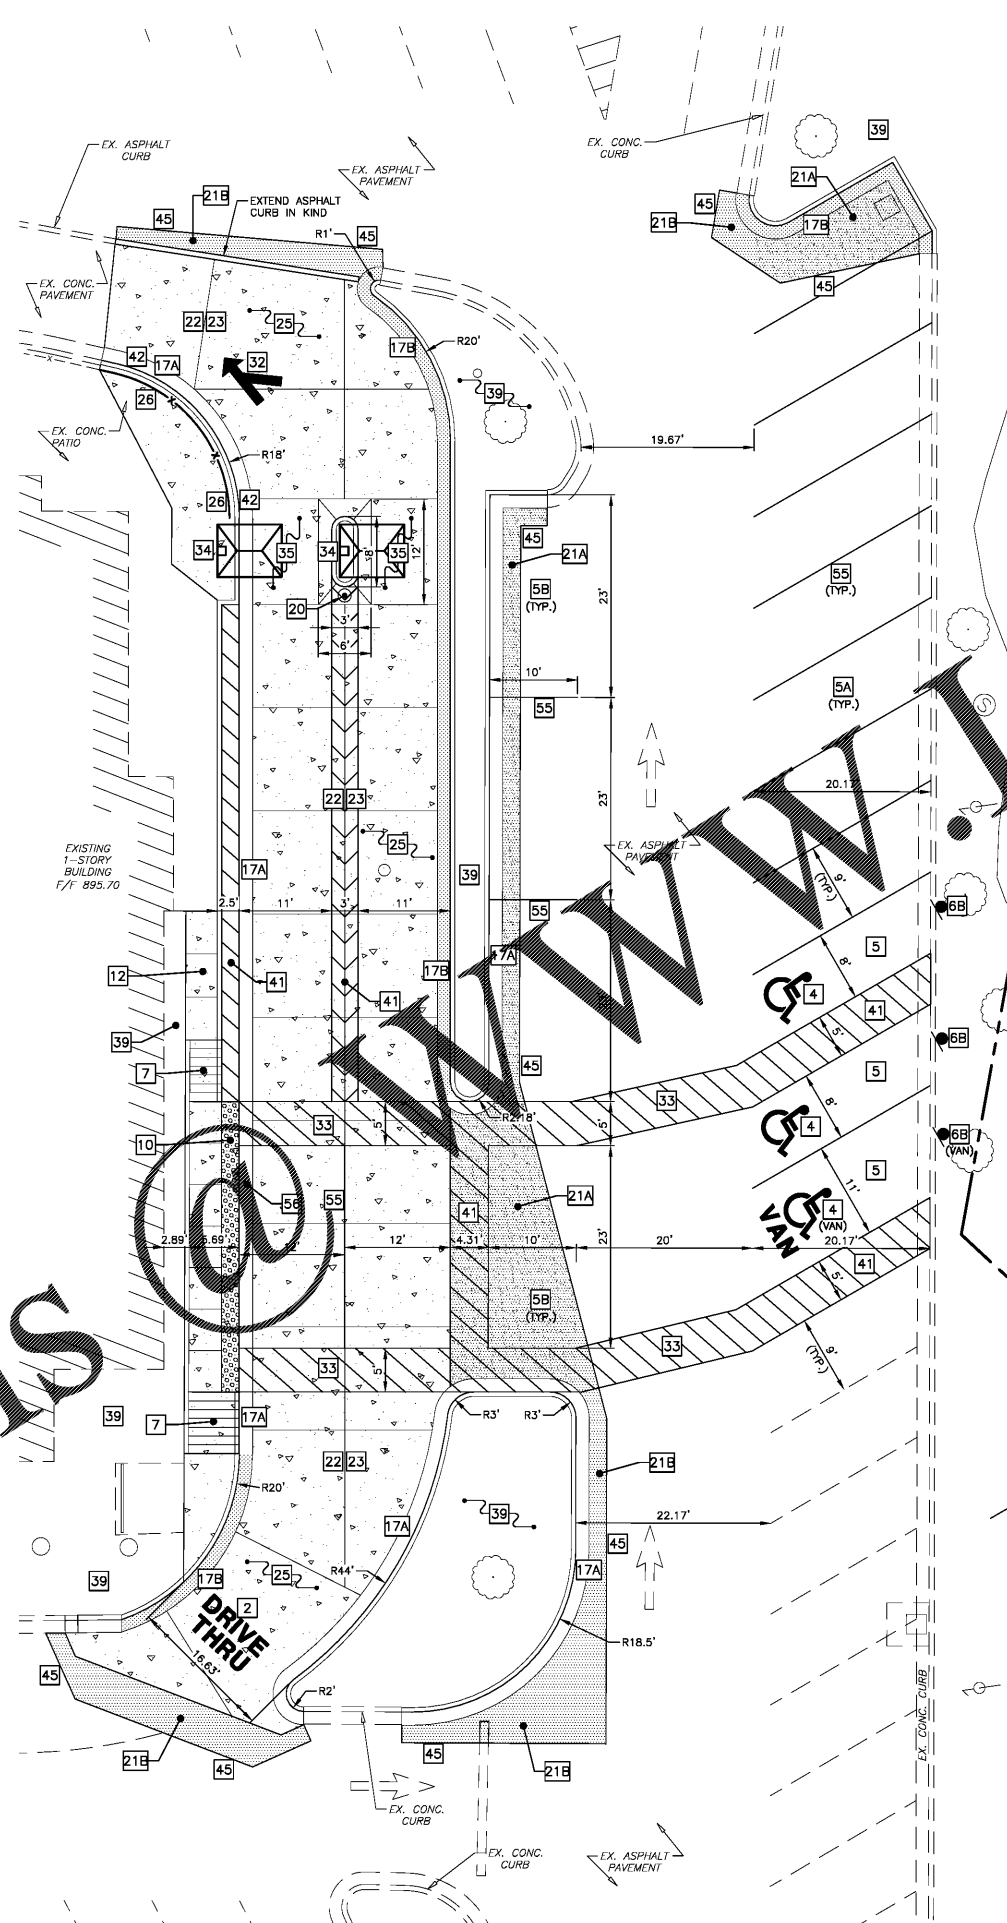

Chick-fil-A
5200 Buffington Road
Atlanta, Georgia 30349-2998

GBC DESIGN, INC.
565 White Pond Dr.
Akron, OH 44320-1123
Phone 330-836-0228
Fax 330-836-5782



CHICK-FIL-A
HOUSTON ROAD FSU
4980 HOUSTON ROAD
FLORENCE, KY 41042

FSU# 02593

NO.	DATE	DESCRIPTION
1	7/11/2017	ISSUED FOR BID

GBC PROJECT #	41141A
PRINTED FOR	Bid
DATE	7/5/17
DRAWN BY	B.A.W.

Information contained on this drawing and in all digital files produced for above named project may not be reproduced in any manner without express written or verbal consent from authorized project representatives.

SHEET ENLARGED SITE PLAN

SHEET NUMBER C-2.1

CONTRACTOR RESPONSIBLE TO FIELD VERIFY LOCATIONS AND ELEVATIONS OF EXISTING UTILITY TIE-INS AS SHOWN ON SITE PLANS (SANITARY, STORM, WATER, GAS, ELECTRIC, PHONE, ETC.) PRIOR TO THE START OF CONSTRUCTION. CONTACT ALLAN WILEY AT GBC DESIGN, INC., 330-836-0228, WITH ANY CONCERNS PRIOR TO THE START OF CONSTRUCTION.

Order Plans

WALDLINE