

FOR BID ONLY

FOR BID ONLY

WWW.DILLINE.COM


Order Plans

4 INTERIOR FINISH SCHEDULE

CEILING FINISHES	
ACT-1	CEILING TILE KITCHEN/BACK-OF-HOUSE CERTAINTED CEILINGS PERFORMA VINYLROCK #11 2-CRF-1 2'x2' x1/2" WHITE GRID STANDARD 15/1" S UARE LAY-IN GRID WHITE
WALL FINISHES	
FRP-2	FRP WALL PANELS AT KITCHEN MARLITE STANDARD FRP P-1 / BRIGHT WHITE .0 0" THICK PROVIDE MARLITE CORNER GUARDS AT ALL OUTSIDE CORNERS IN KITCHEN AREAS U.N.O.
PT-	PAINT # SHERWIN WILLIAMS - SHER-CRYL HIGH PERFORMANCE ACRYLIC #B - 50 COLOR - DARK BRONZE SEMI-GLOSS

CEILING TYPE LEGEND

SYMBOL	DESCRIPTION (NOT ALL APPLY)
A X-X'	NEW GYPSUM WALL BOARD CEILING ON FRAMES - PAINTED
B X-X'	NEW ACOUSTICAL CEILING AND SUSPENSION GRID SYSTEM
D X-X'	EXISTING CEILING TO REMAIN

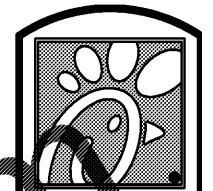

Chick-fil-e

5200 Buffington Rd.
Atlanta Georgia,
30349-2998

Revisions:

Mark	Date	By
△	06.30.17	ISSUED FOR PERMIT
△	07.10.17	BUILDING COMMENTS
△	07.11.17	ISSUED FOR BID

Seal

I HEREBY CERTIFY THAT THESE PLANS HAVE BEEN PREPARED UNDER MY SUPERVISION AND THAT TO THE BEST OF MY KNOWLEDGE, THEY COMPLY WITH ALL RULES, REGULATIONS, AND ORDINANCES OF JURISDICTION RELATING TO STRUCTURES AND BUILDINGS.

CHIPMAN DESIGN ARCHITECTURE INC.
JOHN CHIPMAN ARCHITECT
FIRST FLOOR EAST
4980 HOUSTON RD FLORENCE, KY 41042
PHONE 773.986.9900



STORE #02593
HOUSTON ROAD FSU


4980 HOUSTON RD
FLORENCE, KY
41042

SHEET TITLE
REFLECTED
CEILING PLAN

VERSION: S08C-R
ISSUE DATE: 05.2017

Job No. : 16-1511
Store : 02593
Date : 06.23.17
Drawn By : AS
Checked By: CL

Sheet
A-15

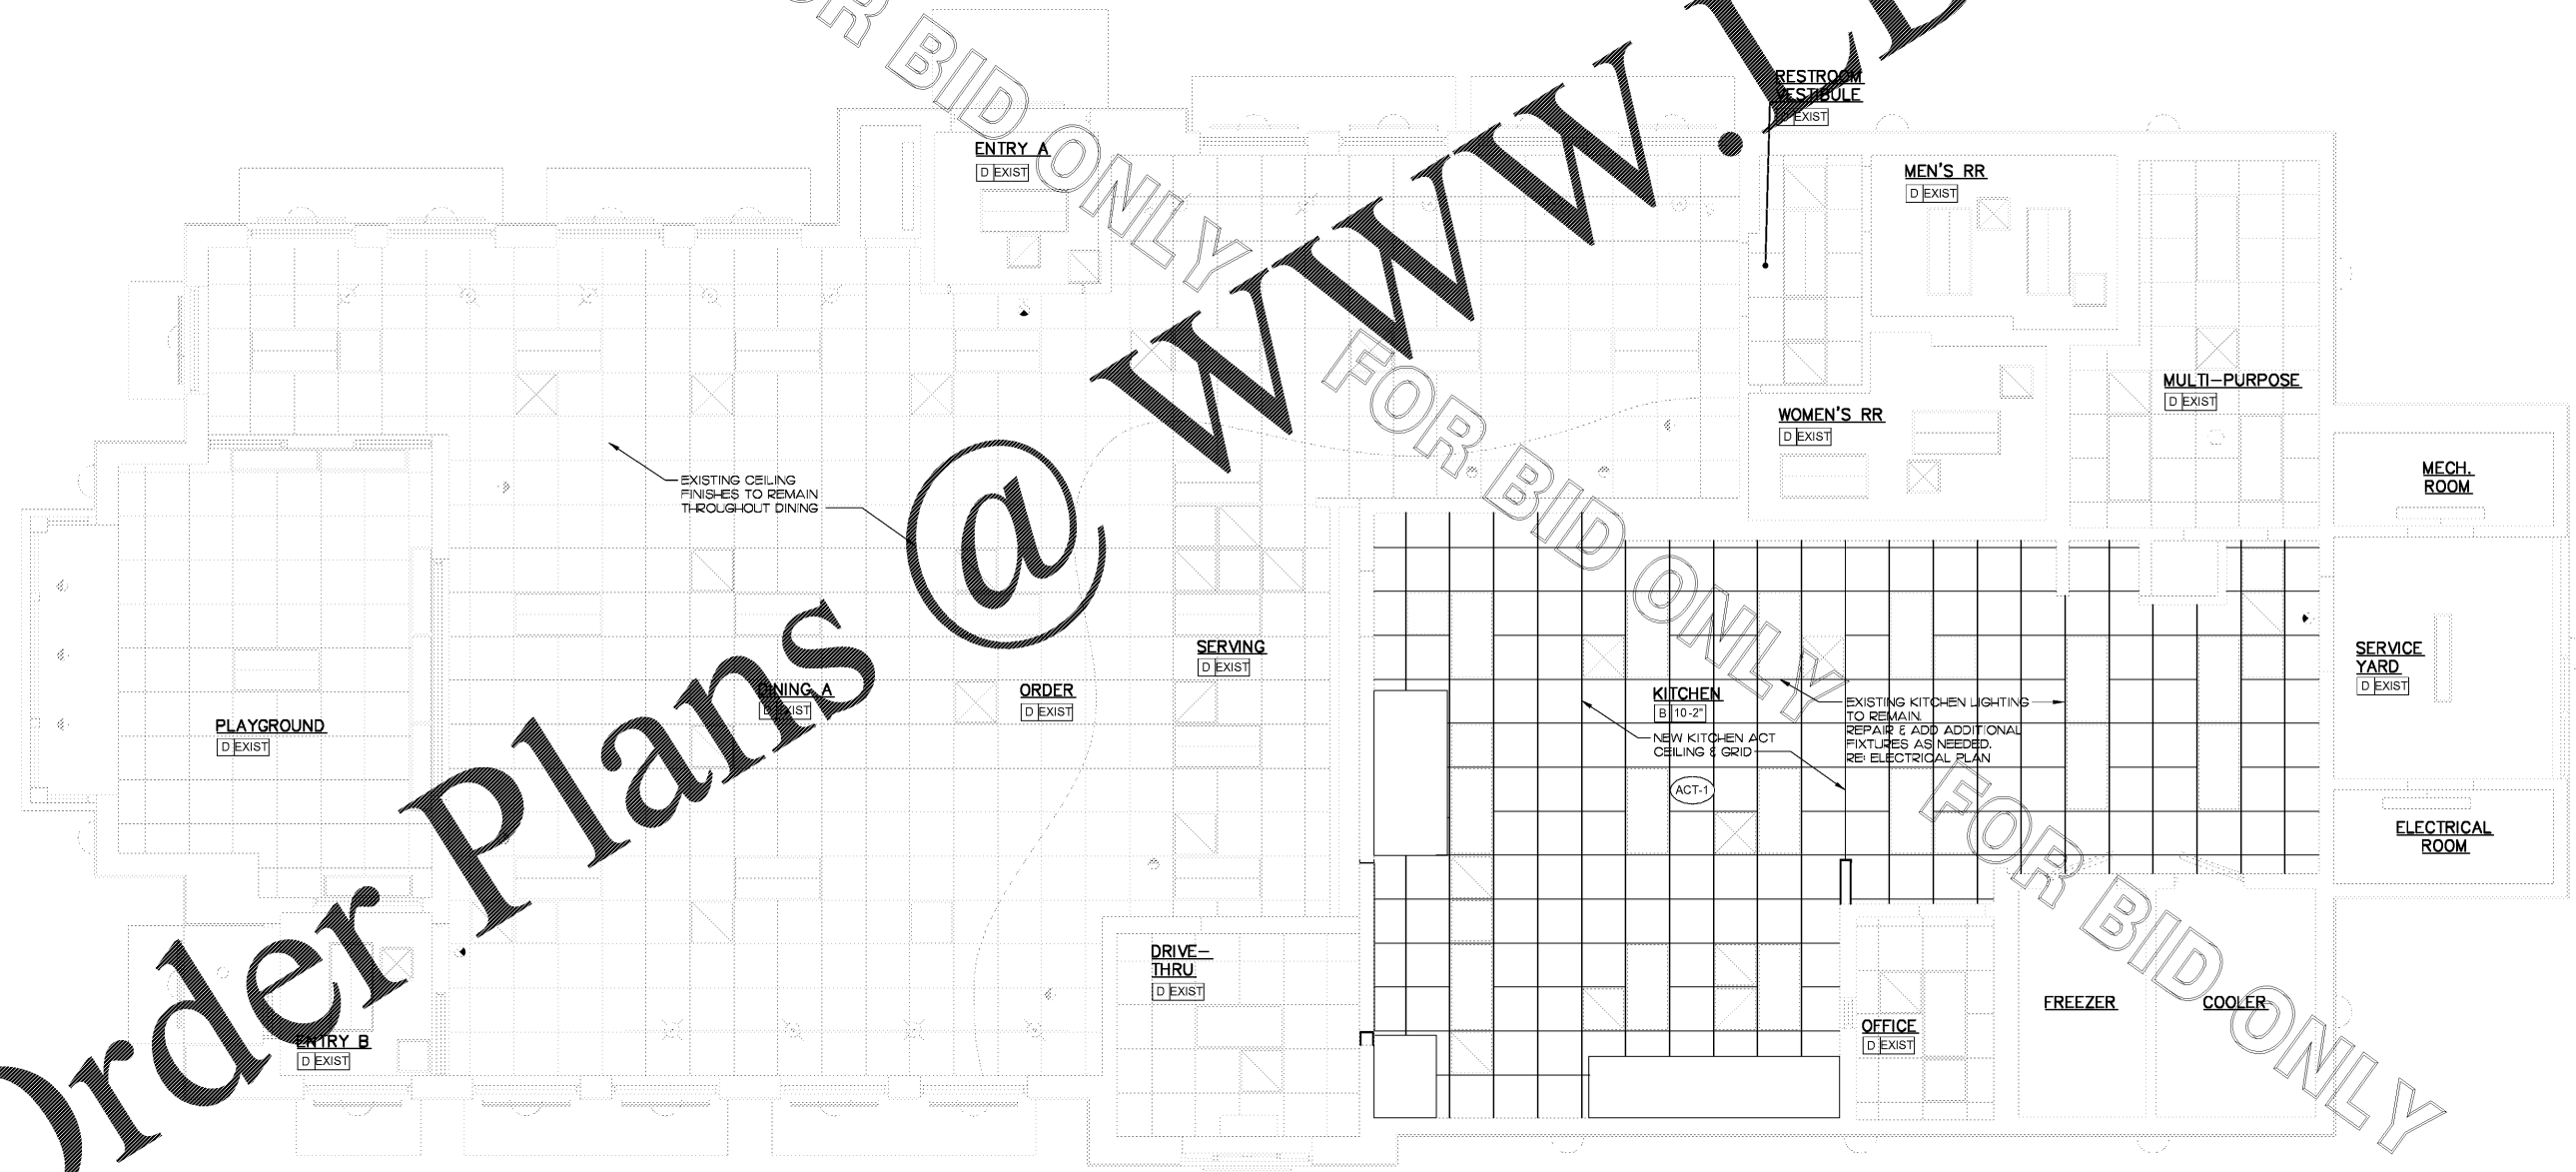

1 REFLECTED CEILING AND LIGHTING PLAN
SCALE: 1/4" = 1'-0"



NORTH