

SHEET NOTES

- COORDINATE INSTALLATION OF SANITARY PIPING WITH FOOTINGS IN THE FIELD. SLEEVE ALL NEW AND EXISTING PIPING PENETRATIONS IN FOOTINGS WITH PVC.
- WHERE REQUIRED BY LOCAL AUTHORITY HAVING JURISDICTION, PROVIDE SAFE-WASTE SYSTEM AS OUTLINED IN STATE AND LOCAL CODE AMENDMENTS.
- ALL WATER PIPING INSTALLED WITHIN EXTERIOR WALLS SHALL BE LOCATED ON THE INTERIOR SIDE OF THE INSULATION.
- ALL VENT PIPING TO BE 1-1/2" DIAMETER UNO.
- HOLD ALL PIPING ABOVE THE CEILING TIGHT TO STRUCTURE. DUCT LOCATIONS TAKE PRIORITY. SEE DRAWING MJI FOR DUCT LAYOUT. COORDINATE CONFLICTS WITH GC.
- SEE K-SHEET ELEVATIONS FOR KITCHEN EQUIPMENT WATER PIPING ROUGH-IN LOCATIONS.
- UNLESS NOTED OTHERWISE, WATER PIPING SHALL BE COPPER OR CPVC AS LISTED IN SPECIFICATIONS. SEE SPECIFICATIONS.

KEY NOTES

- CONNECT NEW WASTE LINE TO EXISTING AS SHOWN. VERIFY FALL, FLOW DIRECTION AND CONNECTING INVERTS. PROVIDE VENT CONNECTION TO EXISTING SYSTEM WHERE APPLICABLE.
- ROUTE NEW VENT LINE UP IN WALL TO ABOVE CEILING. MAKE CONNECTION TO EXISTING VENT HEADER OF SAME SIZE OR LARGER. WHERE DRAIN IS LOCATED IN NEW ADDITION, ROUTE VENT LINE UP IN WALL AND ABOVE CEILING INTO EXISTING BUILDING AND MAKE NECESSARY CONNECTION.
- PROVIDE AND INSTALL NEW WASTE PIPING BELOW KITCHEN SINK. PROVIDE 2" SCHED 40 PVC INDIRECT WASTE MANIFOLD (1-1/2" DRAIN FROM EACH SINK BASIN) TO FLOOR SINK. NO P-TRAPS REQUIRED. PROVIDE CLEANOUT AT EACH END.

FLOOR FIXTURES:

IMPORTANT! INSTALL FLOOR DRAINS SUCH THAT 3 FT. DIAM. SLAB DEPRESSION AROUND DRAIN SLOPES 1 INCH. SEE ARCHITECTURAL AND STRUCTURAL FLOOR PLANS. COORD. FLOOR DRAIN ELEVATIONS WITH CONCRETE FINISHER.

FIXTURE CONNECTION SCHEDULE

MARK	FIXTURE	FW	FW2	CW	TW	HW	WASTE
P-5	KITCHEN HAND SINK - WALL HUNG (0.50 GPM)	X	X	1/2"	X	1/2"	1/2"
P-10	FLOOR DRAIN (ROUND TOP)	X	X	X	X		

PLUMBING CONTRACTOR SHALL ROUTE ALL NEW VENT LINES SHOWN AND NOTED UP IN WALL AND TO ABOVE CEILING AND MAKE CONNECTION TO NEAREST VENT HEADER THE SAME SIZE OR LARGER.

PLUMBING CONTRACTOR SHALL VERIFY LOCATION, INVERT ELEVATION AND FLOW DIRECTION OF EXISTING LINE PRIOR TO ANY WORK. COORDINATE WITH ALL OTHER UTILITIES LOCATED BELOW GROUND PRIOR TO ANY EARTHWORK.

PIPING LEGEND (This Sheet)


EXISTING FLOOR DRAIN	FD
EXISTING FLOOR SINK	FS
EXISTING GREASE WASTE (EGW)	---EGW---
NEW GREASE WASTE (GW)	---GW---
EXISTING SANITARY SEWER (ESS)	---ESS---
EXISTING WATER UNDER GROUND (CW/HW)	---CW---
NEW WATER UNDER GROUND (CW, HW, TW OR FW/FW2)	---CW---
POINT OF CONNECTION	●
FLOOR DRAIN	□ ○
FLOOR SINK	■
FLOOR/EXTERIOR CLEANOUT	⊙

FLOOR FIXTURE ELEVATIONS

IMPORTANT! INSTALL THE FLOOR FIXTURE SUCH THAT THE TOP-OF-RIM ELEVATION IS AS FOLLOWS:

FIXTURE	TYPE	RIM ELEVATION
P-10	FLOOR DRAIN	1/2" BFF

NOTE: THE RIM ELEVATIONS SHOWN HERE SHOULD MATCH THE DEPRESSED SLAB. CONFIRM WITH ARCHITECTURAL PLANS. SEE ARCHITECTURAL PLANS FOR FLOOR SLOPE AT SLAB DEPRESSION FOR FIXTURES INSTALLED BELOW FINISHED FLOOR ELEVATION. FLOOR FIXTURES NOT LISTED HERE SHALL BE INSTALLED FLAT AND FLUSH WITH FINISHED FLOOR ELEVATION.

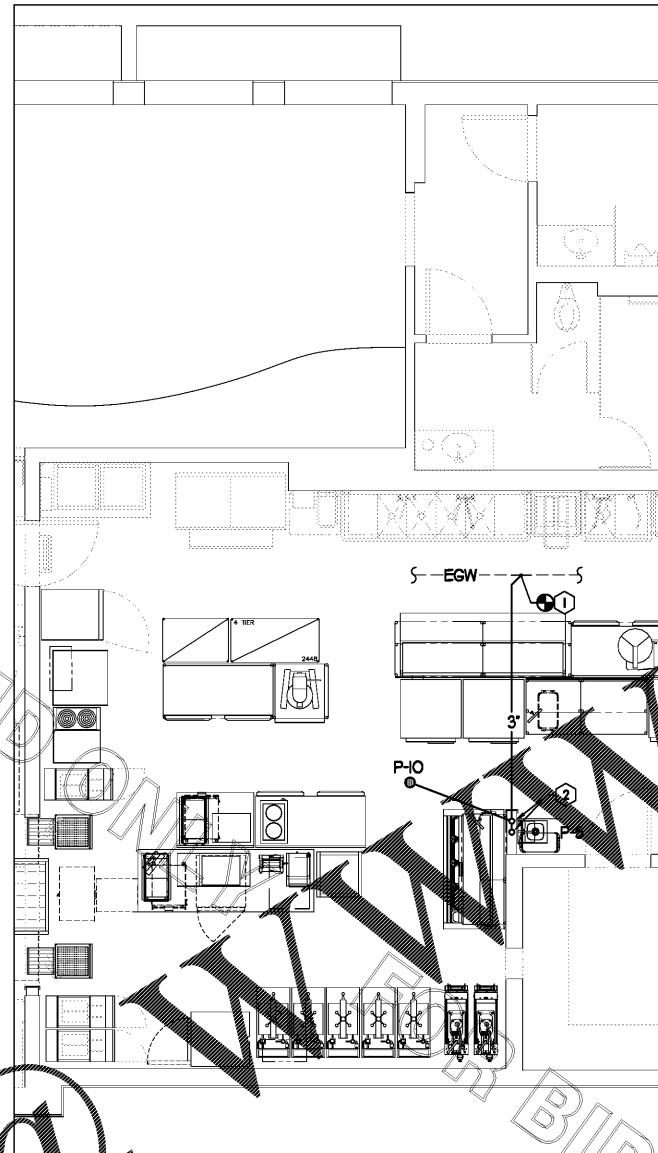

1 BELOW SLAB PLUMBING PLAN

SCALE: 1/4"=1'-0"



2 ABOVE SLAB PLUMBING PLAN

SCALE: 1/4"=1'-0"



Chick-fil-e

5200 Buffington Rd.
Atlanta Georgia,
30349-2998

Revisions:

Mark	Date	By
△	06.30.17	ISSUED FOR PERMIT

Mark	Date	By
△	07.11.17	ISSUED FOR BID

Mark	Date	By
△		

Seal



Kurzynske & Associates
CONSULTING ENGINEERS
2900 Lebanon Pike, Ste 201
Nashville, Tennessee 37214
Telephone: (615) 255-5203
Fax: (615) 255-5207
Email: mail@kurzynske.com

STORE #02593
HOUSTON ROAD FSU

4980 HOUSTON RD
FLORENCE, KY
41042

SHEET TITLE
NEW PLUMBING PLAN

VERSION: S08C-R
ISSUE DATE: 05.2017

Job No. :17091.CD.R
Store : 02593
Date : 06.30.17
Drawn By : BF
Checked By : MK

Sheet

PII

Order Plans

FOR BID ONLY