


FOR BID ONLY

FOR BID ONLY

Order Plans

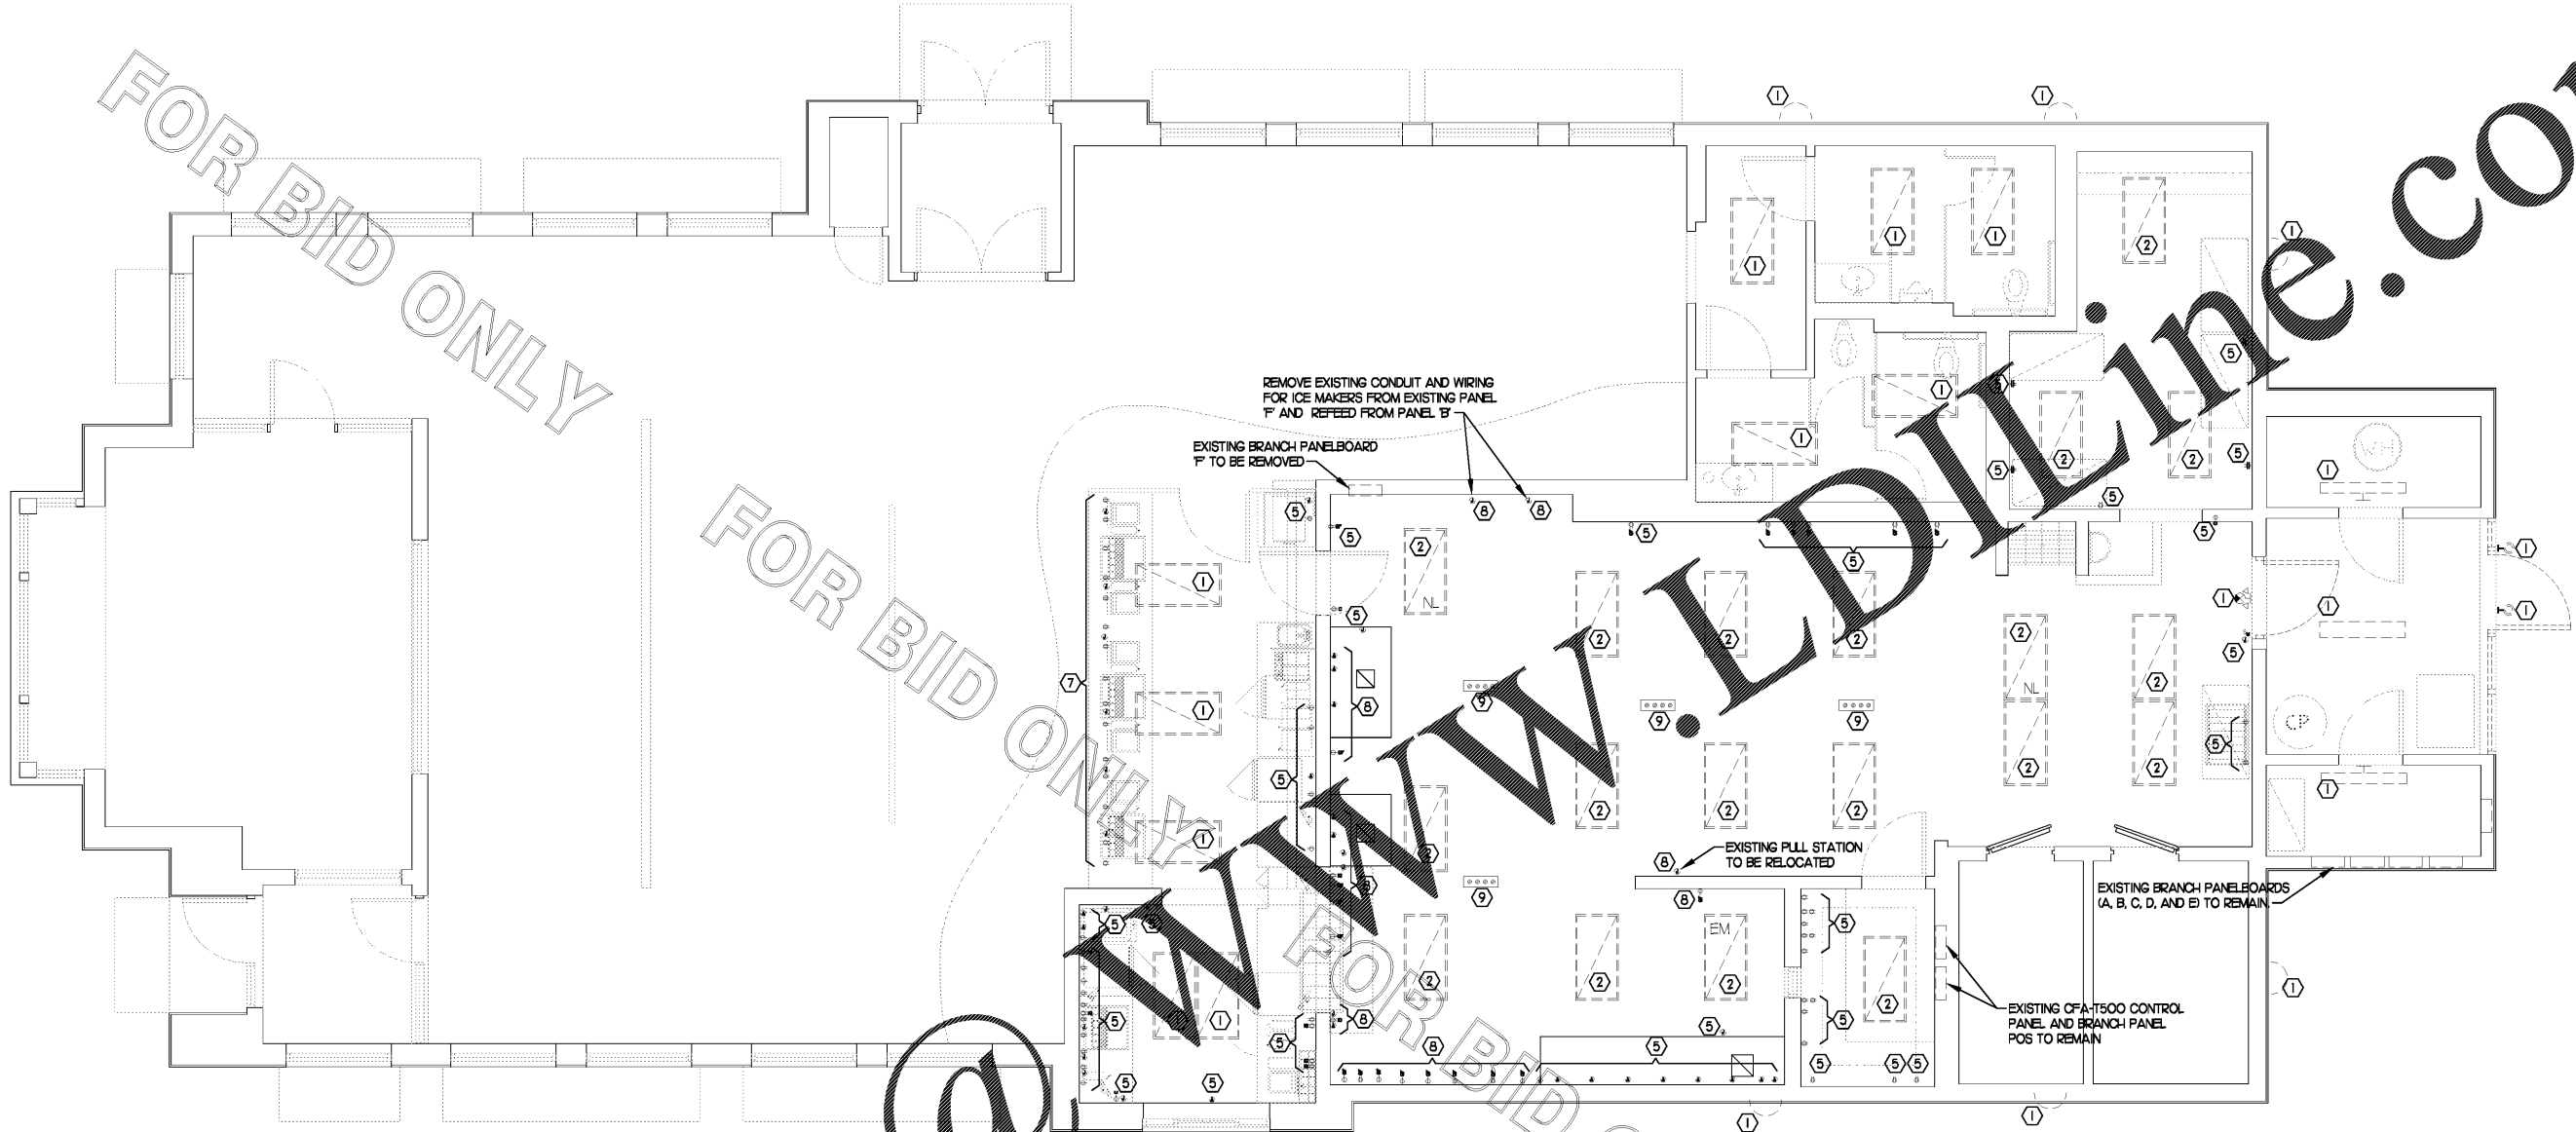

1 ELECTRICAL DEMOLITION PLAN
SCALE: 1/4"=1'-0"

- 2 KEYNOTES (APPLY TO THIS SHEET ONLY)**
- ① EXISTING LIGHTING FIXTURE TO REMAIN
 - ② EXISTING LIGHTING FIXTURE TO REMAIN. CLEAN AND RELAMP THE FIXTURE. IF EXISTING CEILING IS REPLACED, REMOVE AND REINSTALL EXISTING FIXTURES IN THE REPLACEMENT CEILING. VERIFY FIXTURE LOCATION WITH THE LIGHTING PLAN AND THE REFLECTED CEILING PLAN, RECONNECT TO THE EXISTING BRANCH CIRCUIT.
 - ③ EXISTING LIGHTING FIXTURE TO BE REMOVED AND REPLACED. SEE THE LIGHTING FLOOR PLAN.
 - ④ EXISTING LIGHTING FIXTURE TO BE REMOVED. EXISTING BRANCH CIRCUIT WIRING TO BE REUSED IF POSSIBLE AND FEASIBLE.
 - ⑤ EXISTING WIRING DEVICE/JUNCTION BOX TO REMAIN.
 - ⑥ NOT USED.
 - ⑦ EXISTING ELECTRICAL ITEMS IN THE SERVING COUNTER TO REMAIN.
 - ⑧ EXISTING ELECTRICAL ITEMS TO BE REMOVED AND RELOCATED. SEE THE POWER FLOOR PLAN FOR THE REUSE OF THE EXISTING CIRCUITS.
 - ⑨ EXISTING CEILING MOUNTED ELECTRICAL DROP CORD ASSEMBLY TO BE REMOVED OR RELOCATED.



Chick-fil-A

5200 Buffington Rd.
Atlanta Georgia,
30349-2998

Revisions:
Mark Date By
△ 06.30.17
ISSUED FOR PERMIT

Mark Date By
△ 07.11.17
ISSUED FOR BID

Mark Date By
△

Seal
STATE OF KENTUCKY
MARK T. KURZYNSKI
REGISTERED PROFESSIONAL ENGINEER
07-11-17

Kurzynske & Associates
CONSULTING ENGINEERS
2900 Lebanon Pike, Ste. 201
Nashville, Tennessee 37214
Telephone: (615) 255-5203
Fax: (615) 255-5207
Email: mail@kurzynske.com

STORE #02593
HOUSTON ROAD FSU

4980 HOUSTON RD
FLORENCE, KY
41042

SHEET TITLE
ELECTRICAL
DEMOLITION PLAN

VERSION: S08C-R
ISSUE DATE: 05.2017

Job No. :17091.CD.R
Store : 02593
Date: :06.30.17
Drawn By : RW
Checked By: MK

Sheet
E2.0