


NOTE FOR GF TYPE RECEPTACLES:
 THE CONTRACTOR SHALL PROVIDE GROUND FAULT PROTECTION FOR ALL 120 VOLT, 15 AND 20 AMP RECEPTACLE OUTLET BRANCH CIRCUITS IN THE KITCHEN/FOOD PREPARATION AREAS. GROUND FAULT PROTECTION SHALL BE PROVIDED AT THE RECEPTACLE VIA A GROUND FAULT TYPE RECEPTACLE UNLESS OTHERWISE NOTED ON THE PLANS. SEE FLOOR PLAN FOR ADDITIONAL INFORMATION.
 REPLACEMENT OF EXISTING RECEPTACLES WITH GFCI TYPE (OR DROP CORD CIRCUITS WITH GFCI TYPE BREAKERS) MAY BE REQ'D - FIELD VERIFY.

THE INFORMATION USED TO DEVELOP THE EXISTING CONDITIONS AS SHOWN ON THESE PLANS IS FROM PREVIOUS BUILDING DRAWINGS. WHAT WAS SHOWN ON PLAN AND WHAT WAS ACTUALLY INSTALLED MAY VARY. FIELD VERIFY ALL EXISTING CONDITIONS.

XX X-XX, AMP/POLE
 REFER TO THE KITCHEN ELEVATIONS FOR THE ROUGH-IN HEIGHT

KITCHEN EQUIPMENT MARK NUMBER, SEE SCHEDULE FOR REQUIREMENTS
 PANEL AND CIRCUIT NUMBER
 BRANCH BREAKER SIZE (AMP/POLES). REFER TO THE CONDUIT AND CONDUCTOR SCHEDULE FOR WIRE AND CONDUIT SIZE RELATED TO THE BREAKER (VERIFY)

2 KITCHEN EQUIP NOMENCLATURE
 NO SCALE
 REFER TO SHEET E23 FOR THE KEYNOTES ON THIS SHEET.

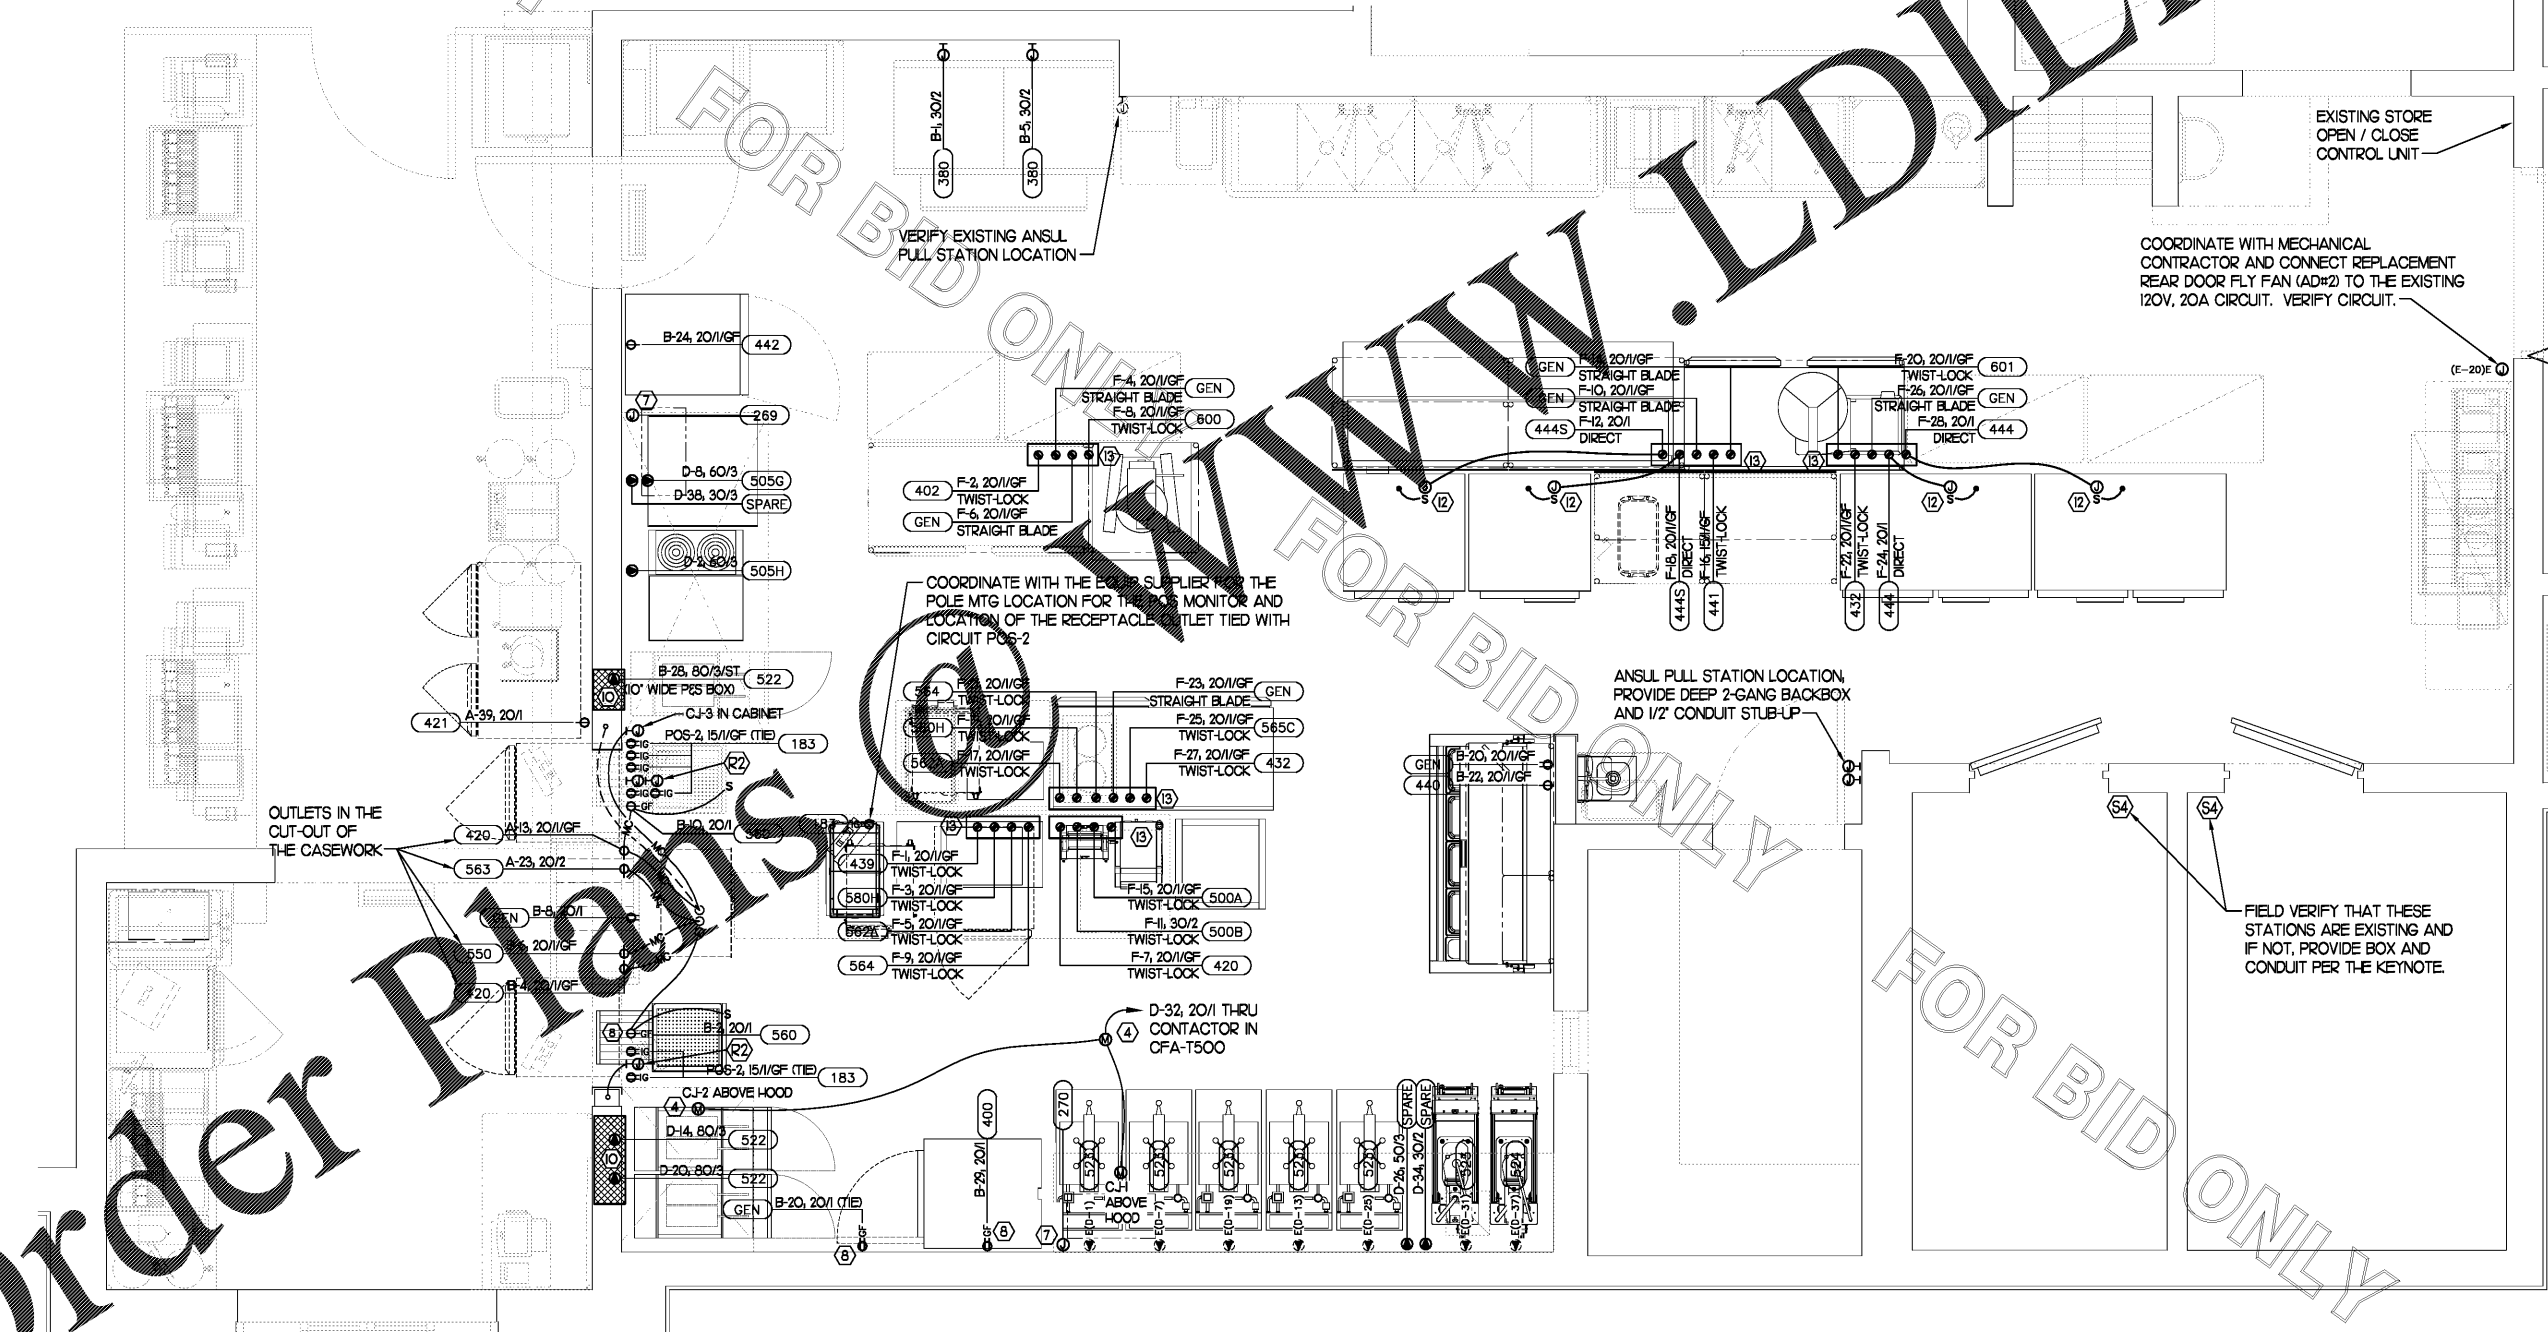

1 LARGE SCALE KITCHEN POWER PLAN
 SCALE: 1/2" = 1'-0"


Order Plans

FOR BID ONLY

FOR BID ONLY

FOR BID ONLY

FOR BID ONLY

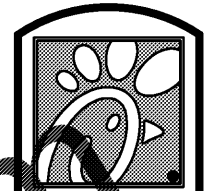

Chick-fil-Cee

5200 Buffington Rd.
 Atlanta Georgia,
 30349-2998

Revisions:
 Mark Date By
 △ 06.30.17 ISSUED FOR PERMIT
 △ 07.11.17 ISSUED FOR BID

Mark Date By
 △

Seal
 STATE OF KENTUCKY
 MARK T. KURZYNSKI
 01-11-17

Kurzynski & Associates
 CONSULTING ENGINEERS
 2900 Lebanon Pike, Ste 201
 Nashville, Tennessee 37214
 Telephone: (615) 255-5203
 Fax: (615) 255-5207
 Email: mail@kurzynske.com

STORE #02593
 HOUSTON ROAD FSJ

4980 HOUSTON RD
 FLORENCE, KY
 41042

SHEET TITLE
 LARGE SCALE
 KITCHEN POWER

VERSION: S08C-R
 ISSUE DATE: 05.2017

Job No. : 17091.CD.R
 Store : 02593
 Date : 06.30.17
 Drawn By : RW
 Checked By: MK

Sheet
E2.2