



Chick-fil-ee

5200 Buffington Rd.
Atlanta Georgia,
30349-2998

Revisions:

Mark	Date	By
△	06.30.17	
ISSUED FOR PERMIT		

Mark	Date	By
△	07.11.17	
ISSUED FOR BID		

Mark	Date	By
△		

Mark	Date	By
△		

Seal



Kurzynske & Associates
CONSULTING ENGINEERS
2900 Lebanon Pike, Ste 201
Nashville, Tennessee 37214
Telephone: (615) 255-5203
Fax: (615) 255-5207
Email: mail@kurzynske.com

STORE #02593
HOUSTON ROAD FSU

4980 HOUSTON RD
FLORENCE, KY
41042

SHEET TITLE
**EXHAUST FANS
& A/C UNITS**

VERSION: S08C-R
ISSUE DATE: 05.2017

Job No. : 17091.CD.R

Store : 02593


Date : 06.30.17

Drawn By : RW

Checked By: MK

Sheet

E2.4

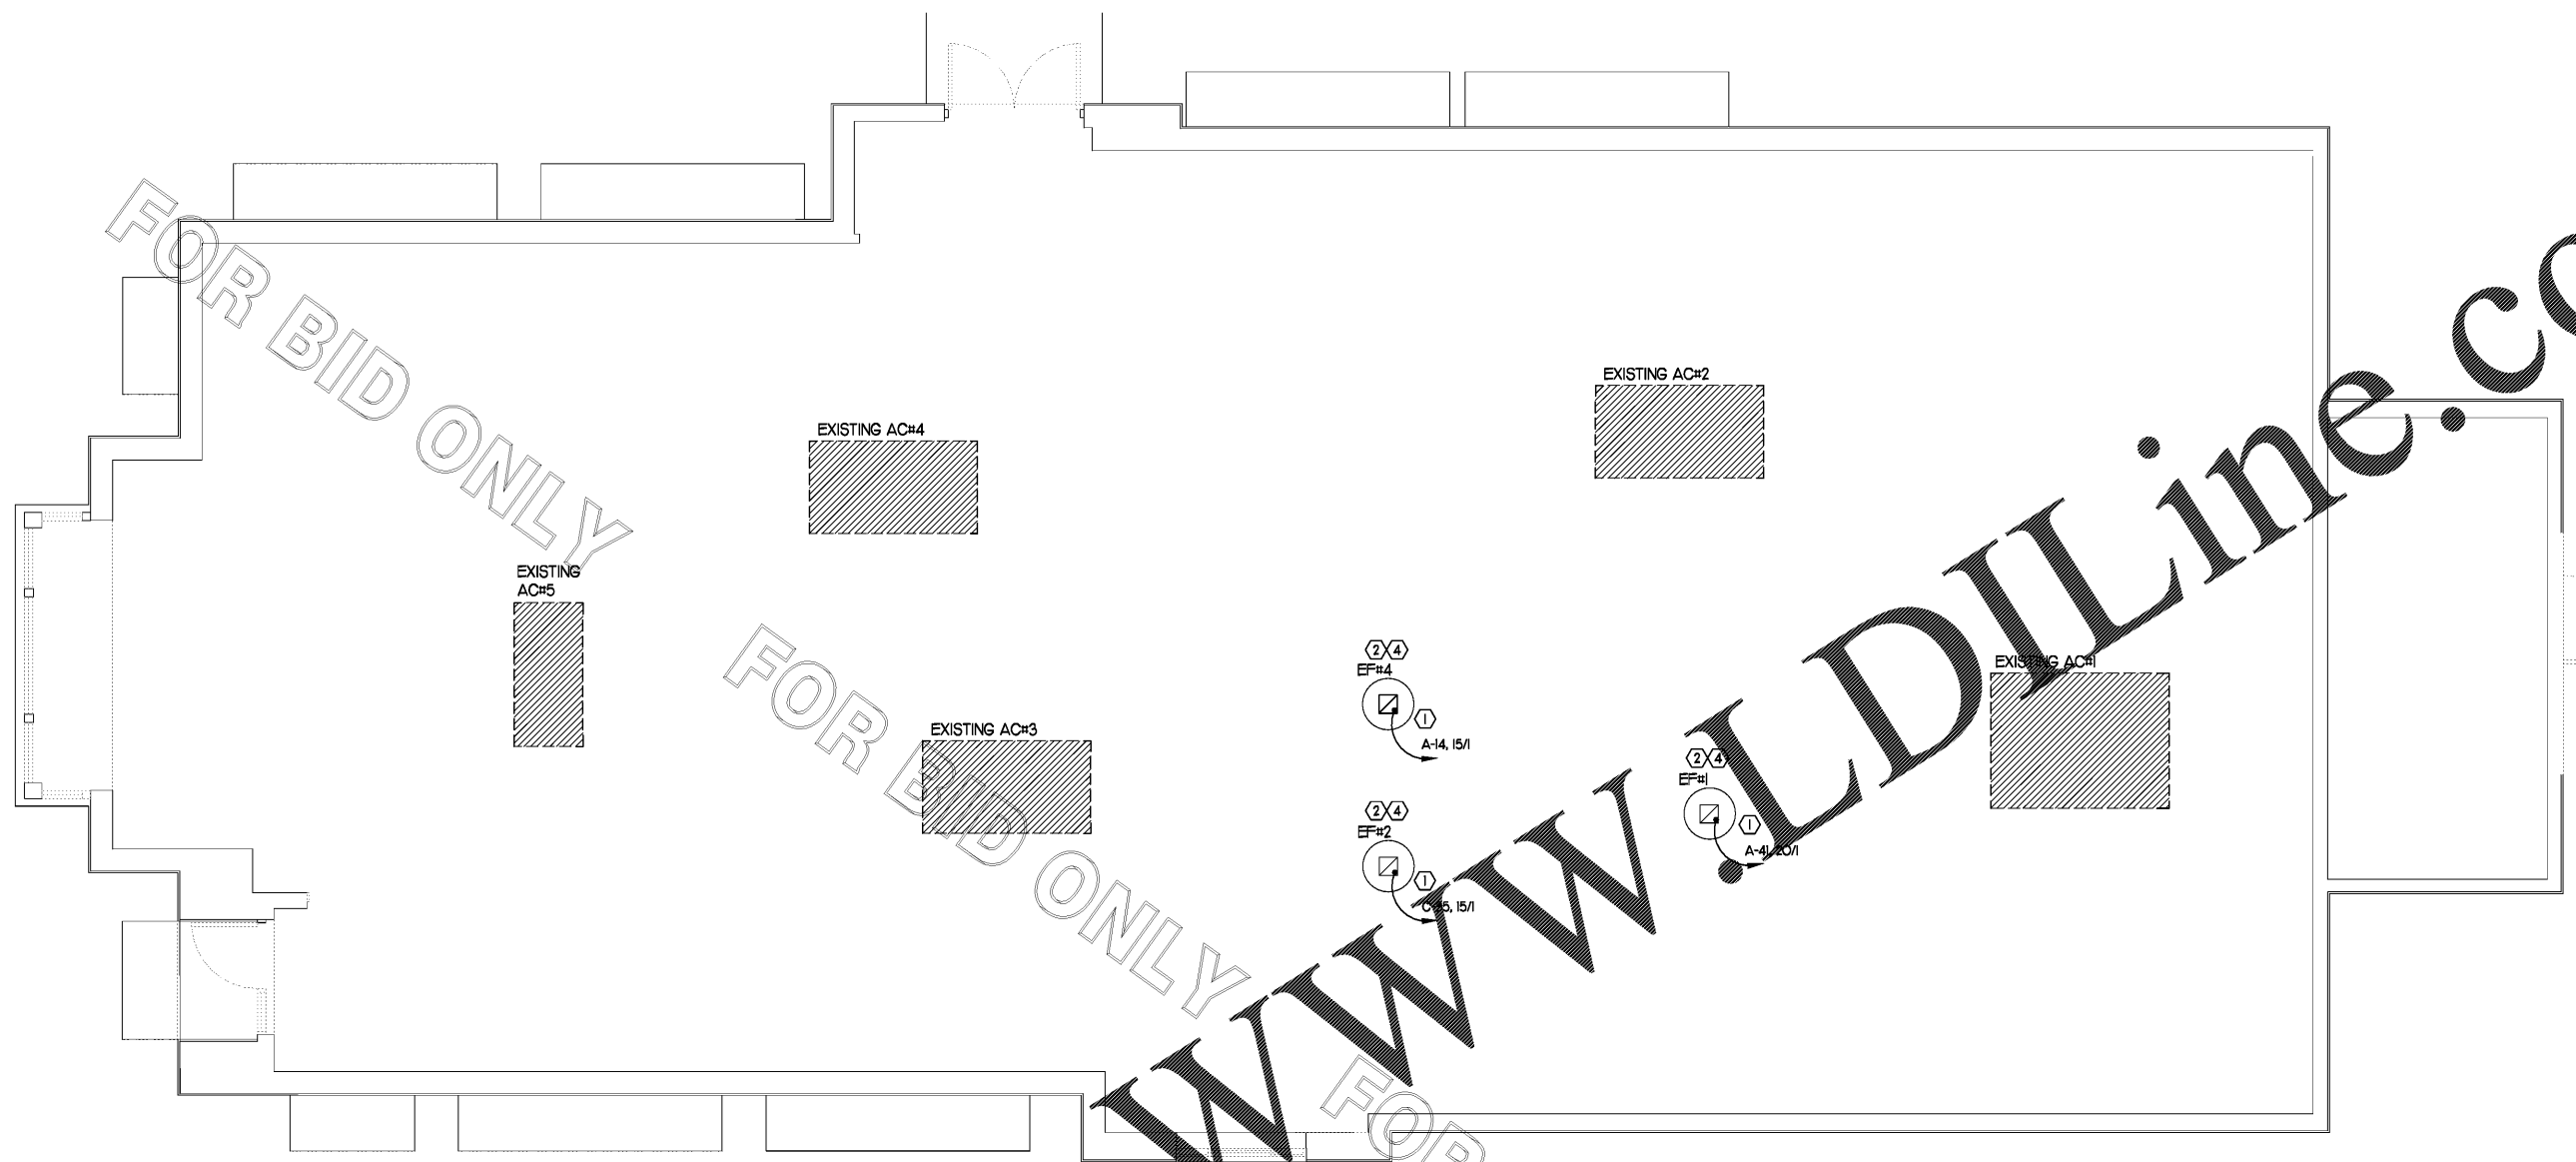


1 PARTIAL ROOFTOP POWER PLAN

SCALE: 1/4" = 1'-0"

FIELD VERIFY ALL LOCATIONS

3 KEYNOTES (APPLY TO THIS SHEET ONLY)

- CONNECT EF#1, EF#4, AND EF#2 THROUGH THE EXHAUST FAN CONTACTOR IN THE CFA-500 CONTROL PANEL. VERIFY EXISTING 4-POLE CONTACTOR. SEE CFA-500 CONTROL PANEL CONNECTION DIAGRAM THIS SHEET.
- COORDINATE EXACT LOCATION OF CONDUIT AND DISCONNECT AT EXHAUST FAN. CONDUIT SHALL BE INSTALLED THROUGH ROOF ON OUTSIDE OF FAN CURB. CONDUIT SHALL BE LOCATED AT FAN HINGE SUCH THAT THE FAN HOOD CAN BE FULLY HINGED OPEN AND NOT TOUCH THE CONDUIT. PROVIDE METAL VOLTAGE LOOP IN THE FLEXIBLE CONDUIT BETWEEN THE ROOF AND THE FAN ELECTRICAL CONNECTION.
- A/C UNIT DISCONNECT MUST BE PROVIDED WITH A/C UNIT AND SHALL BE CONNECTED BY THE CONTRACTOR.
- EXHAUST FAN DISCONNECT IS FURNISHED WITH THE FAN AND SHALL BE CONNECTED BY THE CONTRACTOR.
- 60 AMP, 3P NON-FUSED DISCONNECT MUST BE FURNISHED AND INSTALLED BY THE ELECTRICAL CONTRACTOR. MOUNT TOP RIGHT SIDE OF CABINET, ADJACENT TO EXHAUST-SIDE GRILLE.
- CONVENIENCE OUTLET SUPPLIED WITH UNIT. PROVIDE POWER THROUGH EXISTING ROOFTOP RECEPTACLE CIRCUIT. VERIFY CIRCUIT NUMBER.
- REPLACEMENT ACH HAS A UNIT-POWERED CONVENIENCE OUTLET.
- NON-FUSED DISCONNECT MUST BE FURNISHED AND INSTALLED BY THE ELECTRICAL CONTRACTOR.
- PROVIDE SEALTIGHT TO THE THRU THE CURB CONNECTORS LOCATION FOR LOW VOLTAGE AND POWER CONNECTIONS.

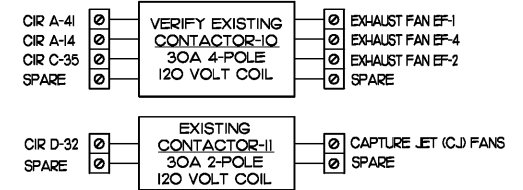

4 CFA-T500 CONTROL PANEL CONNECTION DIAGRAM

NOT TO SCALE

NOTES:
 (1) EXISTING CONDITIONS SHOWN ON THESE DRAWINGS ARE TO BE USED ONLY AS A GUIDE BY ELECTRICAL CONTRACTOR. ELECTRICAL CONTRACTOR SHALL FIELD VERIFY CONDITIONS PRIOR TO BID.
 (2) WIRING IN EXISTING CFA-500 PANEL TO REMAIN UNLESS NOTED ABOVE.
 (3) ONLY THE "HOT" CONDUCTOR OF EACH CIRCUIT SHALL BE RUN THRU THE CONTACTOR.
 (4) ANY TAPS OR WIRING CONNECTIONS OTHER THAN TO THE TERMINALS SHALL BE DONE IN A JUNCTION BOX OUTSIDE OF THIS CABINET.

THE INFORMATION USED TO DEVELOP THESE EXISTING CONDITIONS AS SHOWN ON THESE PLANS IS FROM PREVIOUS BUILDING DRAWINGS. WHAT WAS SHOWN ON PLAN AND WHAT WAS ACTUALLY INSTALLED MAY VARY. FIELD VERIFY ALL EXISTING CONDITIONS.

FOR BID ONLY

FOR BID ONLY

WWW.LDILine.com

Overseas Plans

FOR BID ONLY