


three inches = one foot
 one and one-half inches = one foot
 one inch = one foot
 three-quarters inch = one foot
 one-half inch = one foot
 three-eighths inch = one foot
 one-quarter inch = one foot
 one-eighth inch = one foot

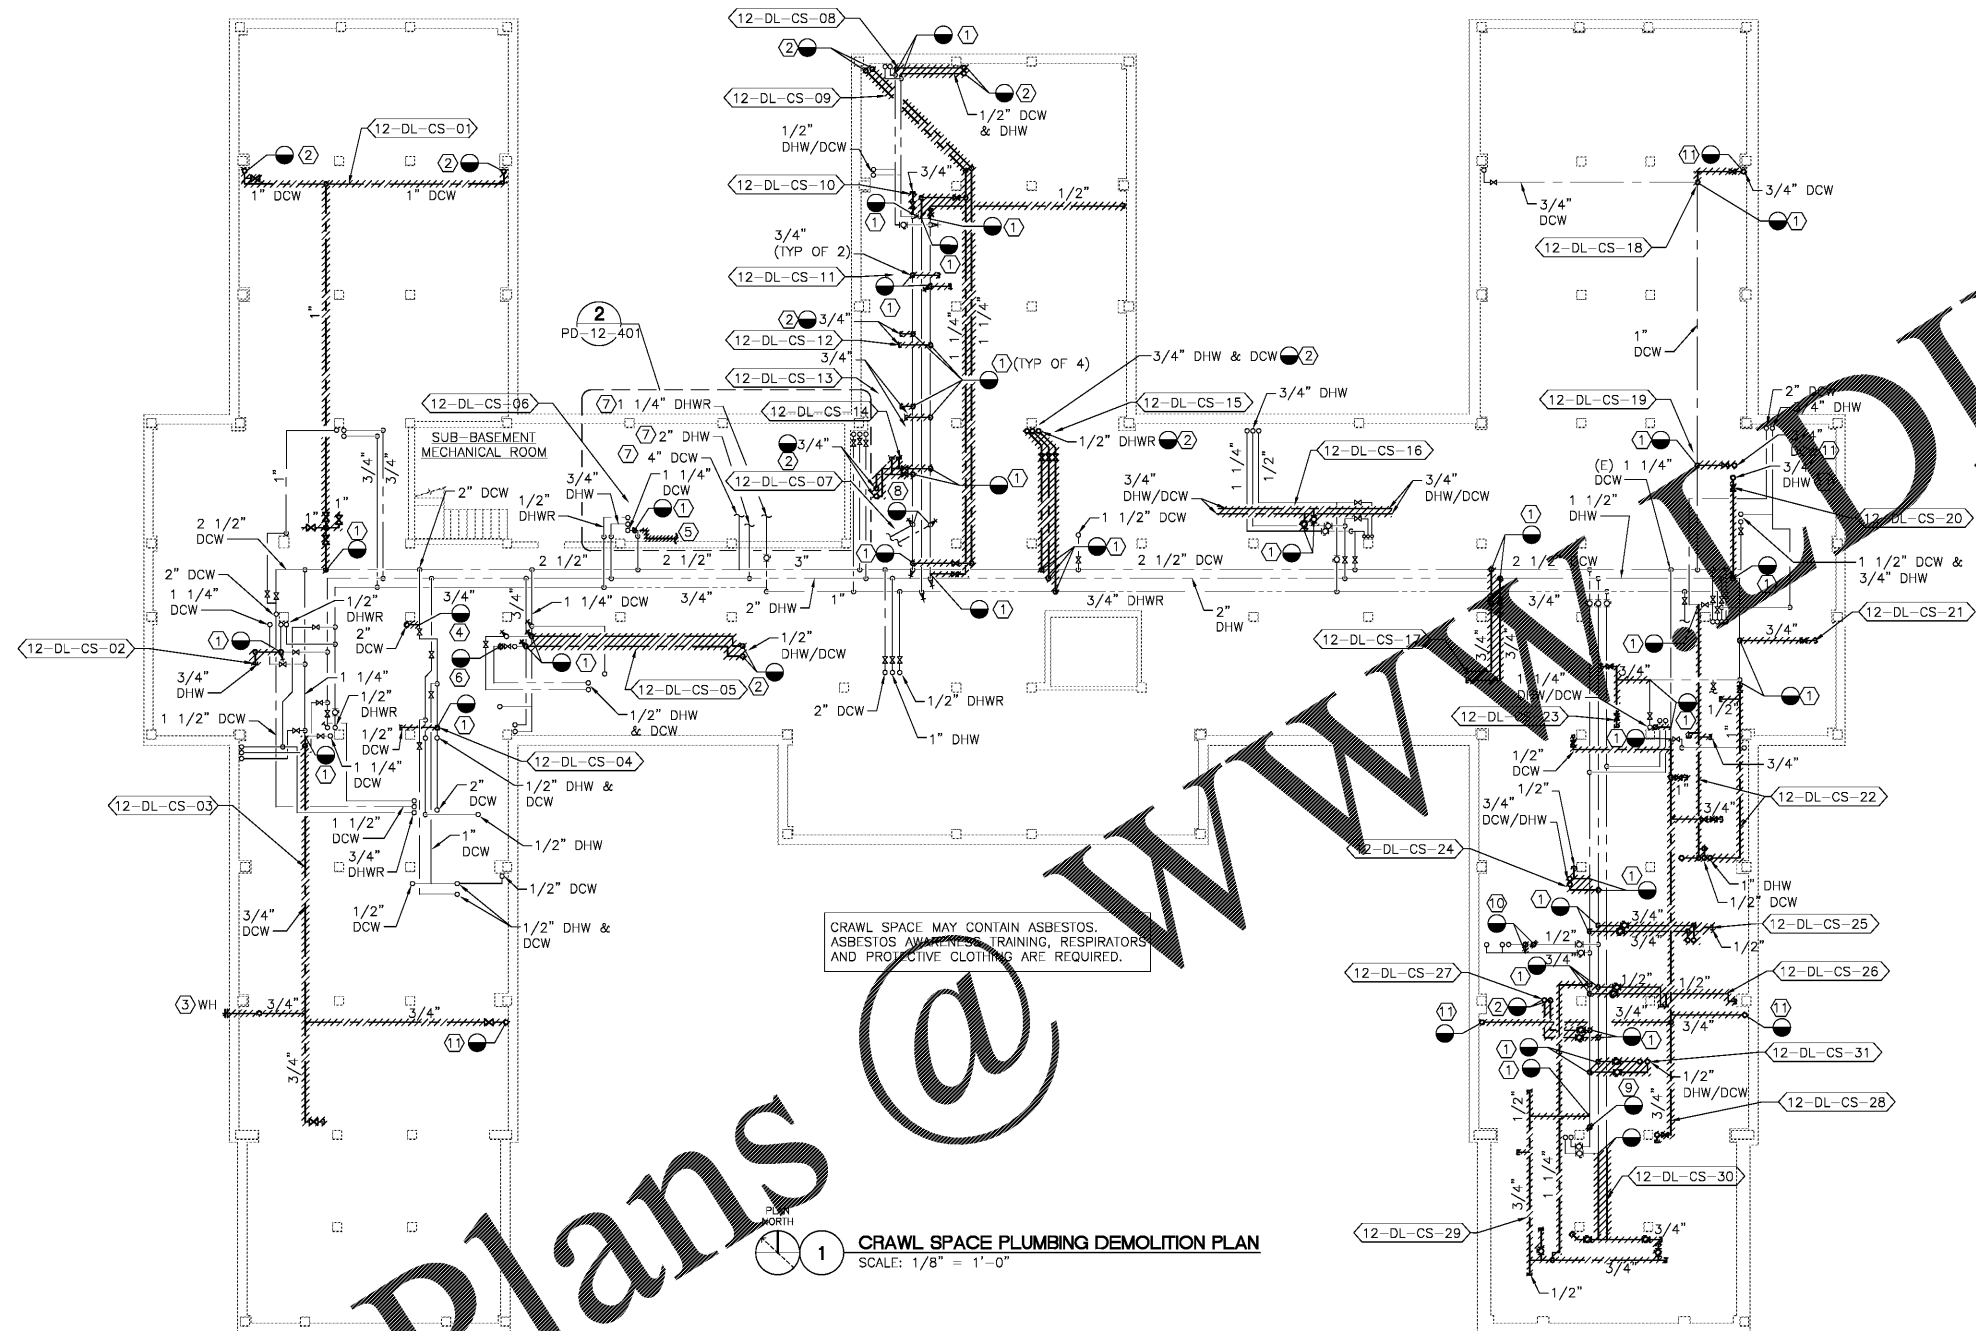

- DEMOLITION NOTES:**
- REMOVE DEADLEG BACK TO MAIN. REMOVE TEE FROM MAIN AND PROVIDE NEW PIPING AND FIBERGLASS INSULATION.
 - CUT AND CAP PIPE AT FLOOR SLAB.
 - PATCH MASONRY WALL TO MATCH EXISTING UPON REMOVAL OF WALL HYDRANT.
 - CUT AND CAP FIRE RISER PIPE AT FLOOR SLAB. REMOVE PIPING BACK TO MAIN AS SHOWN. FIRE RISER PIPE SHALL BE ABANDONED IN PLACE.
 - REMOVE 1/2" DCW SERVICE ABANDONED VACUUM PUMP SYSTEM.
 - CUT AND CAP PIPE AT FLOOR SLAB. REMOVE 3/4" DHW DEADLEG BACK TO MAIN. REMOVE THE TEE FROM MAIN AND PROVIDE NEW PIPING AND FIBERGLASS INSULATION. FIELD VERIFY WHICH DCW & DHW PIPES SERVE SHOWER IN TOILET 3B ON BASEMENT FLOOR.
 - SEE DRAWING PD-12-401 FOR CONTINUATION.
 - REMOVE 1/2" DHW DEADLEGS IN VERTICAL BACK TO MAIN. REMOVE TEE FROM MAIN AND PROVIDE NEW PIPING AND FIBERGLASS INSULATION.
 - CUT AND CAP PIPE AT FLOOR SLAB. REMOVE DEADLEG BACK TO MAIN. REMOVE TEE FROM MAIN AND PROVIDE NEW PIPING AND FIBERGLASS INSULATION.
 - REMOVE 1/2" DCW AND DHW DEADLEGS BACK TO MAIN. REMOVE THE TEE FROM MAIN AND PROVIDE NEW PIPING AND FIBERGLASS INSULATION. FIELD VERIFY WHICH DCW & DHW PIPES SERVE LAVATORY IN TOILET 14L ON BASEMENT FLOOR.
 - FIRESTOP OPENING IN SLAB UPON REMOVAL OF PIPE.

CRAWL SPACE MAY CONTAIN ASBESTOS. ASBESTOS AWARENESS TRAINING, RESPIRATORS AND PROTECTIVE CLOTHING ARE REQUIRED.

1 CRAWL SPACE PLUMBING DEMOLITION PLAN
 SCALE: 1/8" = 1'-0"

Order Plans @ WWW.WILEY-DILLING.COM

Revisions	Date

Atrix
 Atrix, plc
 102 3rd Avenue, NE
 PO Box 1628,
 Hickory, NC 28603
 Phone: 828.315.9962
 Fax: 828.315.9964
 www.atrigrp.com

WileyWilson
 WileyWilson
 127 Nationwide Drive
 Lynchburg, VA 24502
 Phone: 828.315.9964
 www.wileywilson.com



Approved: Energy Engineer	Approved: Safety Manager	Approved: Service Chief
	Approved: Infection Control Officer	Approved: Chief of Staff
	Approved: GEMS Coordinator	Approved: Associate Director

CONSTRUCTION DOCUMENTS

Approved: Chief of Facility Management Svc.	Approved: Medical Center Director
---	-----------------------------------

Drawing Title PD-12-101 BLDG 12 CRAWL SPACE PLUMBING PLAN DEMOLITION	Project Title RENOVATE FOR WATER QUALITY	Date 04/28/2017
Approved: Chief of Facility Management Svc.	Building Number 12	Project No. 688-15-101
Approved: Medical Center Director	Checked MJG	Drawing Set 2592
Location VA MEDICAL CENTER, SALEM, VA 24153	Drawn JPH	Dwg. 4 Of 155

Veterans Affairs