



three inches = one foot
 one and one-half inches = one foot
 one inch = one foot
 three-quarters inch = one foot
 one-half inch = one foot
 three-eighths inch = one foot
 one-quarter inch = one foot
 one-eighth inch = one foot

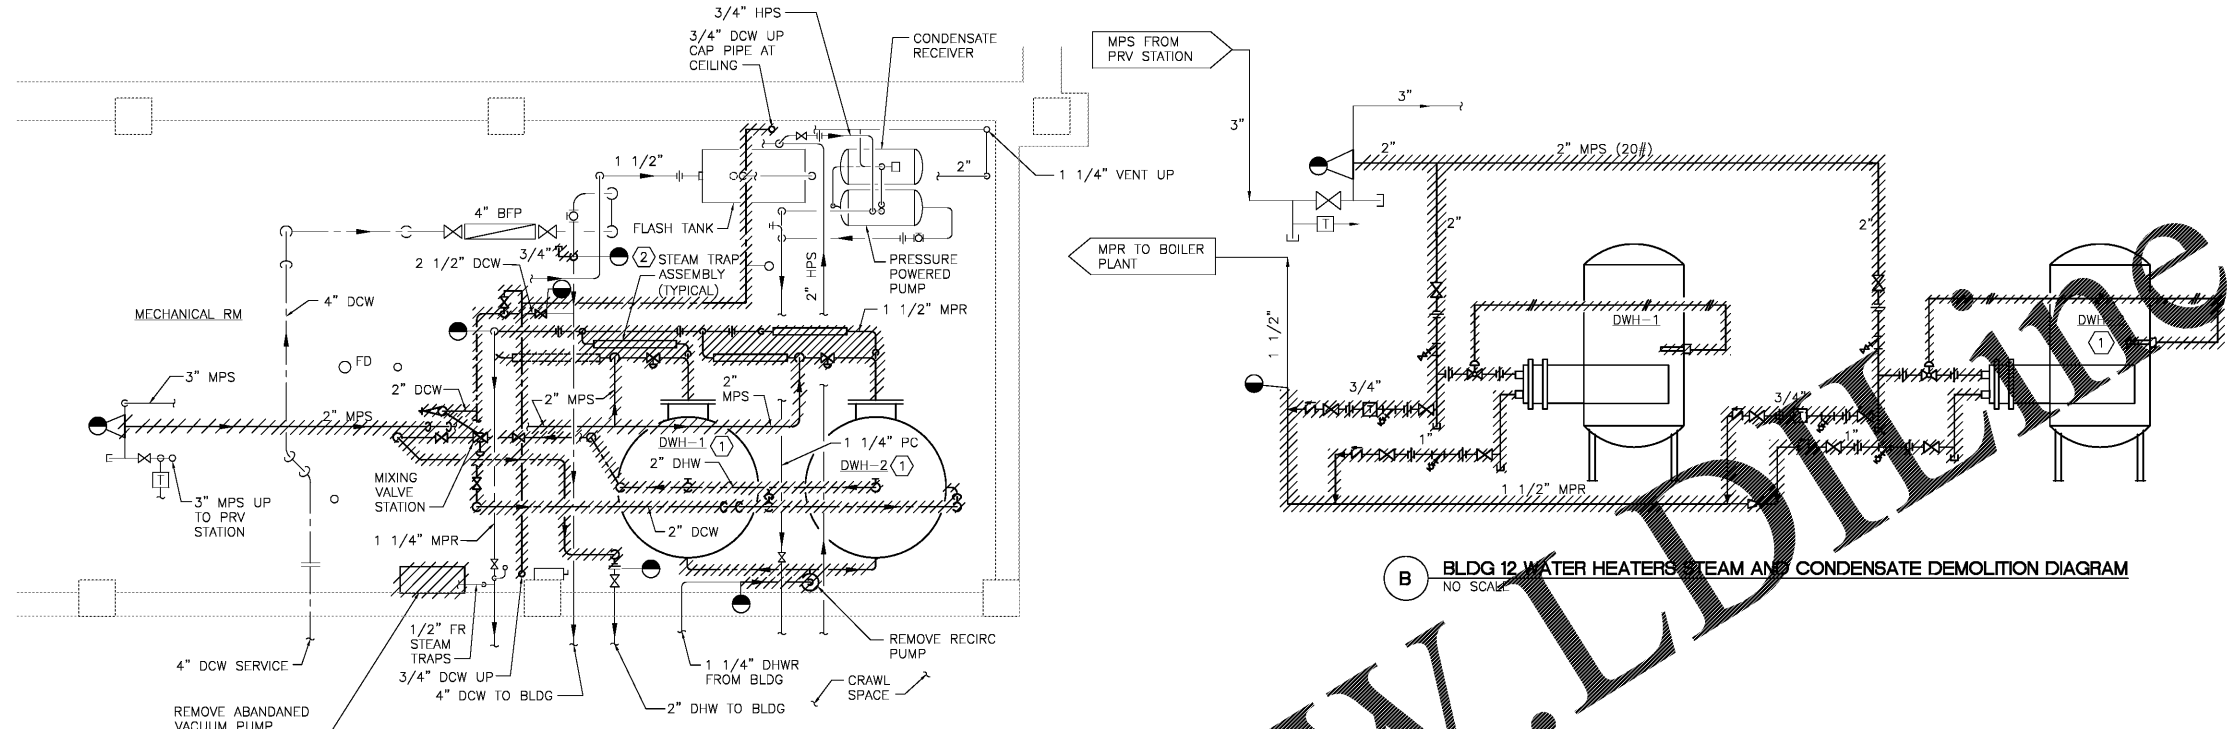

1 ENLARGED SUB-BASEMENT PLUMBING DEMOLITION PLAN
 SCALE: 1/2" = 1'-0"

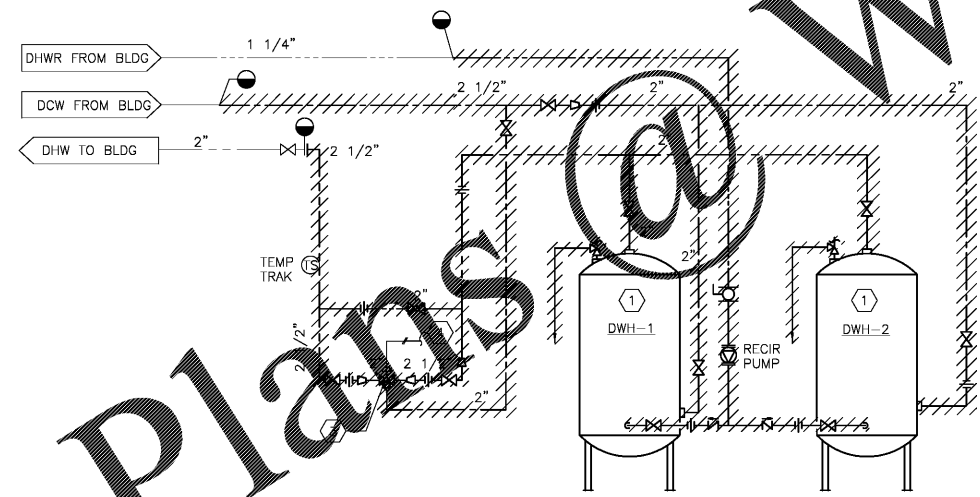

A BLDG 12 WATER HEATERS DOMESTIC WATER DEMOLITION DIAGRAM
 NO SCALE

B BLDG 12 WATER HEATERS STEAM AND CONDENSATE DEMOLITION DIAGRAM
 NO SCALE

- GENERAL NOTES:**
- 1. REMOVE ONE DOMESTIC WATER HEATER AND INSTALL NEW WATER HEATER PRIOR TO REMOVING SECOND WATER HEATER.
- DEMOLITION NOTES:**
- ① REMOVE VERTICAL STORAGE STEAM FIRED DOMESTIC WATER HEATER AND ASSOCIATED PIPING, VALVING AND ACCESSORIES.
 - ② REMOVE APPROX. 24" TALL VERTICAL ABANDONED PIPING 1 1/4" AND LESS. REMOVE 4" TEE FROM 4" DCW MAIN AND PROVIDE NEW PIPING AND FIBERGLASS INSULATION.
 - ③ REMOVE 3-WAY PNEUMATIC MIXING VALVE CONTROLS INCLUDING TEMPERATURE SENSOR, CONTROLLER, CONDUIT, WIRING AND TUBING.
 - ④ REMOVE PNEUMATIC TUBING BACK TO SOURCE AND CAP.

Order Plans @ www.LDPlans.com

Revisions	Date

Atrix
 Atrix, pllc
 102 3rd Avenue, NE
 PO Box 1628,
 Hickory, NC 28603
 Phone: 828.315.9962
 Fax: 828.315.9964
 www.atrifaxgroup.com

WileyWilson
 WileyWilson
 127 Nantuxie Drive
 Lynchburg, VA 24502
 Phone: 434.947.1901
 www.wileywilson.com



Approved: Energy Engineer	Approved: Safety Manager	Approved: Service Chief	Drawing Title	Project Title	Date
CONSTRUCTION DOCUMENTS	Approved: Infection Control Officer	Approved: Chief of Staff	PD-12-401 BLDG 12 ENLARGED SUB-BASEMENT PLUMBING PLAN DEMOLITION	RENOVATE FOR WATER QUALITY	04/28/2017
	Approved: GEMS Coordinator	Approved: Associate Director	Approved: Chief of Facility Management Svc.	Building Number 12	Project No. 658-15-101
	Approved: Medical Center Director		Checked MJG	Drawn JFC	DRAWING SET 2592
			Approved: Medical Center Director	Location VA MEDICAL CENTER, SALEM, VA 24153	Dwg. 48 Of 155

Veterans Affairs