



DEMOLITION NOTES:

- ① REMOVE DEADLEG BACK TO MAIN. REMOVE TEE FROM MAIN AND PROVIDE NEW PIPING AND FIBERGLASS INSULATION.

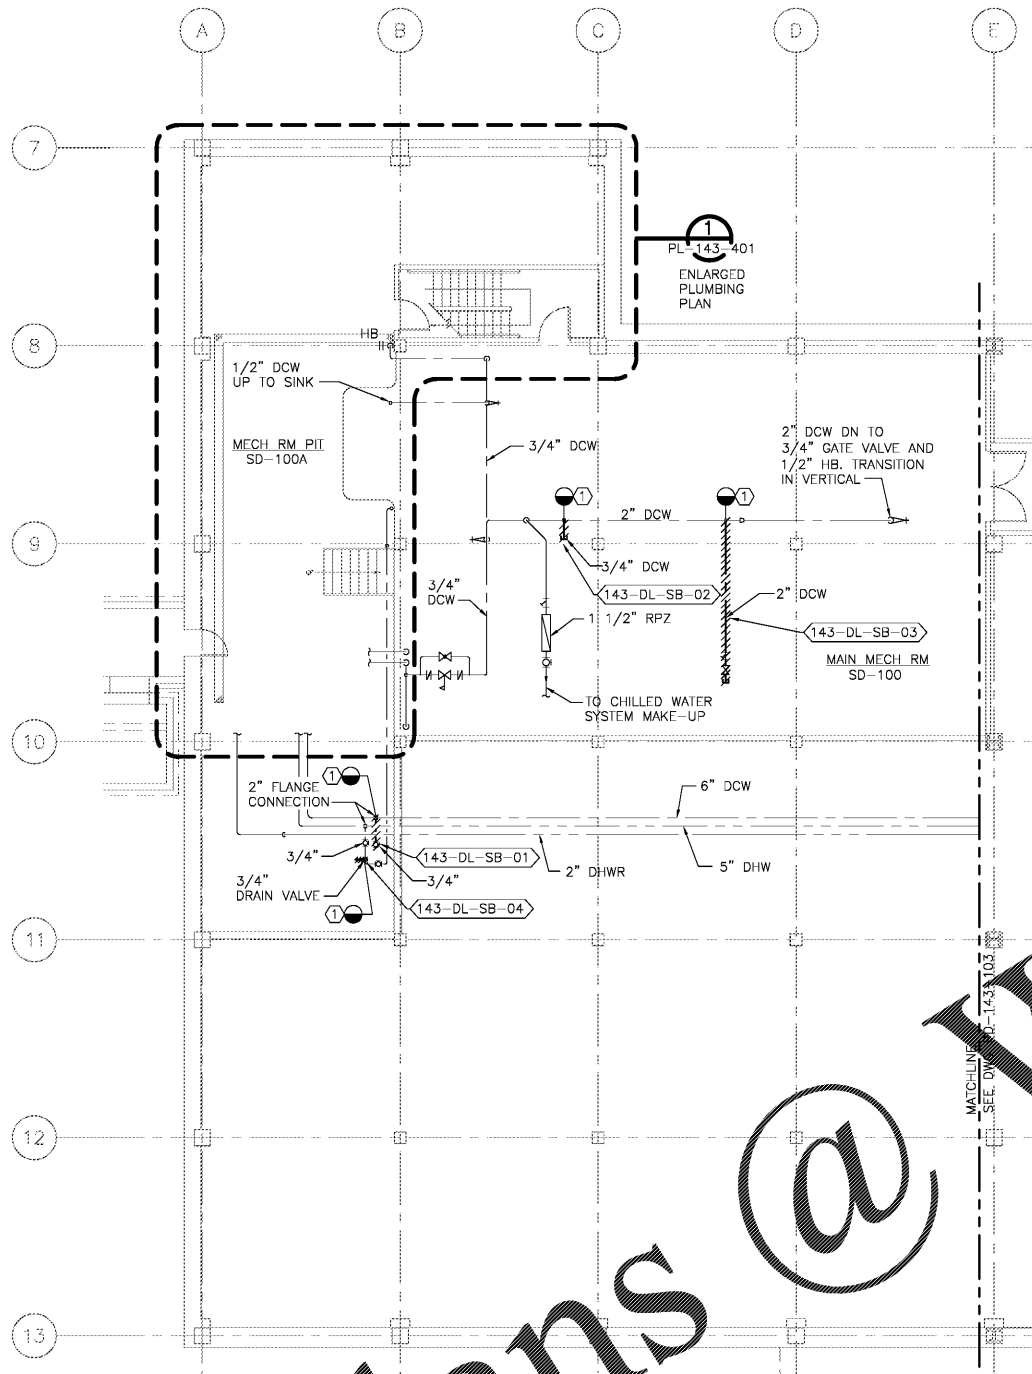

PLAN NORTH
SUB-BASEMENT PLUMBING DEMOLITION PLAN - AREA 'A'
SCALE: 1/8" = 1'-0"

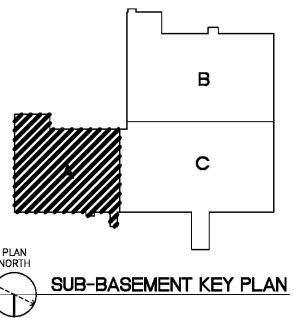

Revisions Date	Atrix Atrix, p.l.l.c. 102 3rd Avenue, NE PO Box 1628, Hickory, NC 28603 Phone: 828.315.9962 Fax: 828.315.9964 www.atrinxgroup.com	Wiley/Wilson Wiley/Wilson 127 Nantowite Drive Lyndburg, VA 24502 Phone: 434.947.1901 www.wileywilson.com	Professional Engineer Lic. No. 24289 4/22/2017	Approved: Energy Engineer	Approved: Safety Manager	Approved: Service Chief	Drawing Title PD-143-101 BLDG 143 SUB-BASEMENT PLUMBING PLAN AREA 'A' DEMOLITION	Project Title RENOVATE FOR WATER QUALITY	Date 04/28/2017	Veterans Affairs
				CONSTRUCTION DOCUMENTS	Approved: Infection Control Officer	Approved: Chief of Staff	Approved: Chief of Facility Management Svc.	Building Number 143	Checked MJG	
			Approved: GEMS Coordinator	Approved: Associate Director	Approved: Medical Center Director	Location VA MEDICAL CENTER, SALEM, VA 24153	Dwg. 83 Of 155			