
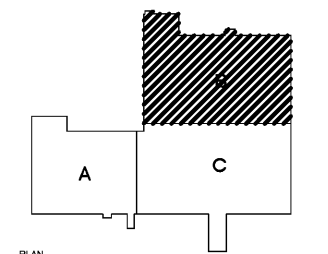


Order Plans @

WWW.LDILine.com

DEMOLITION NOTES:

- ① REMOVE DEADLEG BACK TO MAIN. REMOVE TEE FROM MAIN AND PROVIDE NEW PIPING AND FIBERGLASS INSULATION.

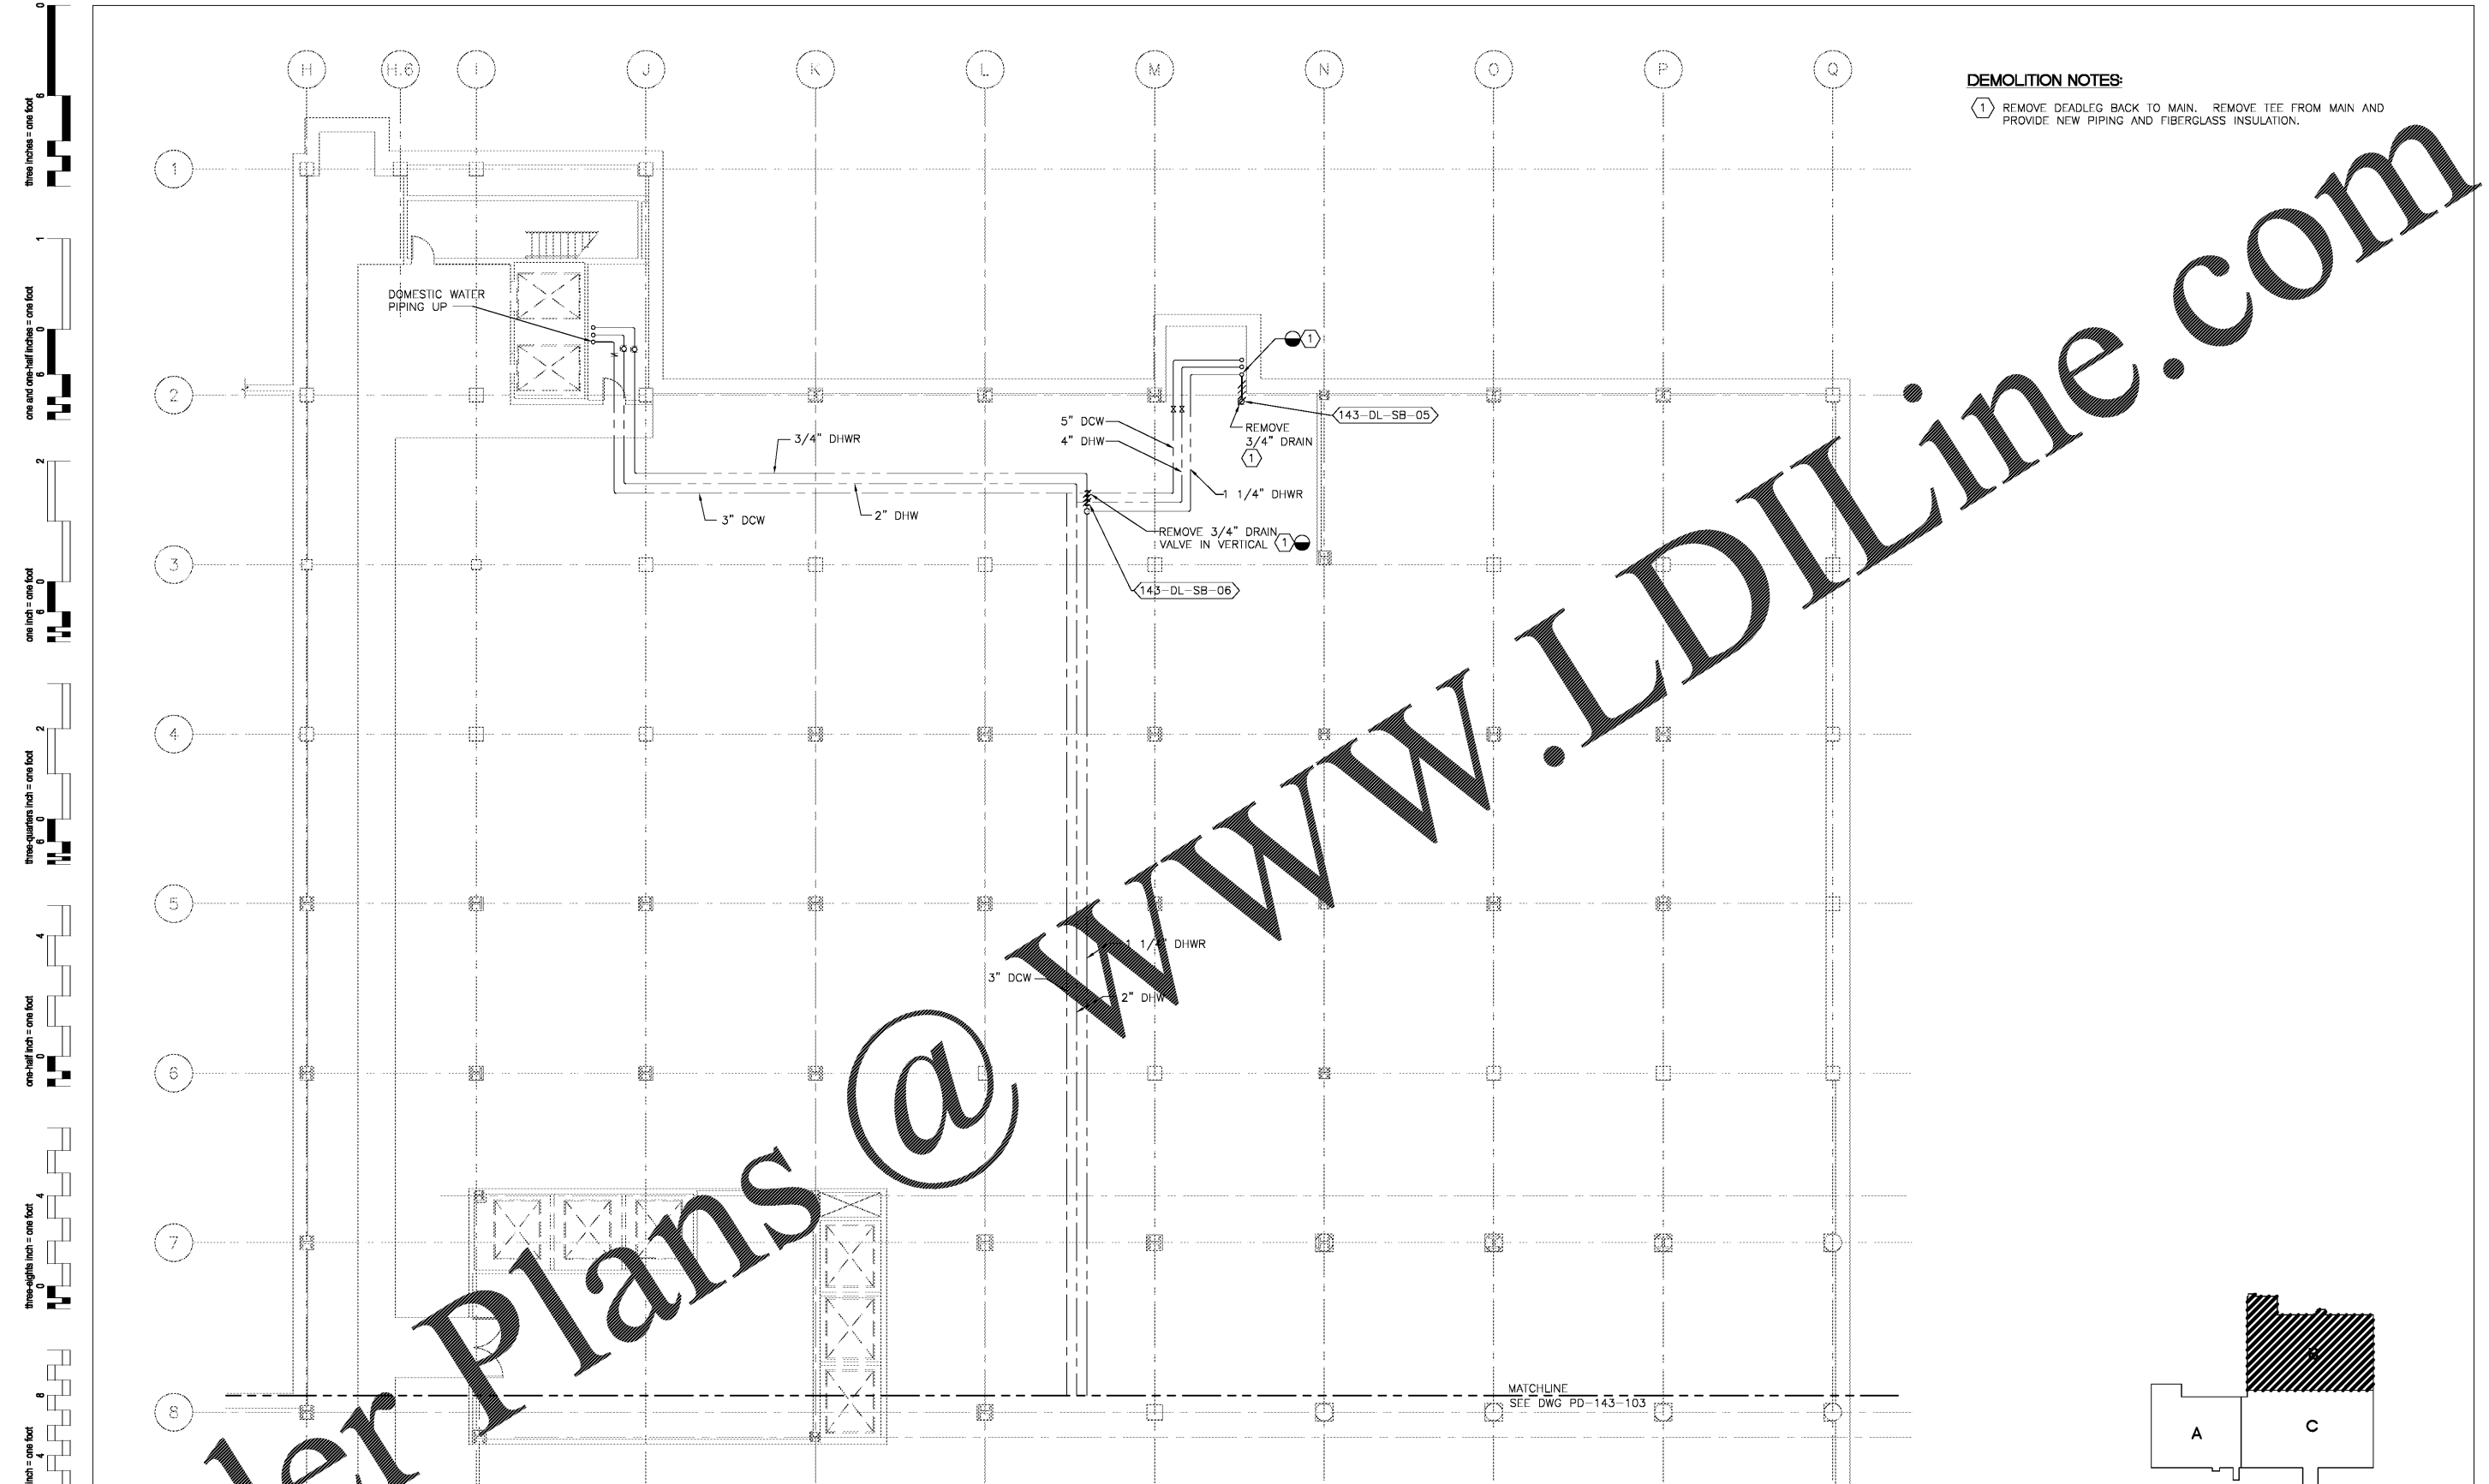


PLAN NORTH
1 SUB-BASEMENT PLUMBING DEMOLITION PLAN - AREA "B"
 SCALE: 1/8" = 1'-0"

PLAN NORTH
 SUB-BASEMENT KEY PLAN

Revisions	Date

Atriax
 Atriax, pllc
 102 3rd Avenue, NE
 PO Box 1628,
 Hickory, NC 28603
 Phone: 828.315.9962
 Fax: 828.315.9964
 www.atriaxgroup.com

WileyWilson
 WileyWilson
 127 Nationwide Drive
 Lynchburg, VA 24502
 Phone: 434.947.1901
 www.wileywilson.com

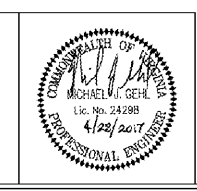

Approved: Energy Engineer
 Approved: Safety Manager
 Approved: Infection Control Officer
 Approved: GEMS Coordinator

CONSTRUCTION DOCUMENTS

Approved: Service Chief
 Approved: Chief of Staff
 Approved: Associate Director

Drawing Title
 PD-143-102
 BLDG 143 SUB-BASEMENT PLUMBING PLAN
 AREA "B" DEMOLITION

Approved: Chief of Facility Management Svc.
 Approved: Medical Center Director

Project Title
 RENOVATE FOR WATER QUALITY

Building Number
 143

Location
 VA MEDICAL CENTER, SALEM, VA 24153

Date
 04/28/2017

Project No.
 658-15-101

DRAWING SET
 2592

Dwg. 84 Of 155

Veterans Affairs