


**DEMOLITION NOTES:**


- 1 REMOVE DEADLEG BACK TO MAIN. REMOVE TEE FROM MAIN AND PROVIDE NEW PIPING AND FLEXIBLE ELASTOMERIC INSULATION.



1 BASEMENT PLUMBING DEMOLITION PLAN - AREA 'B'  
SCALE: 1/8" = 1'-0"

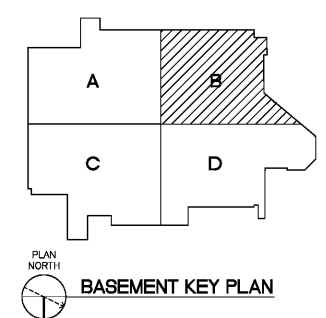

Order Plans @ WWW.LDILine.com

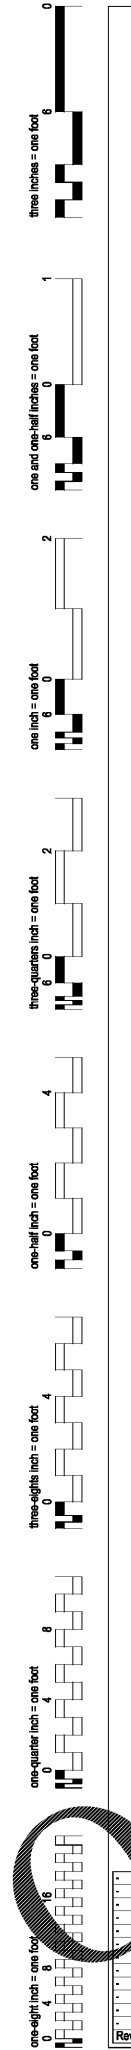

Revisions Date	<b>Atrix</b> Atrix, plc 102 3rd Avenue, NE PO Box 1628, Hickory, NC 28603 Phone: 828.315.9962 Fax: 828.315.9964 www.atrigrp.com	<b>WileyWilson</b> WileyWilson 127 Natterville Drive Lynchburg, VA 24502 Phone: 434.947.1901 www.wileywilson.com		Approved: Energy Engineer	Approved: Safety Manager	Approved: Service Chief	Drawing Title PD-143-105 BLDG 143 BASEMENT PLUMBING PLAN AREA 'B' DEMOLITION	Project Title RENOVATE FOR WATER QUALITY	Date 04/28/2017	Veterans Affairs
				CONSTRUCTION DOCUMENTS	Approved: Infection Control Officer	Approved: Chief of Staff	Approved: Chief of Facility Management Svc.	Building Number 143	Checked MJG	
				Approved: GEMS Coordinator	Approved: Associate Director	Approved: Medical Center Director	Location VA MEDICAL CENTER, SALEM, VA 24153			