
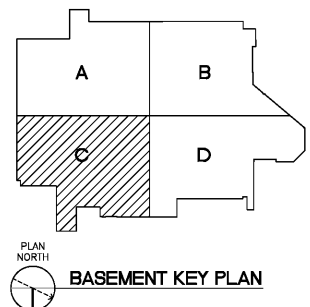


DEMOLITION NOTES:

- ① REMOVE DEADLEG BACK TO MAIN. REMOVE TEE FROM MAIN AND PROVIDE NEW PIPING AND FLEXIBLE ELASTOMERIC INSULATION.
- ② CONNECT 3/4" DHW TO 3/4" DHWR TO MAINTAIN HOT WATER RECIRCULATING.

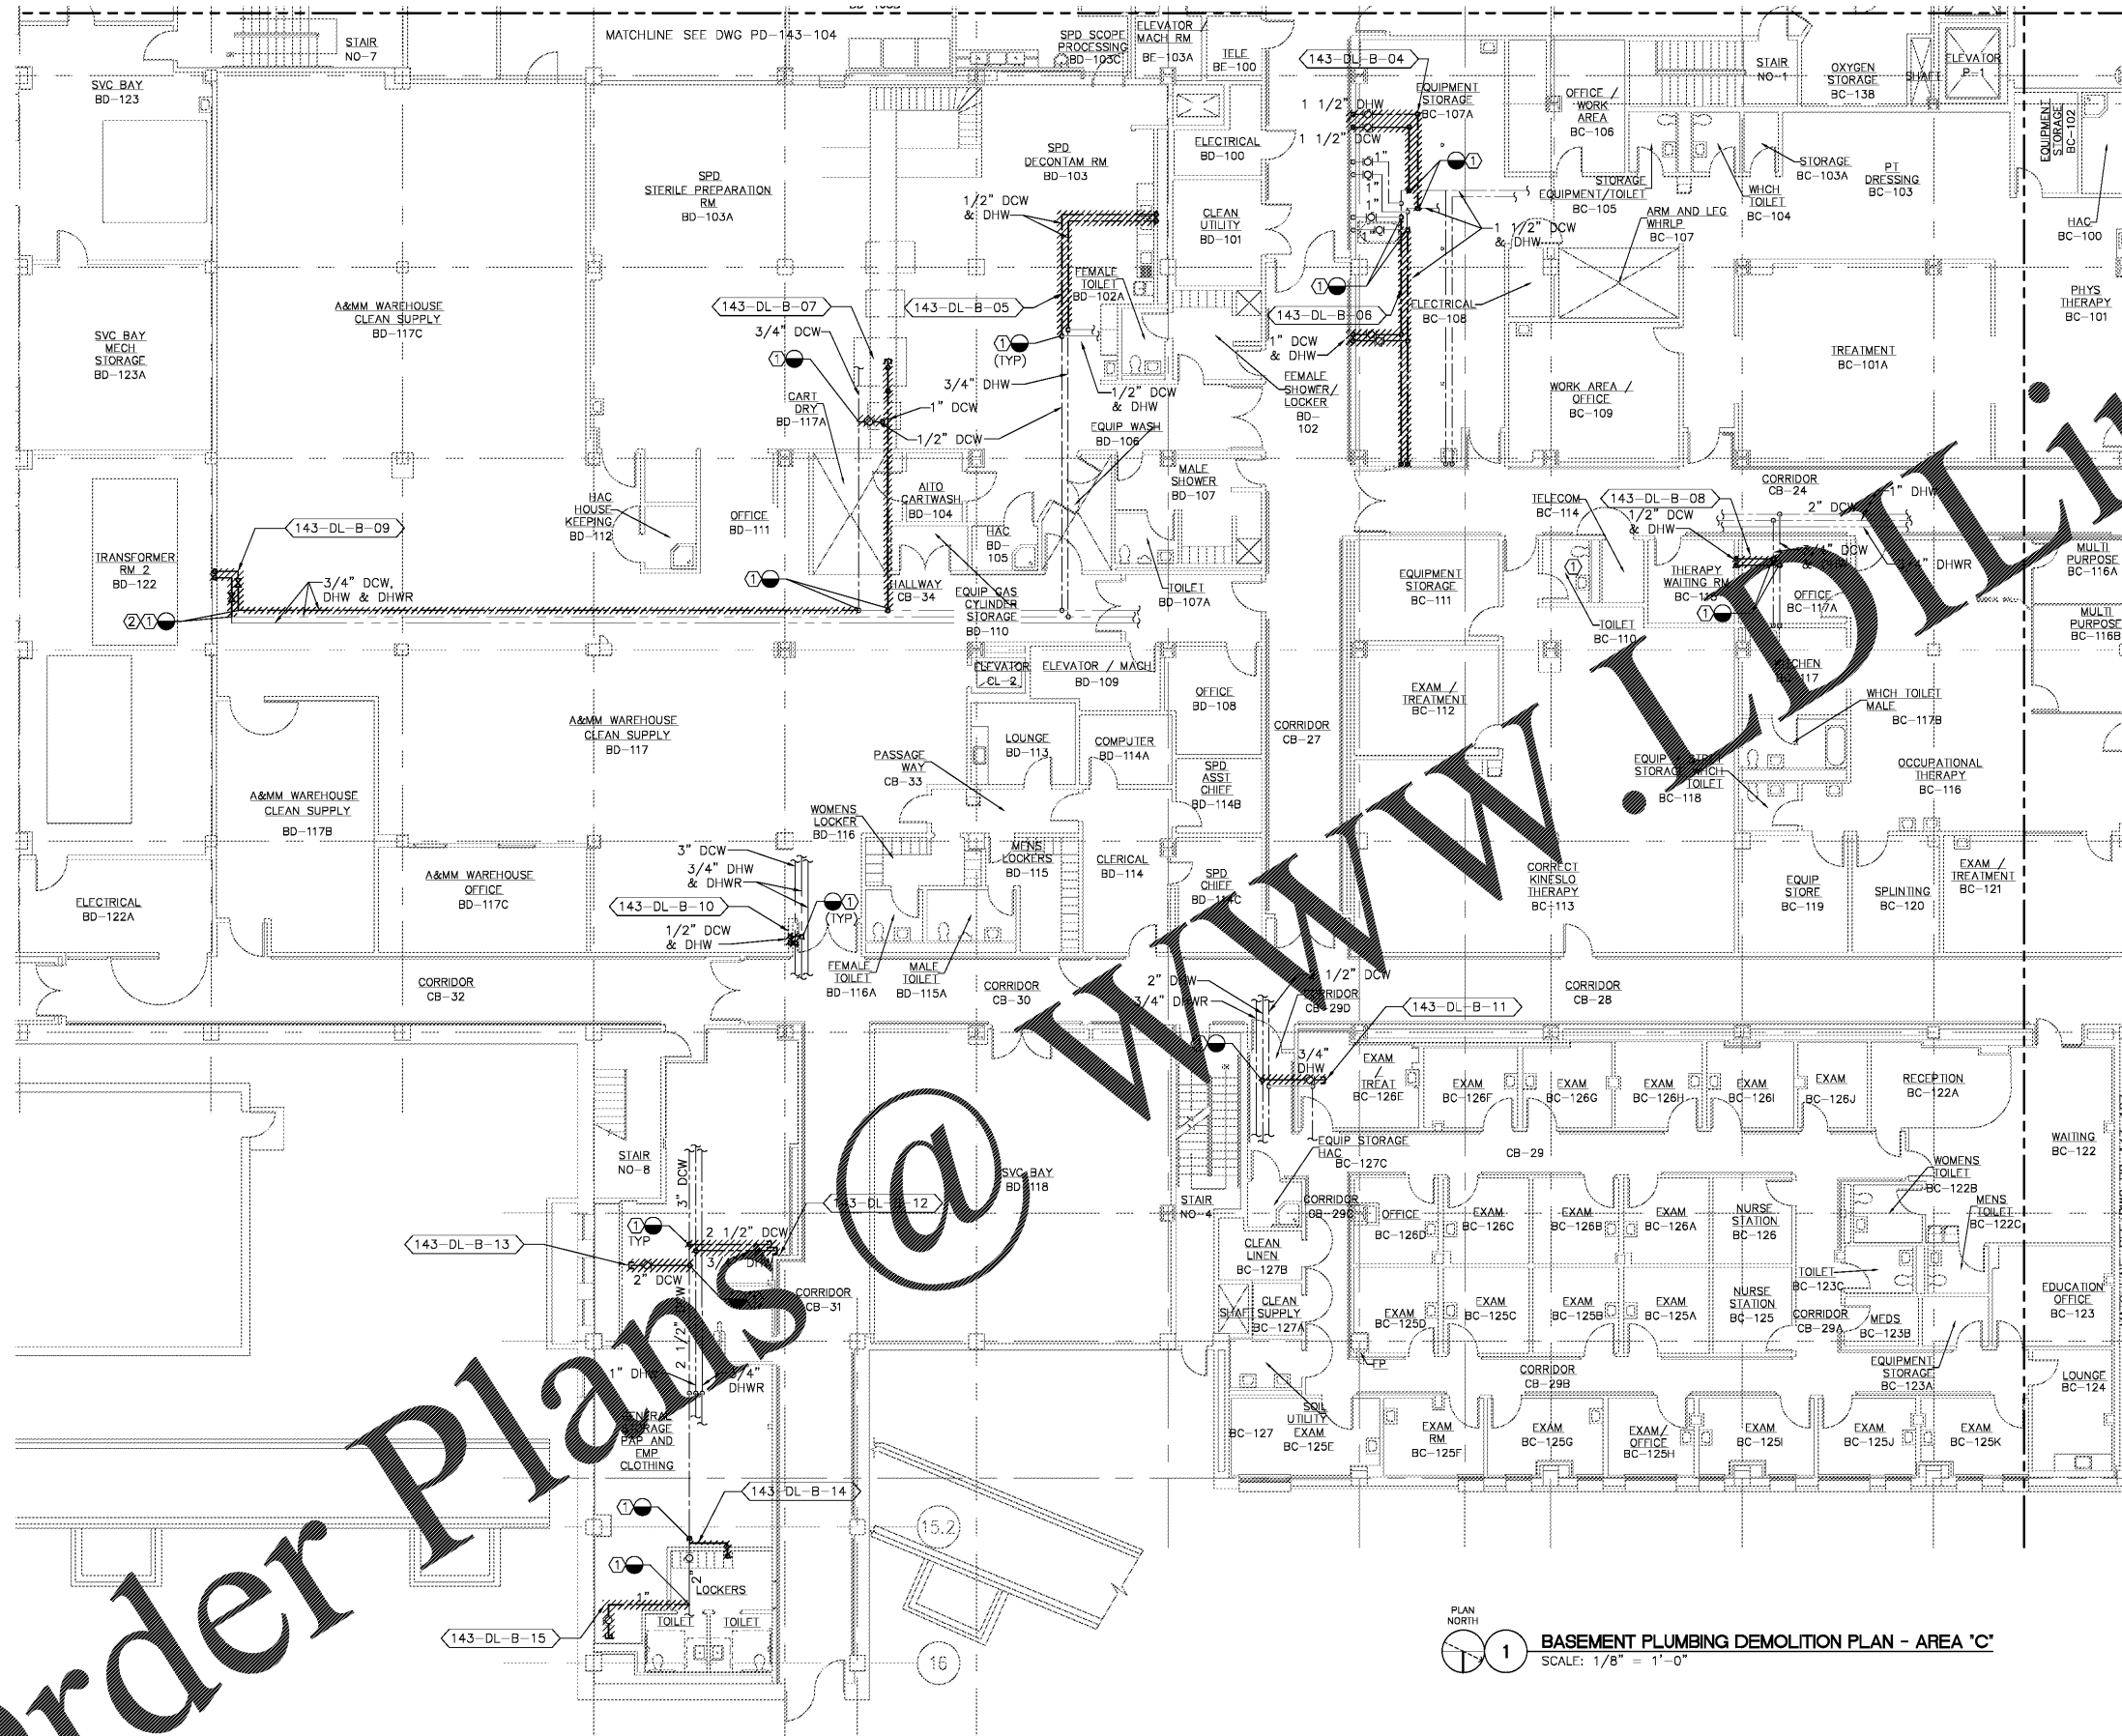

PLAN NORTH  
1  
BASEMENT PLUMBING DEMOLITION PLAN - AREA 'C'  
SCALE: 1/8" = 1'-0"

|                    |  |--------------------|--|---|----------------------------------|---------------------------------|--------------------------------|---|---|----------------------------|-----------------------------------|---|--------------------------------|------------------------|----------------------|-----------------------------|--|-----------------------|-------------------------|--|--|---|
| <p>Order Plans</p> | <p><b>Atriox</b><br/>Atriox, plc<br/>102 3rd Avenue, NE<br/>PO Box 1628,<br/>Hickory, NC 28603<br/>Phone: 828.315.9962<br/>Fax: 828.315.9964<br/>www.atrioxgroup.com</p> | <p><b>WileyWilson</b><br/>WileyWilson<br/>127 Natterville Drive<br/>Lynchburg, VA 24502<br/>Phone: 434.947.1901<br/>www.wileywilson.com</p> | <p>Approved: Energy Engineer</p> | <p>Approved: Safety Manager</p> | <p>Approved: Service Chief</p> | <p>Drawing Title<br/>PD-143-106<br/>BLDG 143 BASEMENT PLUMBING PLAN<br/>AREA 'C' DEMOLITION</p> | <p>Project Title<br/>RENOVATE FOR WATER QUALITY</p> | <p>Date<br/>04/28/2017</p> | <p>Project No.<br/>658-15-101</p> | <p>Approved: Chief of Facility Management Svcs.<br/>Approved: Medical Center Director</p> | <p>Building Number<br/>143</p> | <p>Checked<br/>MUG</p> | <p>Drawn<br/>JFC</p> | <p>DRAWING SET<br/>2592</p> | <p>Location<br/>VA MEDICAL CENTER, SALEM, VA 24153</p> | <p>Dwg. 58 Of 155</p> | <p>Veterans Affairs</p> |  |  |   |
|                    |  |   |                                  |                                 |                                |   |   |                            |                                   |   |                                |                        |                      |                             |  |                       |                         | <p>Approved: Infection Control Officer</p> | <p>Approved: Chief of Staff</p>          | <p>Approved: Chief of Facility Management Svcs.</p> |
|                    |  |   |                                  |                                 |                                |   |   |                            |                                   |   |                                |                        |                      |                             |  |                       |                         | <p>Approved: GEMS Coordinator</p>          | <p>Approved: Associate Director</p>      | <p>Approved: Chief of Facility Management Svcs.</p> |
|                    |  |   |                                  |                                 |                                |   |   |                            |                                   |   |                                |                        |                      |                             |  |                       |                         | <p>CONSTRUCTION DOCUMENTS</p>              | <p>Approved: Medical Center Director</p> | <p>Approved: Chief of Facility Management Svcs.</p> |
|                    |  |   |                                  |                                 |                                |   |   |                            |                                   |   |                                |                        |                      |                             |  |                       |                         | <p>Professional Engineer Seal</p>          | <p>Approved: Medical Center Director</p> | <p>Approved: Chief of Facility Management Svcs.</p> |