


three inches = one foot
 one and one-half inches = one foot
 one inch = one foot
 three-quarters inch = one foot
 one-half inch = one foot
 three-eighths inch = one foot
 one-quarter inch = one foot
 one-eighth inch = one foot

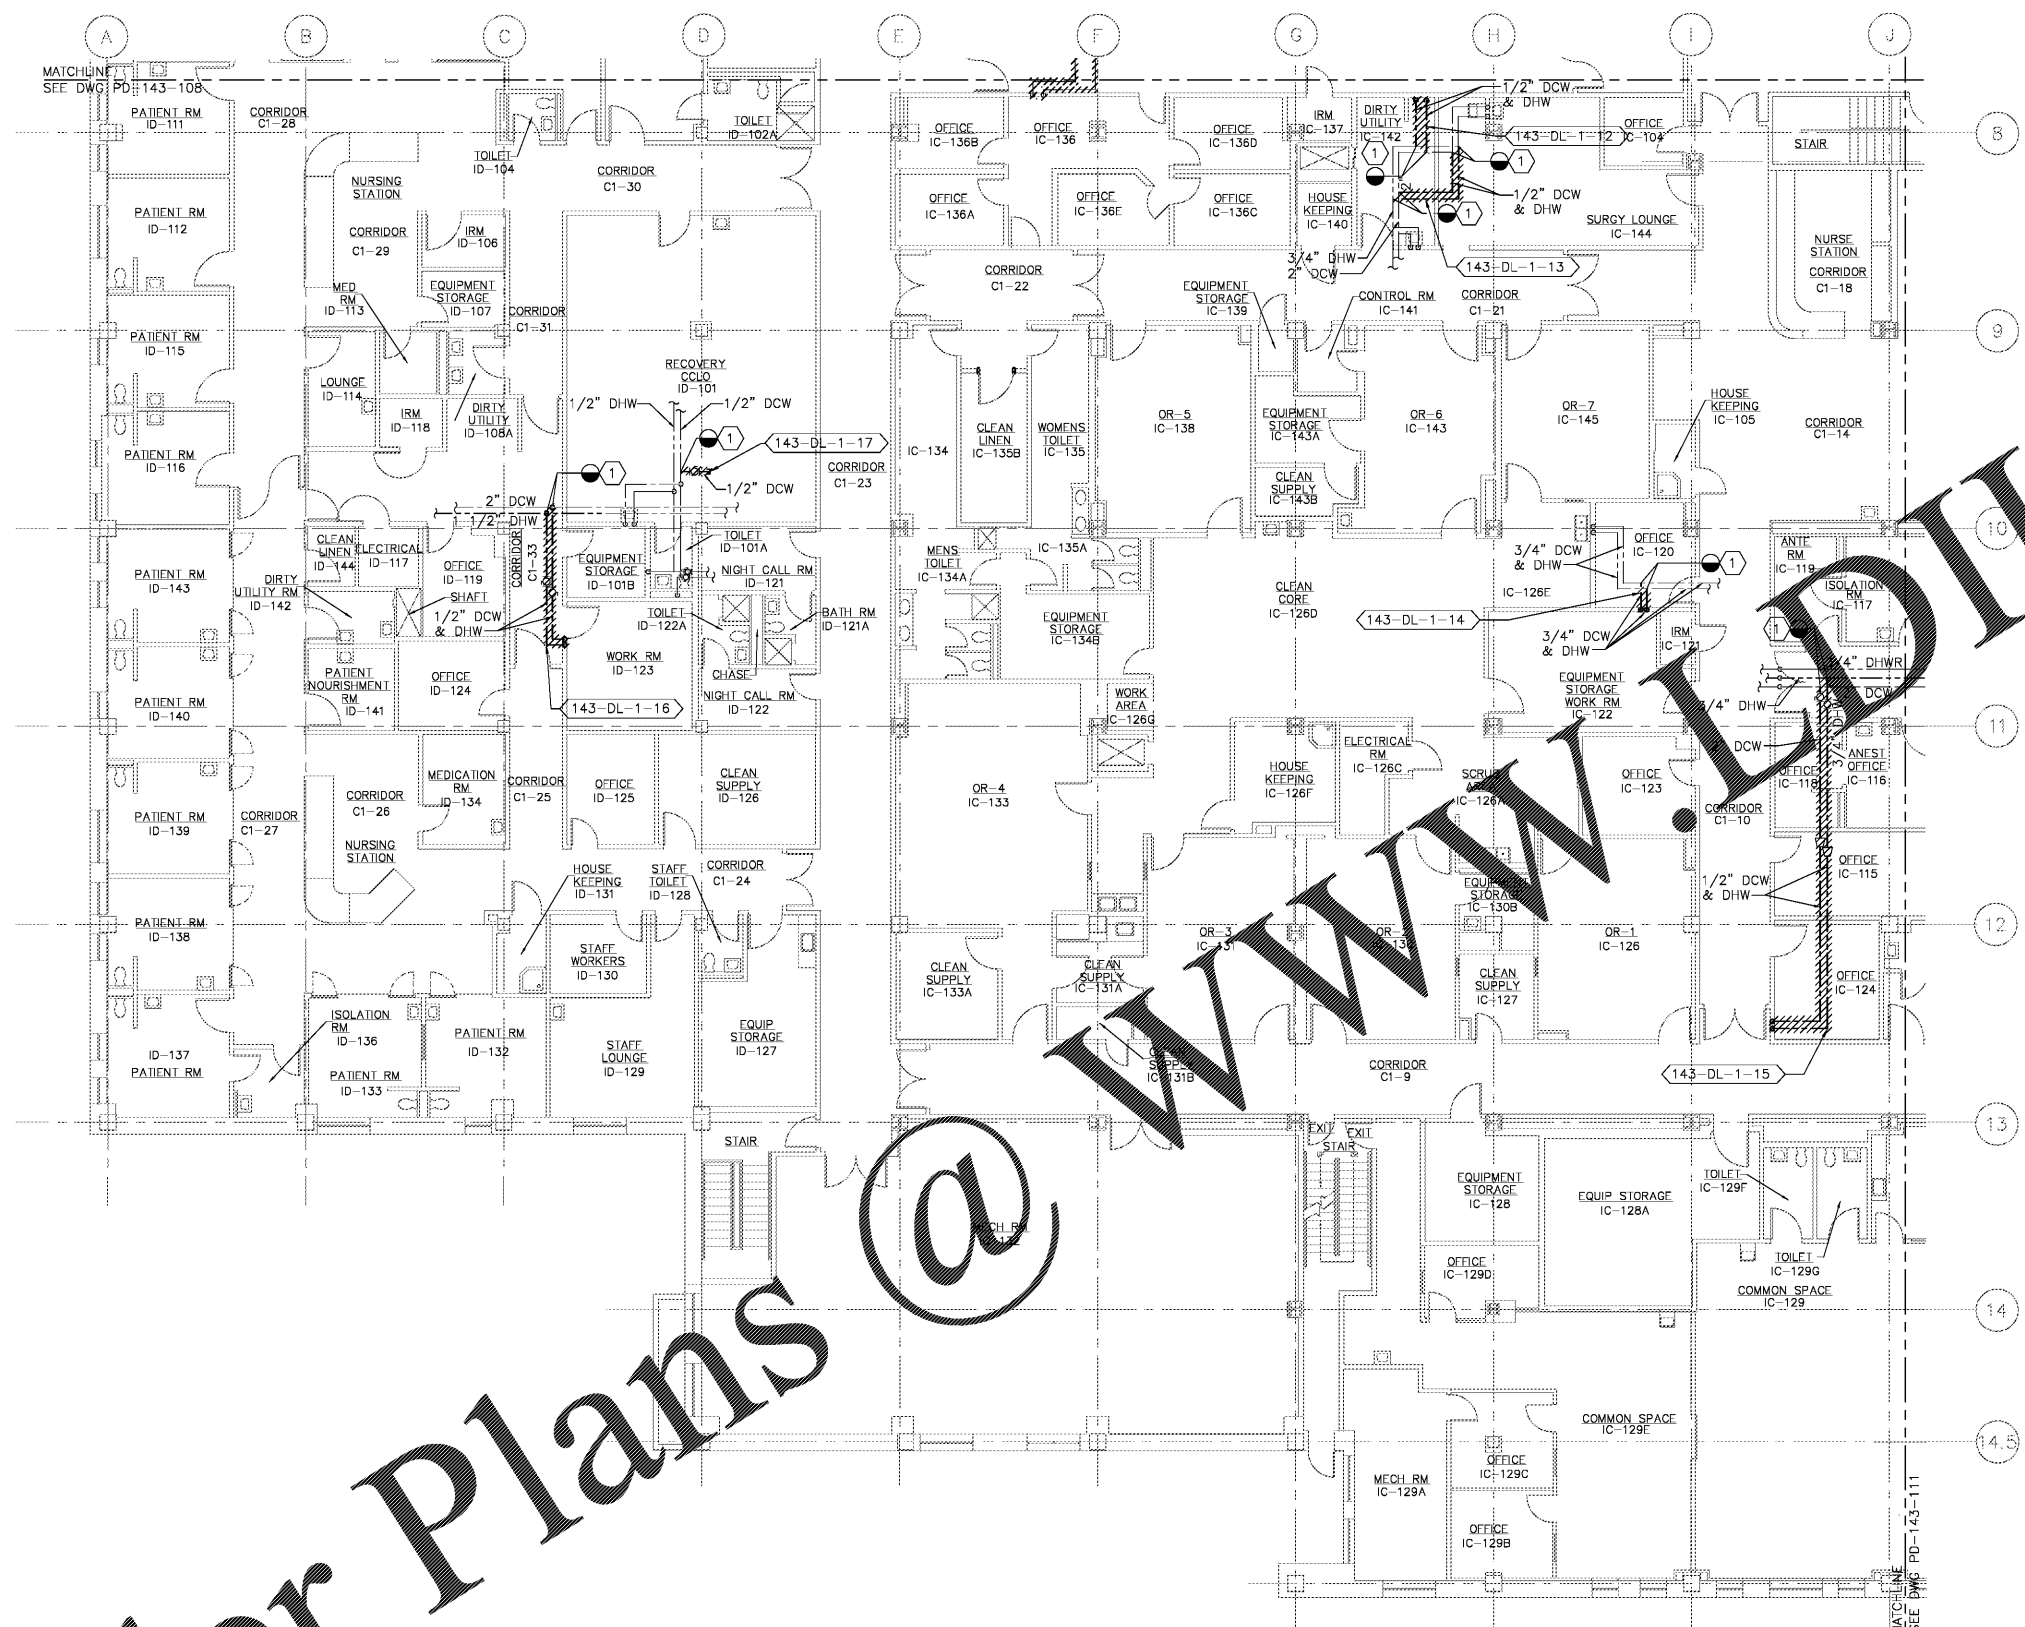


DEMOLITION NOTES:
 1 REMOVE DEADLEG BACK TO MAIN. REMOVE TEE FROM MAIN AND PROVIDE NEW PIPING AND FLEXIBLE ELASTOMERIC INSULATION.

WWW.DLine.com

Order Plans @

PLAN NORTH
 1 **FIRST FLOOR PLUMBING DEMOLITION PLAN - AREA 'C'**
 SCALE: 1/8" = 1'-0"

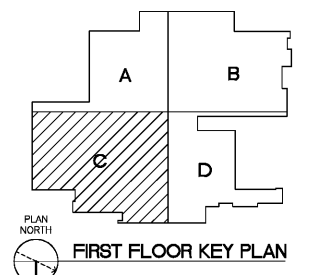

Revisions	Date

Atrix Atrix, plc 102 3rd Avenue, NE PO Box 1628, Hickory, NC 28603 Phone: 828.315.9962 Fax: 828.315.9964 www.atrrixgroup.com	WileyWilson WileyWilson 127 Nantuxville Drive Lynchburg, VA 24502 Phone: 434.947.1901 www.wileywilson.com		Approved: Energy Engineer	Approved: Safety Manager	Approved: Service Chief	Drawing Title PD-143-110 BLDG 143 FIRST FLOOR PLUMBING PLAN AREA 'C' DEMOLITION	Project Title RENOVATE FOR WATER QUALITY	Date 04/28/2017	Project No. 658-15-101	Approved: Chief of Facility Management Svc. Building Number 143	Checked MJG	Drawn JPH	DRAWING SET 2592	Location VA MEDICAL CENTER, SALEM, VA 24153	Dwg. 82 Of 155
			CONSTRUCTION DOCUMENTS	Approved: Infection Control Officer	Approved: Chief of Staff										

Veterans Affairs