



**DEMOLITION NOTES:**

- ① REMOVE DEADLEG BACK TO MAIN. REMOVE TEE FROM MAIN AND PROVIDE NEW PIPING AND FLEXIBLE ELASTOMERIC INSULATION.

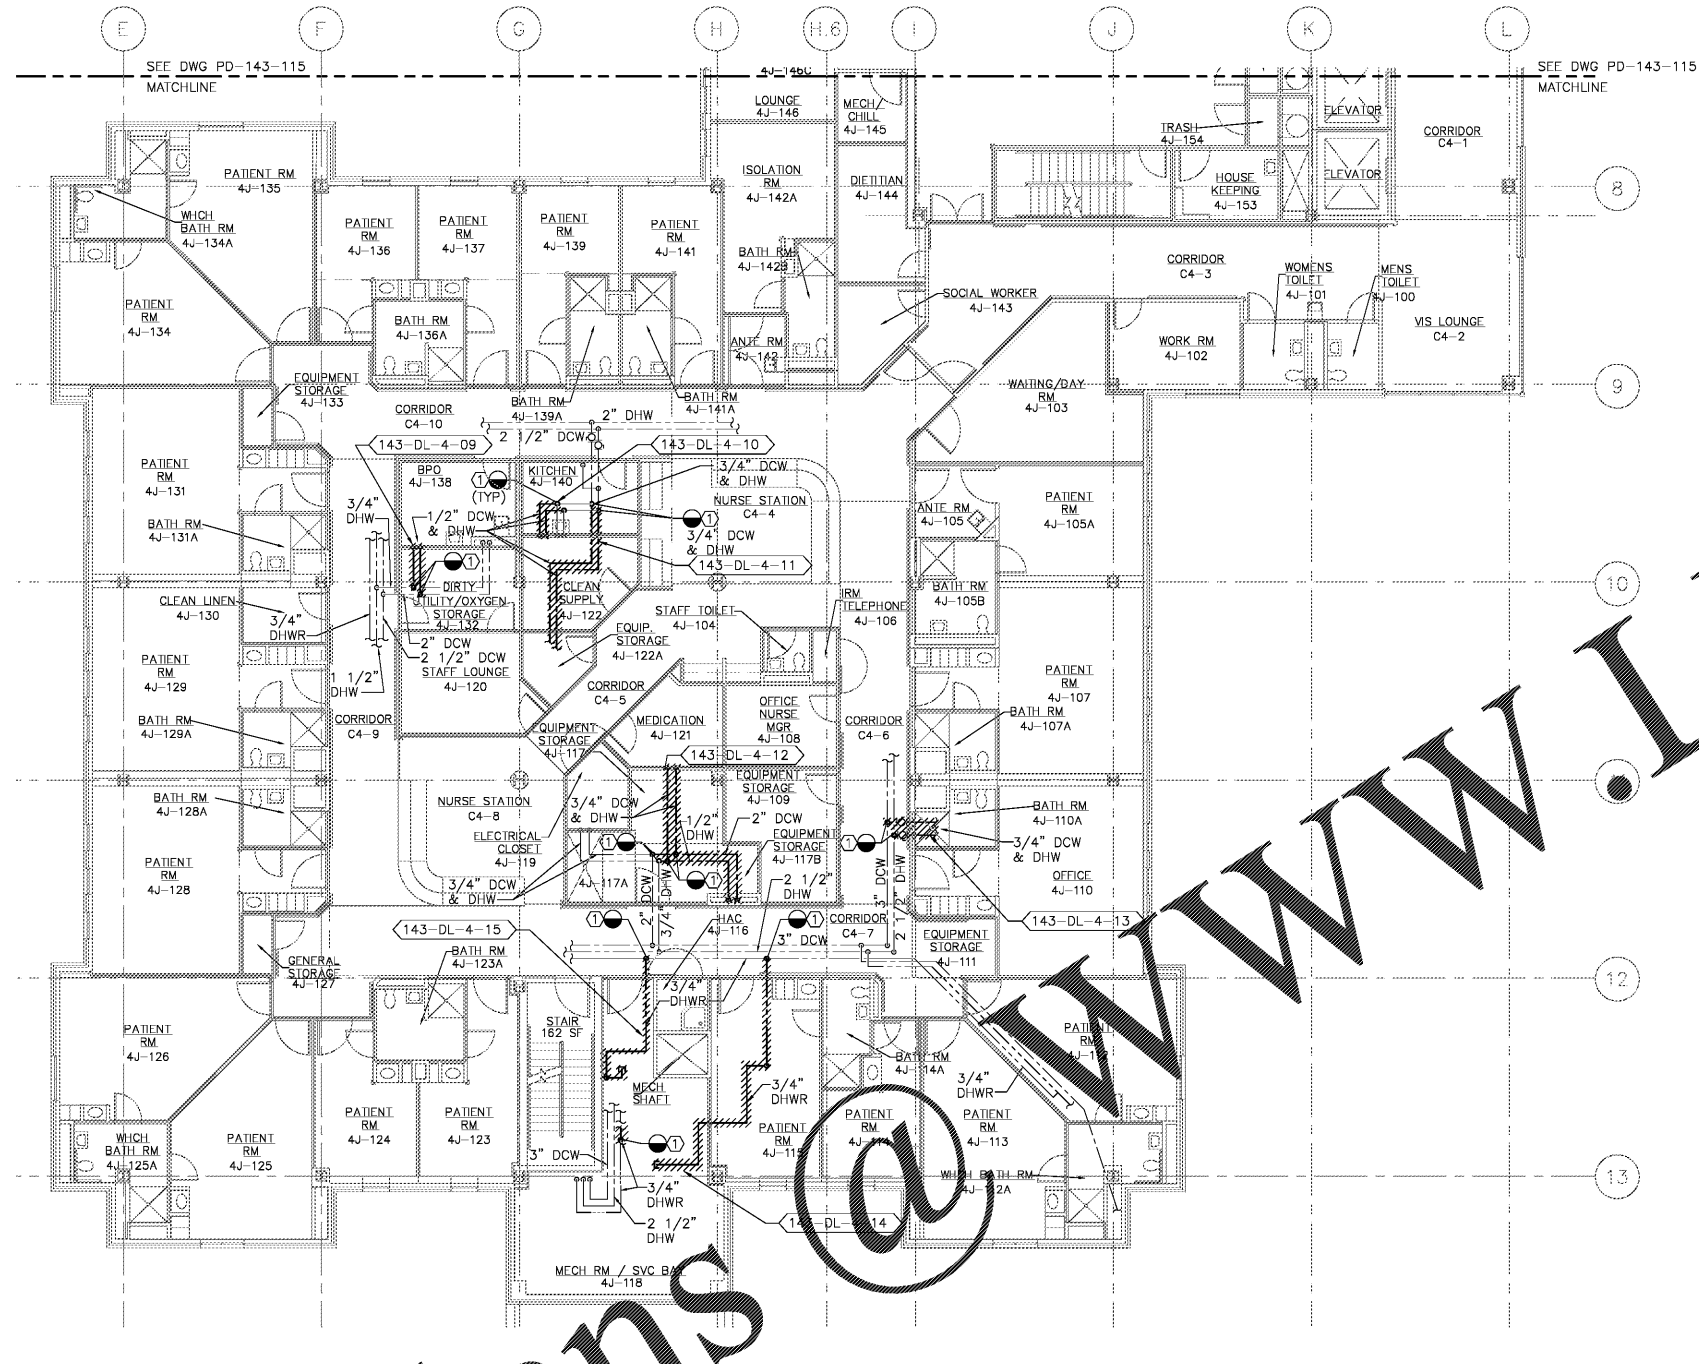

**FOURTH FLOOR PLUMBING DEMOLITION PLAN - AREA 'B'**  
SCALE: 1/8" = 1'-0"

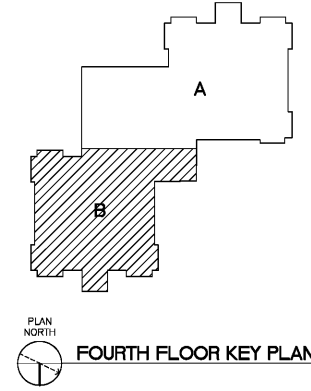

three inches = one foot  
one and one-half inches = one foot  
one inch = one foot  
three-quarters inch = one foot  
one-half inch = one foot  
three-eighths inch = one foot  
one-quarter inch = one foot  
one-eighth inch = one foot

**Order Plans**

Revisions	Date

Atrix, plc  
102 3rd Avenue, NE  
PO Box 1628,  
Hickory, NC 28603  
Phone: 828.315.9962  
Fax: 828.315.9964  
www.atrigroup.com

WileyWilson  
127 Natterville Drive  
Lynchburg, VA 24502  
Phone: 434.947.1901  
www.wileywilson.com

PROFESSIONAL ENGINEER  
Lic. No. 24288  
4/22/2017



<p>Approved: Energy Engineer</p> <p style="text-align: center;"><b>CONSTRUCTION DOCUMENTS</b></p>	<p>Approved: Safety Manager</p> <p>Approved: Infection Control Officer</p> <p>Approved: GEMS Coordinator</p>	<p>Approved: Service Chief</p> <p>Approved: Chief of Staff</p> <p>Approved: Associate Director</p>	<p>Drawing Title PD-143-116 BLDG 143 FOURTH FLOOR PLUMBING PLAN AREA 'B' DEMOLITION</p> <p>Approved: Chief of Facility Management Svc.</p> <p>Approved: Medical Center Director</p>	<p>Project Title <b>RENOVATE FOR WATER QUALITY</b></p> <p>Building Number 143</p> <p>Location VA MEDICAL CENTER, SALEM, VA 24153</p>	<p>Date 04/28/2017</p> <p>Project No. 658-15-101</p> <p>DRAWING SET 2592 Dwg. 88 Of 155</p>
---------------------------------------------------------------------------------------------------	--------------------------------------------------------------------------------------------------------------	----------------------------------------------------------------------------------------------------	-------------------------------------------------------------------------------------------------------------------------------------------------------------------------------------------------	--------------------------------------------------------------------------------------------------------------------------------------------------	-------------------------------------------------------------------------------------------------------------

Veterans Affairs