



- DEMOLITION NOTES:**
- ① REMOVE DEADLEG BACK TO MAIN. REMOVE TEE FROM MAIN AND PROVIDE NEW PIPING AND FIBERGLASS INSULATION.
  - ② REMOVE CONTROL WIRING AND CONDUIT BACK TO MIXING VALVE STATION CONTROL PANEL. REMOVE CONTROL PANEL.
  - ③ REMOVE PIPING PER DIAGRAM 'A' ON THIS DRAWING.
  - ④ REMOVE (2) 3/4" DHWR LINES ALONG WALL.

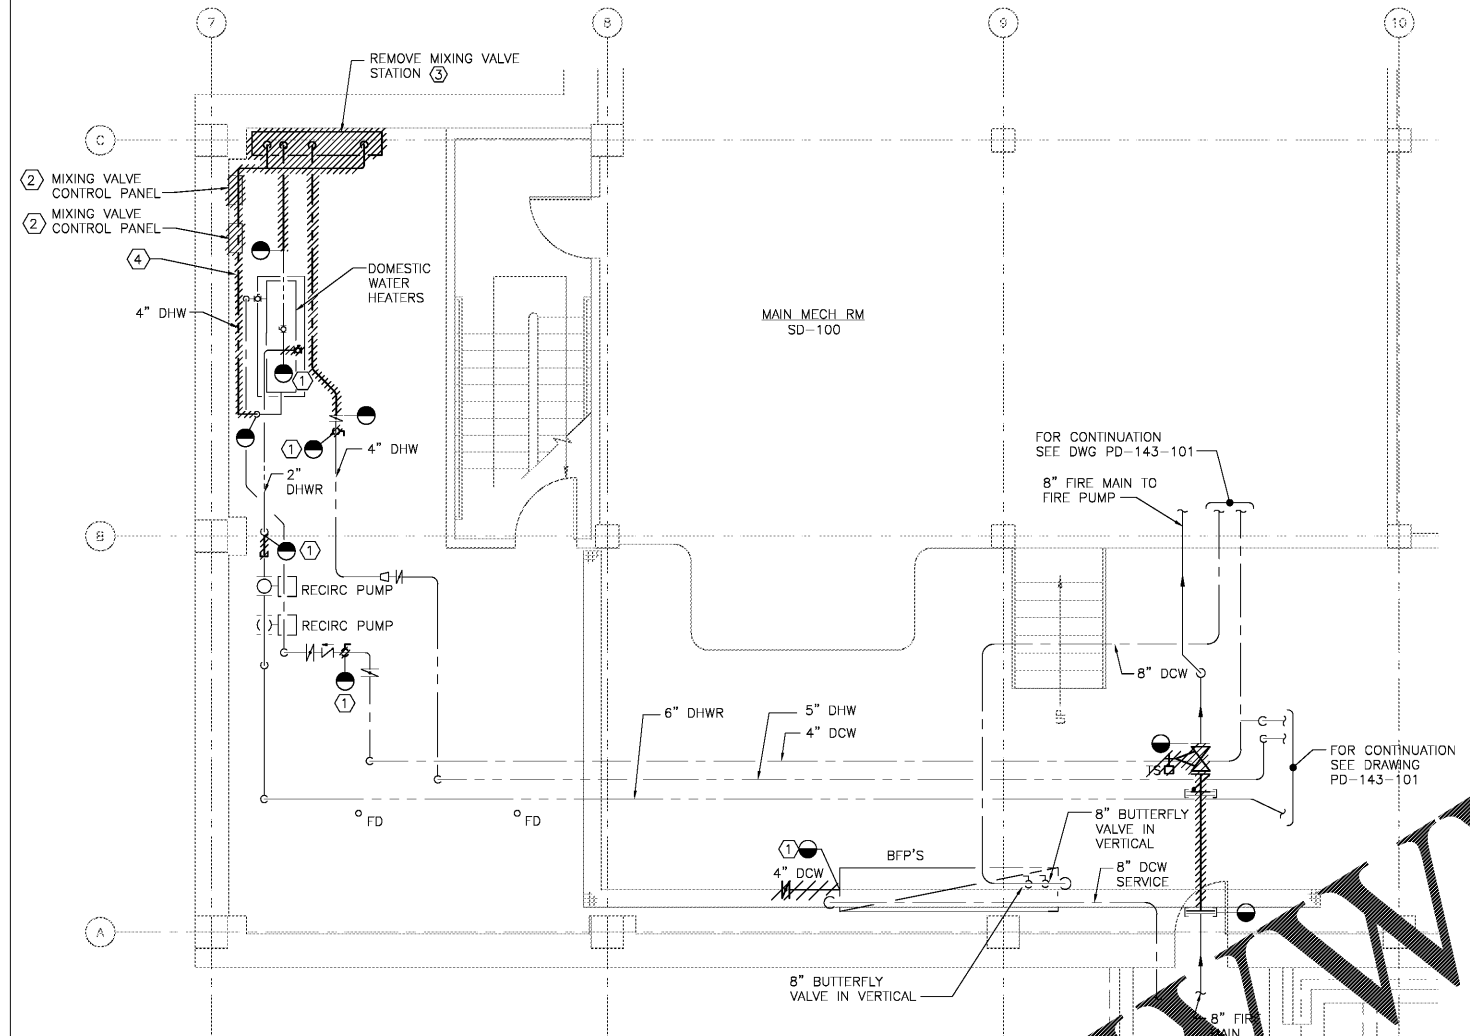

PLAN NORTH  
 ① ENLARGED SUB-BASEMENT PLUMBING PLAN  
 SCALE: 1/4" = 1'-0"

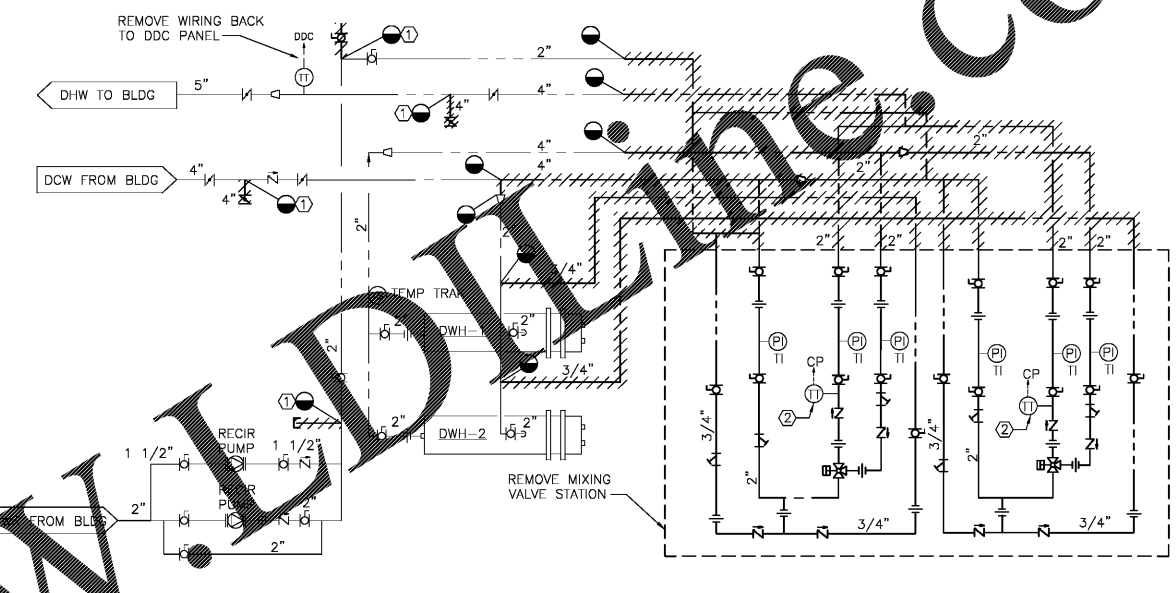

A BLDG 143 DOMESTIC WATER HEATERS DOMESTIC WATER DEMOLITION DIAGRAM  
 NO SCALE

Revisions	Date

**Atriax**  
 Atriax, pllc  
 102 3rd Avenue, NE  
 PO Box 1628,  
 Hickory, NC 28603  
 Phone: 828.315.9962  
 Fax: 828.315.9964  
 www.atriaxgroup.com

**Wiley Wilson**  
 Wiley Wilson  
 127 Nationwide Drive  
 Lynchburg, VA 24502  
 Phone: 434.947.1901  
 www.wileywilson.com



Approved: Energy Engineer	Approved: Safety Manager	Approved: Service Chief
CONSTRUCTION DOCUMENTS	Approved: Infection Control Officer	Approved: Chief of Staff
	Approved: GEMS Coordinator	Approved: Associate Director

Approved: Chief of Facility Management Svc.	Approved: Medical Center Director
---	-----------------------------------

Drawing Title PD-143-401 BLDG 143 ENLARGED SUB-BASEMENT PLUMBING PLAN DEMOLITION		Project Title RENOVATE FOR WATER QUALITY	
Building Number 143	Checked MJG	Drawn JFC	Date 04/28/2017
Location VA MEDICAL CENTER, SALEM, VA 24153		Project No. 658-15-101	
Drawing Set 2592		Dwg. 69 Of 155	

Veterans Affairs