


three inches = one foot
 one and one-half inches = one foot
 one inch = one foot
 three-quarters inch = one foot
 one-half inch = one foot
 three-eighths inch = one foot
 one-quarter inch = one foot
 one-eighth inch = one foot

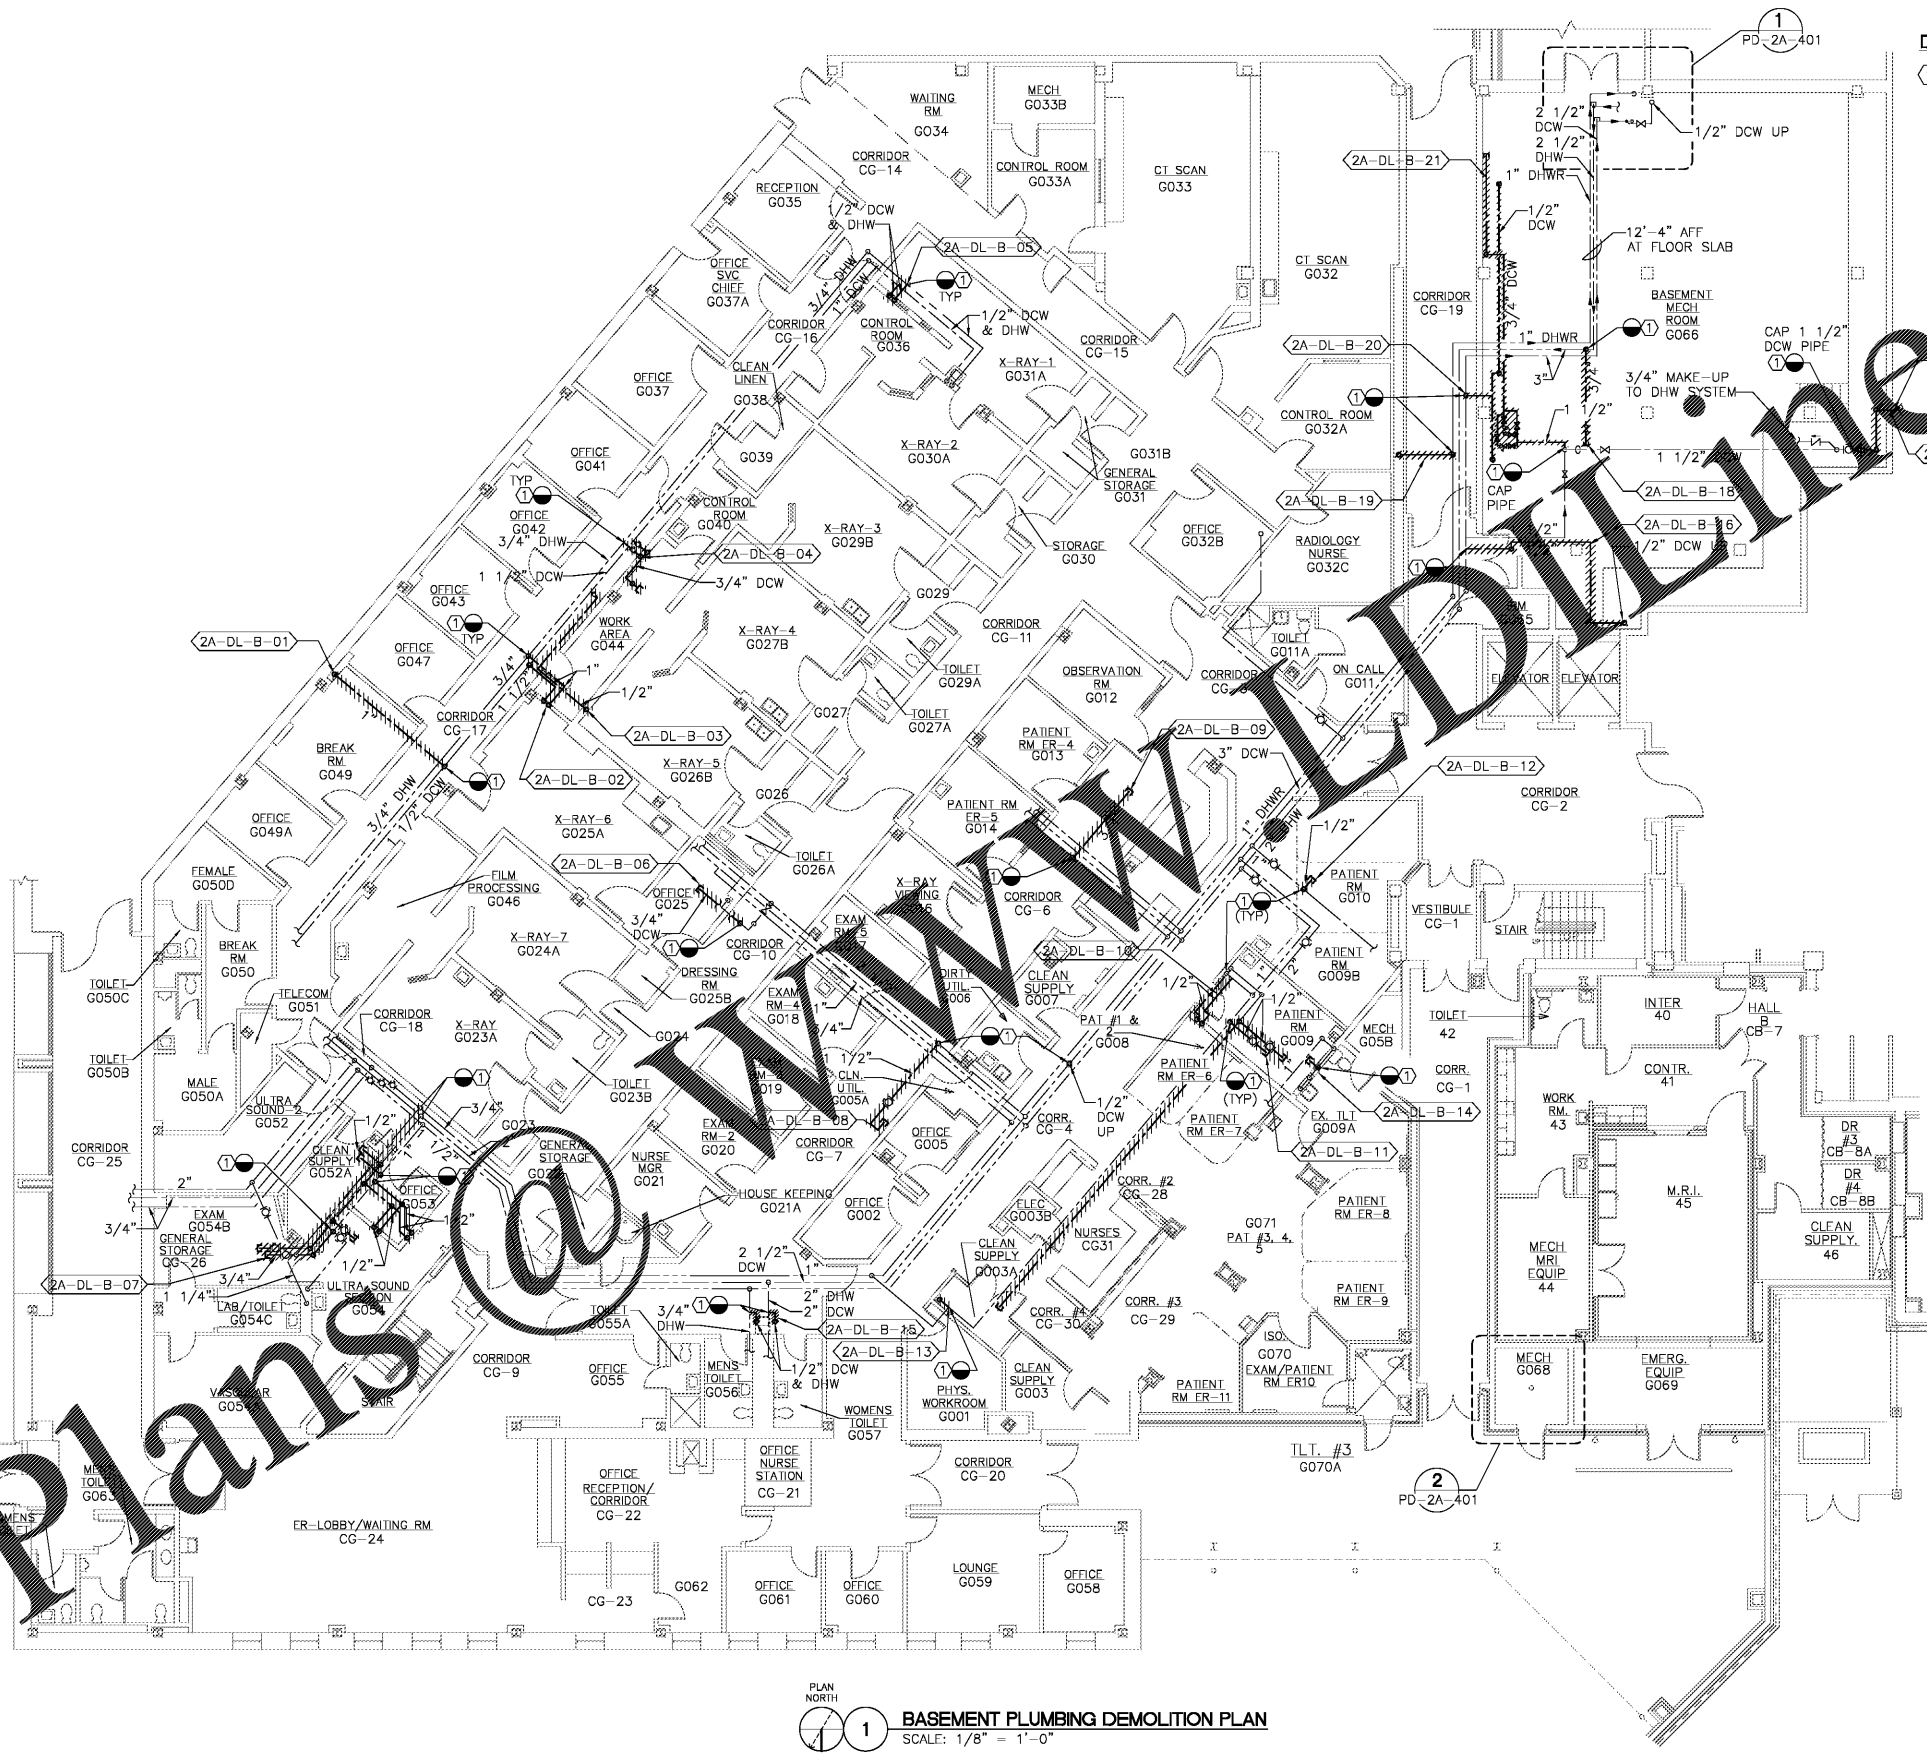

DEMOLITION NOTES:
 ① REMOVE DEADLEG BACK TO MAIN. REMOVE TEE FROM MAIN AND PROVIDE NEW PIPING AND FLEXIBLE ELASTOMERIC INSULATION.

PLAN NORTH
 ① **BASEMENT PLUMBING DEMOLITION PLAN**
 SCALE: 1/8" = 1'-0"

Order Plans @

Atrix
 Atrix, plc
 102 3rd Avenue, NE
 PO Box 1628,
 Hickory, NC 28603
 Phone: 828.315.9962
 Fax: 828.315.9964
 www.atrrixgroup.com



Approved: Energy Engineer
CONSTRUCTION DOCUMENTS

Approved: Safety Manager
 Approved: Infection Control Officer
 Approved: GEMS Coordinator

Approved: Service Chief
 Approved: Chief of Staff
 Approved: Associate Director

Drawing Title
**PD-2A-101
 BLDG 2A BASEMENT PLUMBING PLAN
 DEMOLITION**

Project Title
RENOVATE FOR WATER QUALITY

Date
 04/28/2017
 Project No.
 658-15-101
 Building Number
 2A
 Location
 VA MEDICAL CENTER, SALEM, VA 24153
 Checked
 MJC
 Drawn
 WJC
 DRAWING SET
 2592
 Dwg. 32 Of 155

Veterans Affairs