
 


**DEMOLITION NOTES:**

- ① REMOVE DEADLEG BACK TO MAIN. REMOVE TEE FROM MAIN AND PROVIDE NEW PIPING AND FLEXIBLE ELASTOMERIC INSULATION.
- ② CONNECT 3/4" DHW TO 3/4" DHWR TO MAINTAIN HOT WATER RECIRCULATING.
- ③ REMOVE EXISTING VALVE

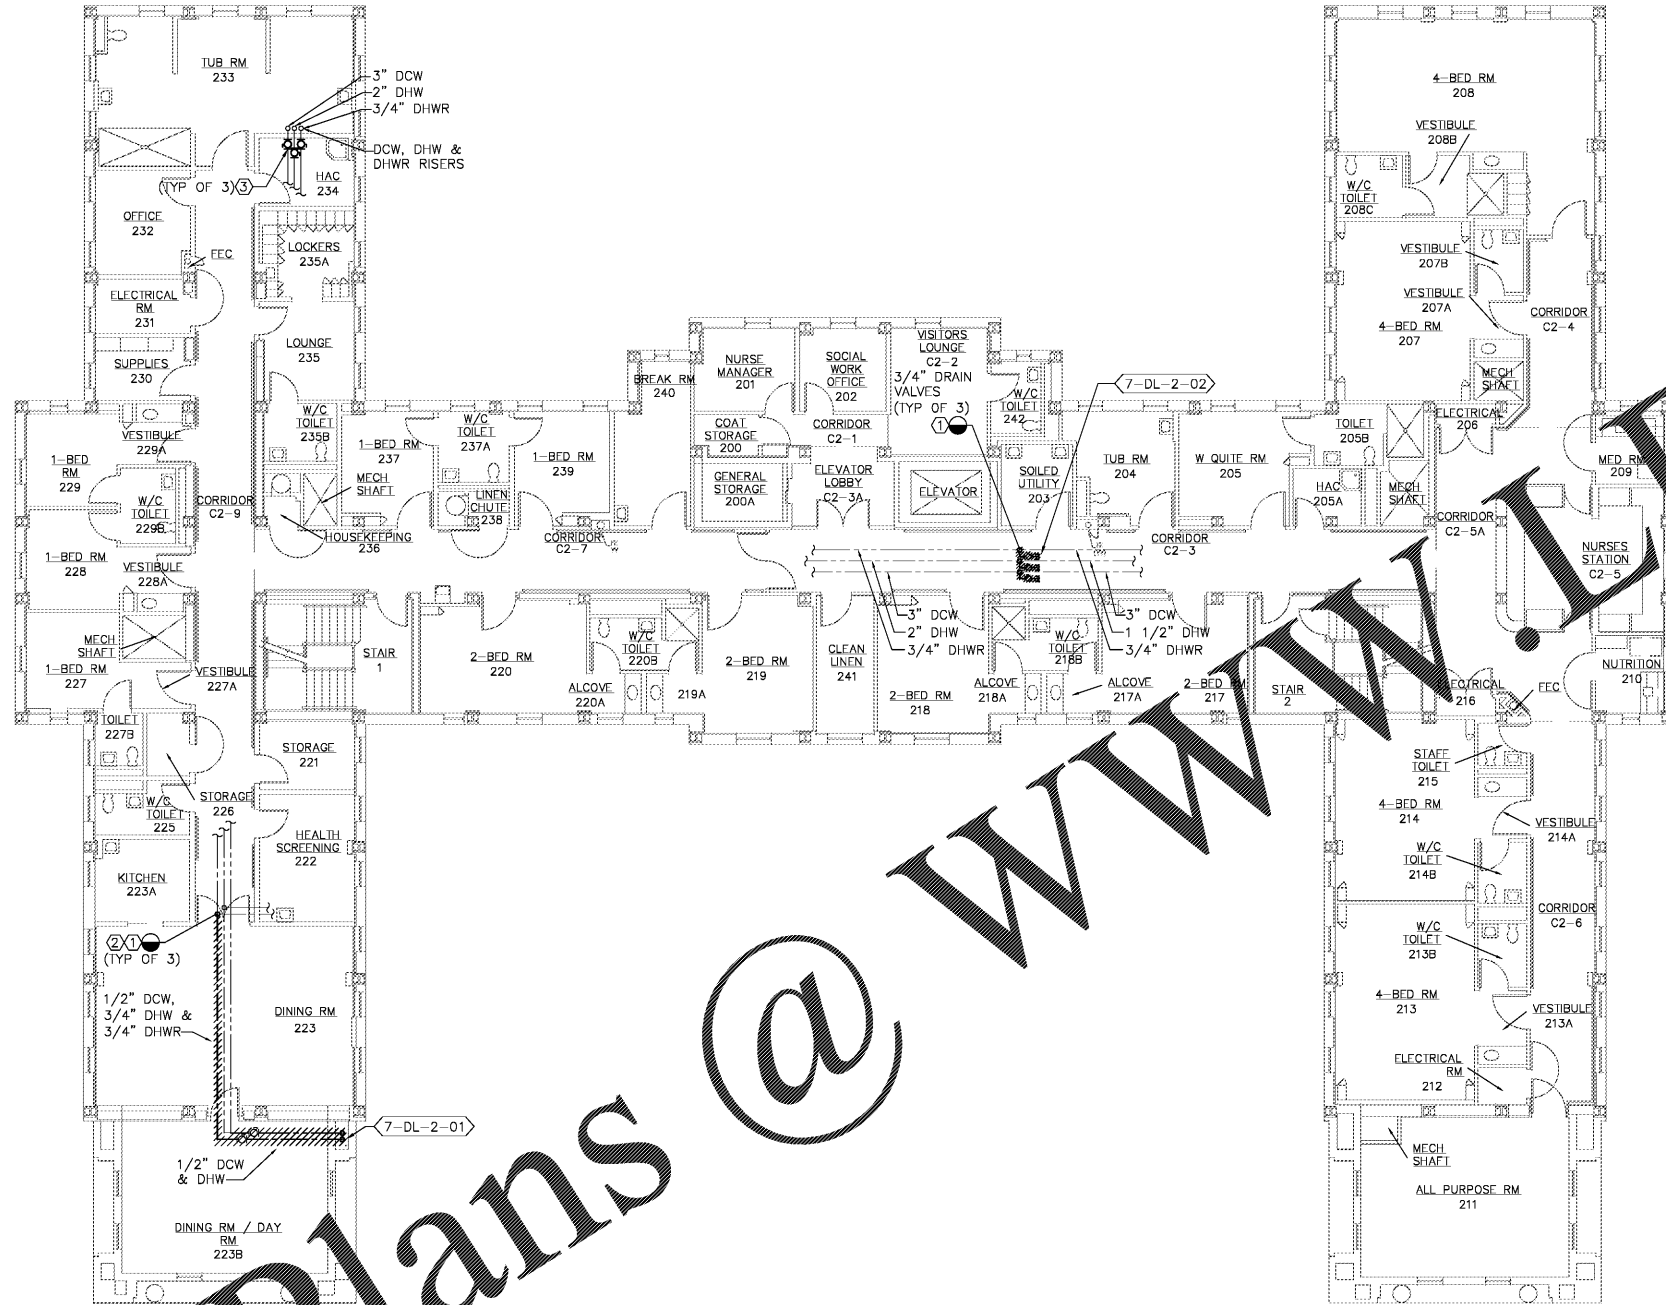

PLAN NORTH  
 ① SECOND FLOOR PLUMBING DEMOLITION PLAN  
 SCALE: 1/8" = 1'-0"



WWW.DILine.com  
 Order Plans @

Revisions Date	 Atriax, LLC 102 3rd Avenue, NE PO Box 1628, Hickory, NC 28603 Phone: 828.315.9962 Fax: 828.315.9964 www.atriaxgroup.com	 WileyWilson 127 Natterville Drive Lynchburg, VA 24502 Phone: 434.947.1901 Fax: 434.947.1901 www.wileywilson.com	 Approved: Energy Engineer	Approved: Safety Manager Approved: Infection Control Officer Approved: GEMS Coordinator	Approved: Service Chief Approved: Chief of Staff Approved: Associate Director	Drawing Title PD-7-103 BLDG 7 SECOND FLOOR PLUMBING PLAN DEMOLITION Approved: Chief of Facility Management Svc. Approved: Medical Center Director	Project Title RENOVATE FOR WATER QUALITY Building Number 7 Location VA MEDICAL CENTER, SALEM, VA 24153	Date 04/28/2017 Project No. 658-15-101 DRAWING SET 2592 Dwg. 37 Of 155	Veterans Affairs
-------------------	---	--	-------------------------------	---	---	--	---	--	------------------