


three inches = one foot  
 one and one-half inches = one foot  
 one inch = one foot  
 three-quarters inch = one foot  
 one-half inch = one foot  
 three-eighths inch = one foot  
 one-quarter inch = one foot  
 one-eighth inch = one foot

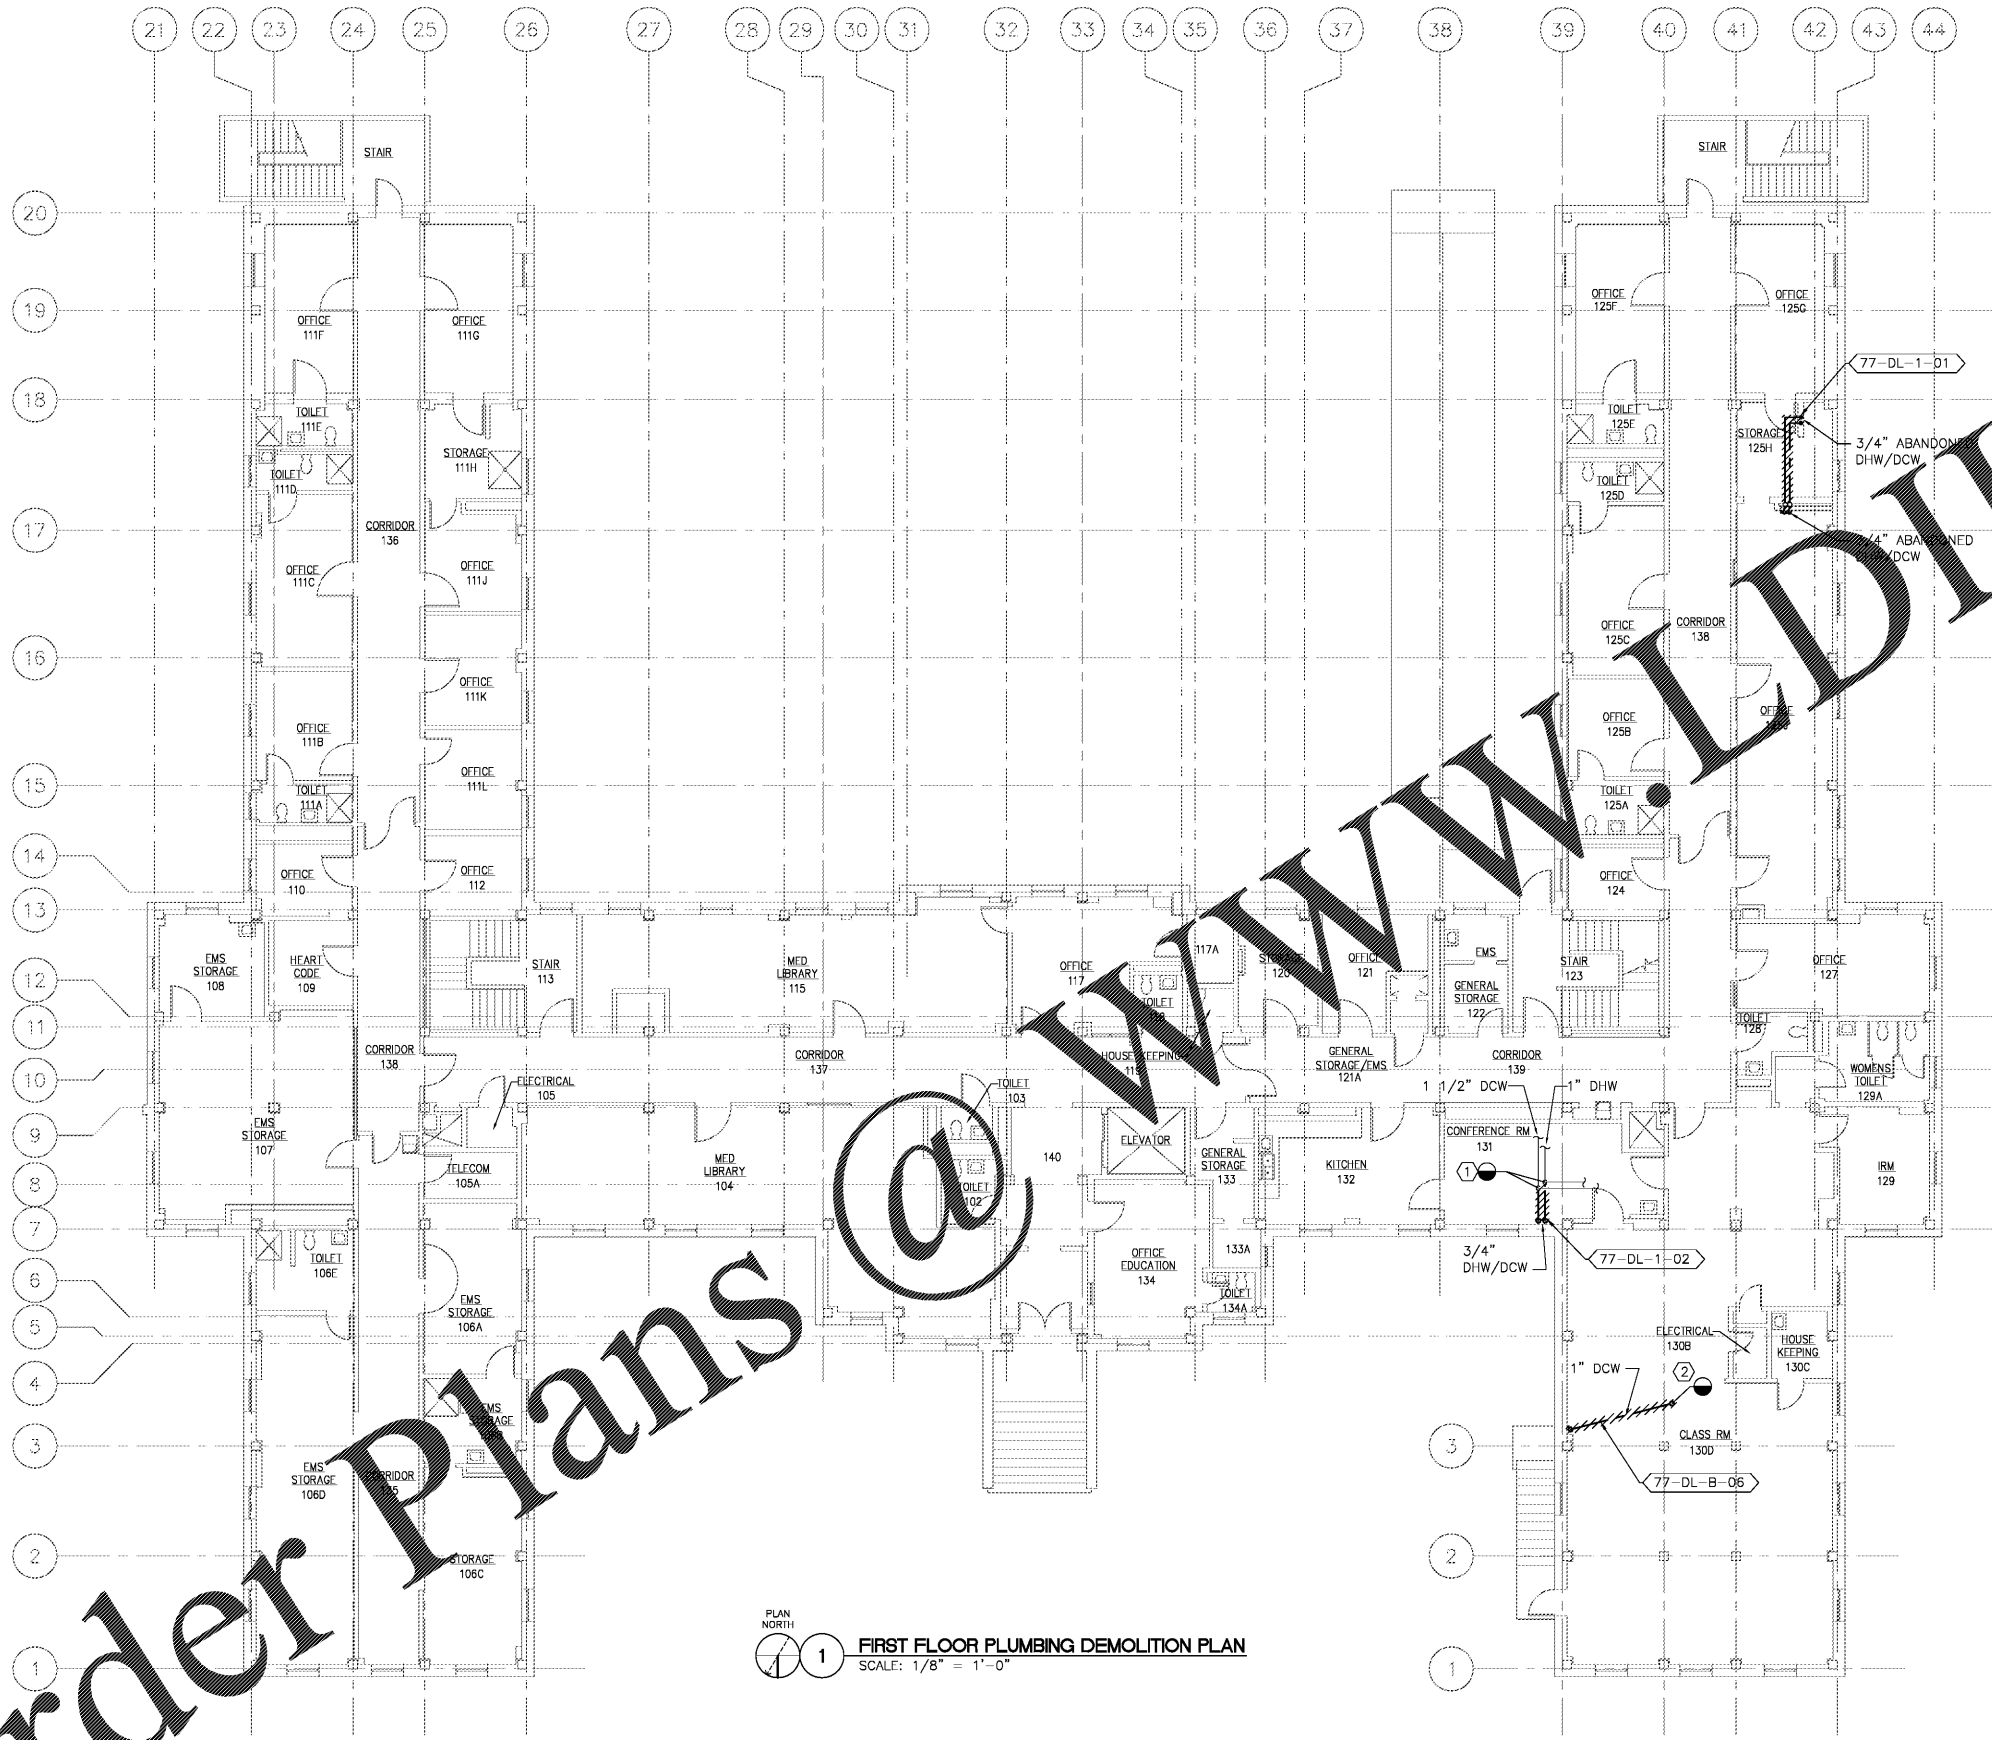

**DEMOLITION NOTES:**

- 1 REMOVE DEADLEG BACK TO MAIN, REMOVE TEE FROM MAIN AND PROVIDE NEW PIPING AND FIBERGLASS INSULATION.
- 2 CUT AND CAP PIPE AT SECOND FLOOR SLAB.

**GENERAL NOTES:**

1. REFER TO THE DOMESTIC WATER DEAD LEG AND ASBESTOS ABANDONMENT SCHEDULE FOR PIPING CONTAINING ASBESTOS INSULATION.

PLAN NORTH  
**1** FIRST FLOOR PLUMBING DEMOLITION PLAN  
 SCALE: 1/8" = 1'-0"

Order Plans @ WWW.DILine.com

Revisions	Date

**Atrix**  
 Atrix, p.l.c.  
 102 3rd Avenue, NE  
 PO Box 1628,  
 Hickory, NC 28603  
 Phone: 828.315.9962  
 Fax: 828.315.9964  
 www.atrifaxgroup.com

**Wiley/Wilson**  
 Wiley/Wilson  
 127 Nationwide Drive  
 Lynchburg, VA 24502  
 Phone: 434.947.1901  
 www.wileywilson.com

**COMMONWEALTH OF VIRGINIA**  
  
 Lic. No. 24298  
 4/22/2017  
 PROFESSIONAL ENGINEER



Approved: Energy Engineer	Approved: Safety Manager	Approved: Service Chief
	Approved: Infection Control Officer	Approved: Chief of Staff
CONSTRUCTION DOCUMENTS	Approved: GEMS Coordinator	Approved: Associate Director

Approved: Chief of Facility Management Svcs.	Building Number 77	Checked MJG	Drawn JPH
Approved: Medical Center Director	Location VA MEDICAL CENTER, SALEM, VA 24153		Date 04/28/2017
			Project No. 688-15-101
			DRAWING SET 2592
			Dwg. 51 Of 155

Drawing Title <b>PD-77-103          BLDG 77 FIRST FLOOR PLUMBING PLAN          DEMOLITION</b>	Project Title <b>RENOVATE FOR WATER QUALITY</b>	Date 04/28/2017	<b>Veterans          Affairs</b>
Approved: Chief of Facility Management Svcs.	Building Number 77	Checked MJG	
Approved: Medical Center Director	Location VA MEDICAL CENTER, SALEM, VA 24153	Drawing Set 2592	
Approved: GEMS Coordinator	Approved: Associate Director	Project No. 688-15-101	
Approved: Infection Control Officer	Approved: Chief of Staff	Dwg. 51 Of 155	