



three inches = one foot  
 one and one-half inches = one foot  
 one inch = one foot  
 three-quarters inch = one foot  
 one-half inch = one foot  
 three-eighths inch = one foot  
 one-quarter inch = one foot  
 one-eighth inch = one foot


- GENERAL NOTES:**
- REPLACE ABANDONED DOMESTIC WATER HEATER DWH-1 PRIOR TO REMOVING DWH-2.
- DEMOLITION NOTES:**
- REMOVE VERTICAL STORAGE STEAM FIRED DOMESTIC WATER HEATER AND ASSOCIATED PIPING, VALVING AND ACCESSORIES.
  - REMOVE 4" ABANDONED PRESSURE REDUCING VALVE, SERVICE GATE VALVES AND PIPING. REMOVE 4" TEES FROM DCW MAIN AND PROVIDE NEW PIPING AND FIBERGLASS INSULATION.
  - REMOVE 4" TEE FROM 4" DCW AND PROVIDE NEW PIPE AND FIBERGLASS INSULATION.
  - REMOVE 3-WAY PNEUMATIC MIXING VALVE AND CONTROLS INCLUDING TEMPERATURE SENSING, CONTROLLER, CONDUIT, WIRING, AND TUBING.
  - REMOVE TEMPERATURE TRANSMITTER AND WIRE WIRING BACK TO DDC PANEL.
  - REMOVE 20"X20"X10" ABANDONED CONTROL PANEL.

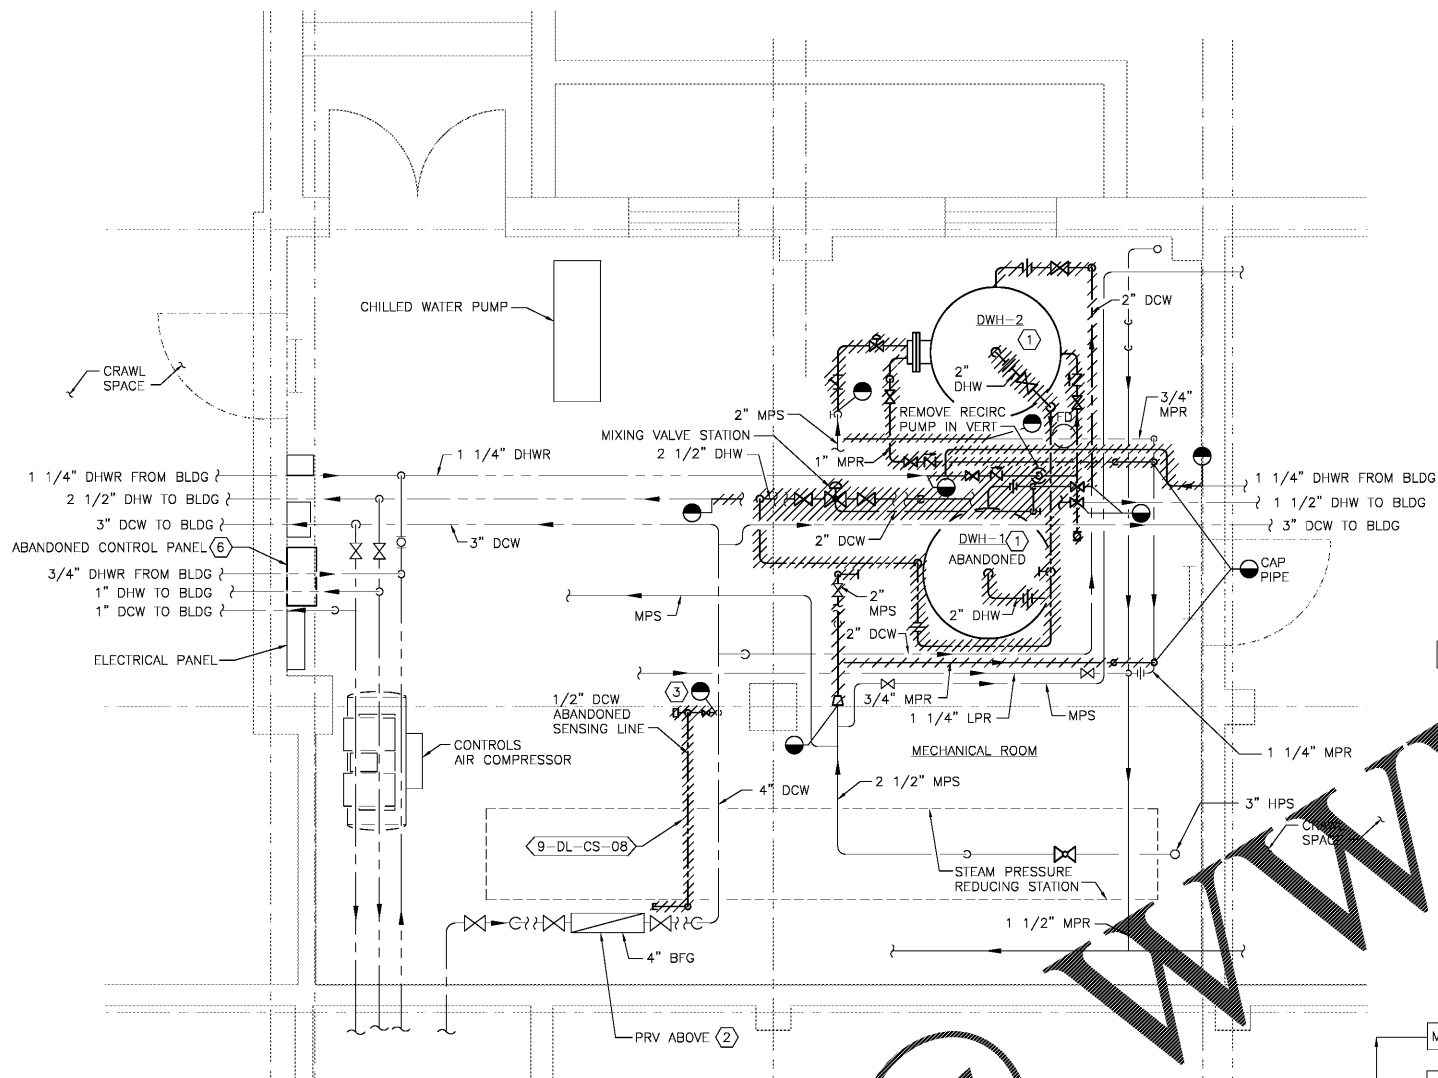

PLAN NORTH  
 1 ENLARGED SUB-BASEMENT PLUMBING DEMOLITION PLAN  
 SCALE: 1/2" = 1'-0"

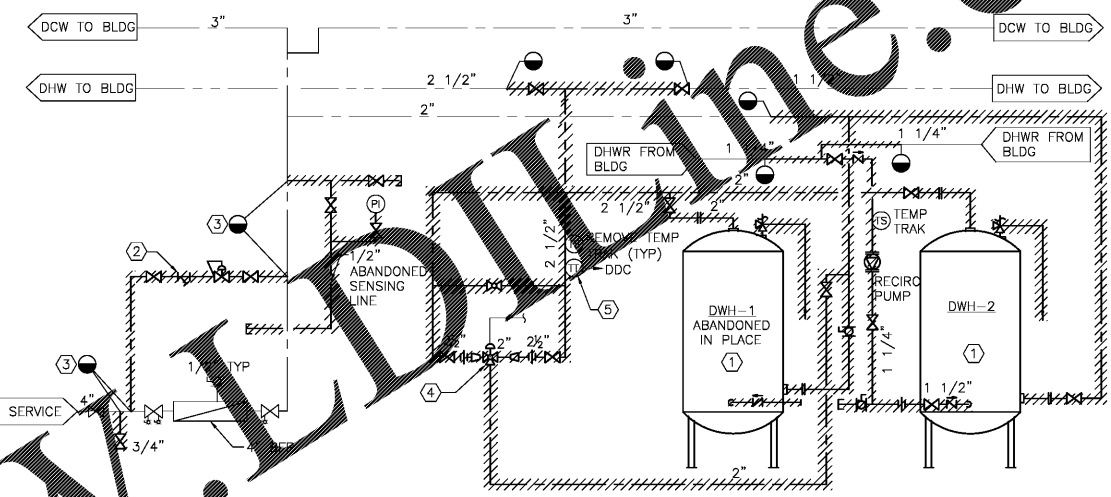

A BLDG 9 WATER SERVICE AND DOMESTIC WATER HEATERS DOMESTIC WATER DEMOLITION DIAGRAM  
 NO SCALE

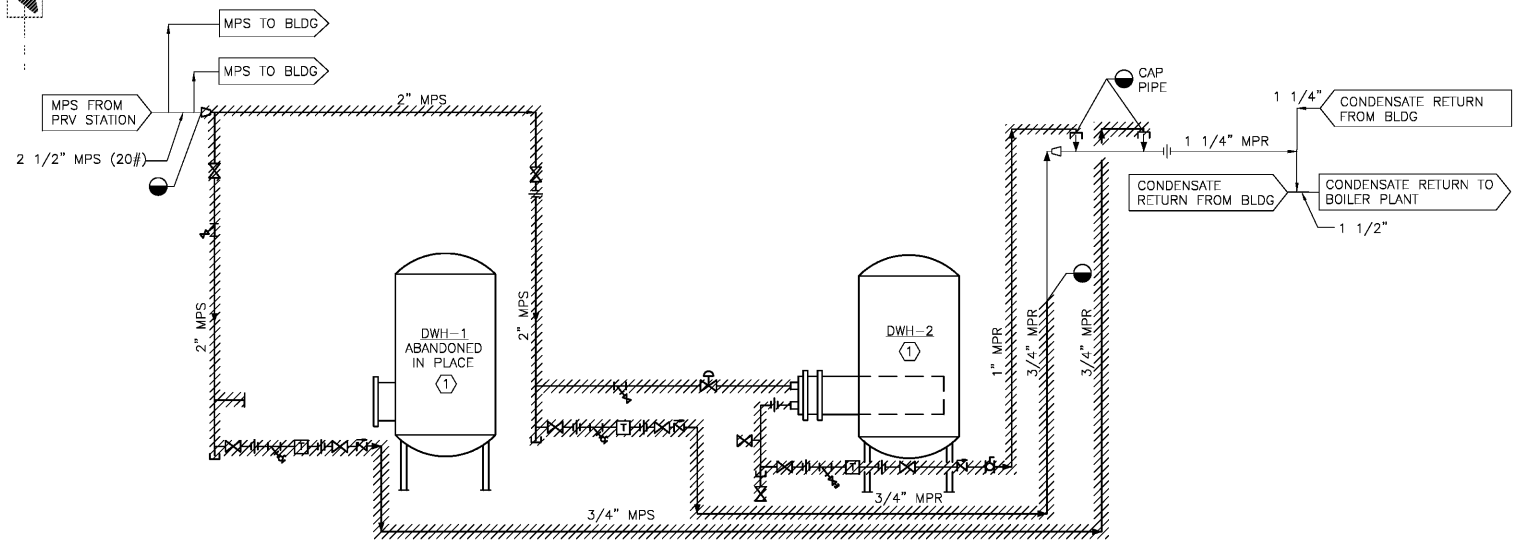

B BLDG 9 DOMESTIC WATER HEATERS STEAM AND CONDENSATE DEMOLITION DIAGRAM  
 NO SCALE

**Order Plans @**

Revisions	Date

**Atrix**  
 Atrix, plc  
 102 3rd Avenue, NE  
 PO Box 1628,  
 Hickory, NC 28603  
 Phone: 828.315.9962  
 Fax: 828.315.9964  
 www.atrigrp.com

**WileyWilson**  
 WileyWilson  
 127 Nationwide Drive  
 Lynchburg, VA 24502  
 Phone: 434.947.1901  
 Fax: 434.947.1901  
 www.wileywilson.com



Approved: Energy Engineer  
**CONSTRUCTION DOCUMENTS**

Approved: Safety Manager  
 Approved: Infection Control Officer  
 Approved: GEMS Coordinator  
 Approved: Service Chief  
 Approved: Chief of Staff  
 Approved: Associate Director

Drawing Title  
 PD-9-401  
 BLDG 9 ENLARGED SUB-BASEMENT PLUMBING  
 PLAN DEMOLITION  
 Approved: Chief of Facility Management Svc.  
 Approved: Medical Center Director

Project Title  
 RENOVAE FOR WATER QUALITY  
 Building Number  
 9  
 Location  
 VA MEDICAL CENTER, SALEM, VA 24153

Date  
 04/28/2017  
 Project No.  
 658-15-101  
 DRAWING SET  
 2592  
 Dwg. 43 Of 155

Veterans Affairs