



Order Plans @ [www.LDILine.com](http://www.LDILine.com)



**CONSTRUCTION NOTES:**  
 ① INSULATE PIPING WITH FIBERGLASS INSULATION.

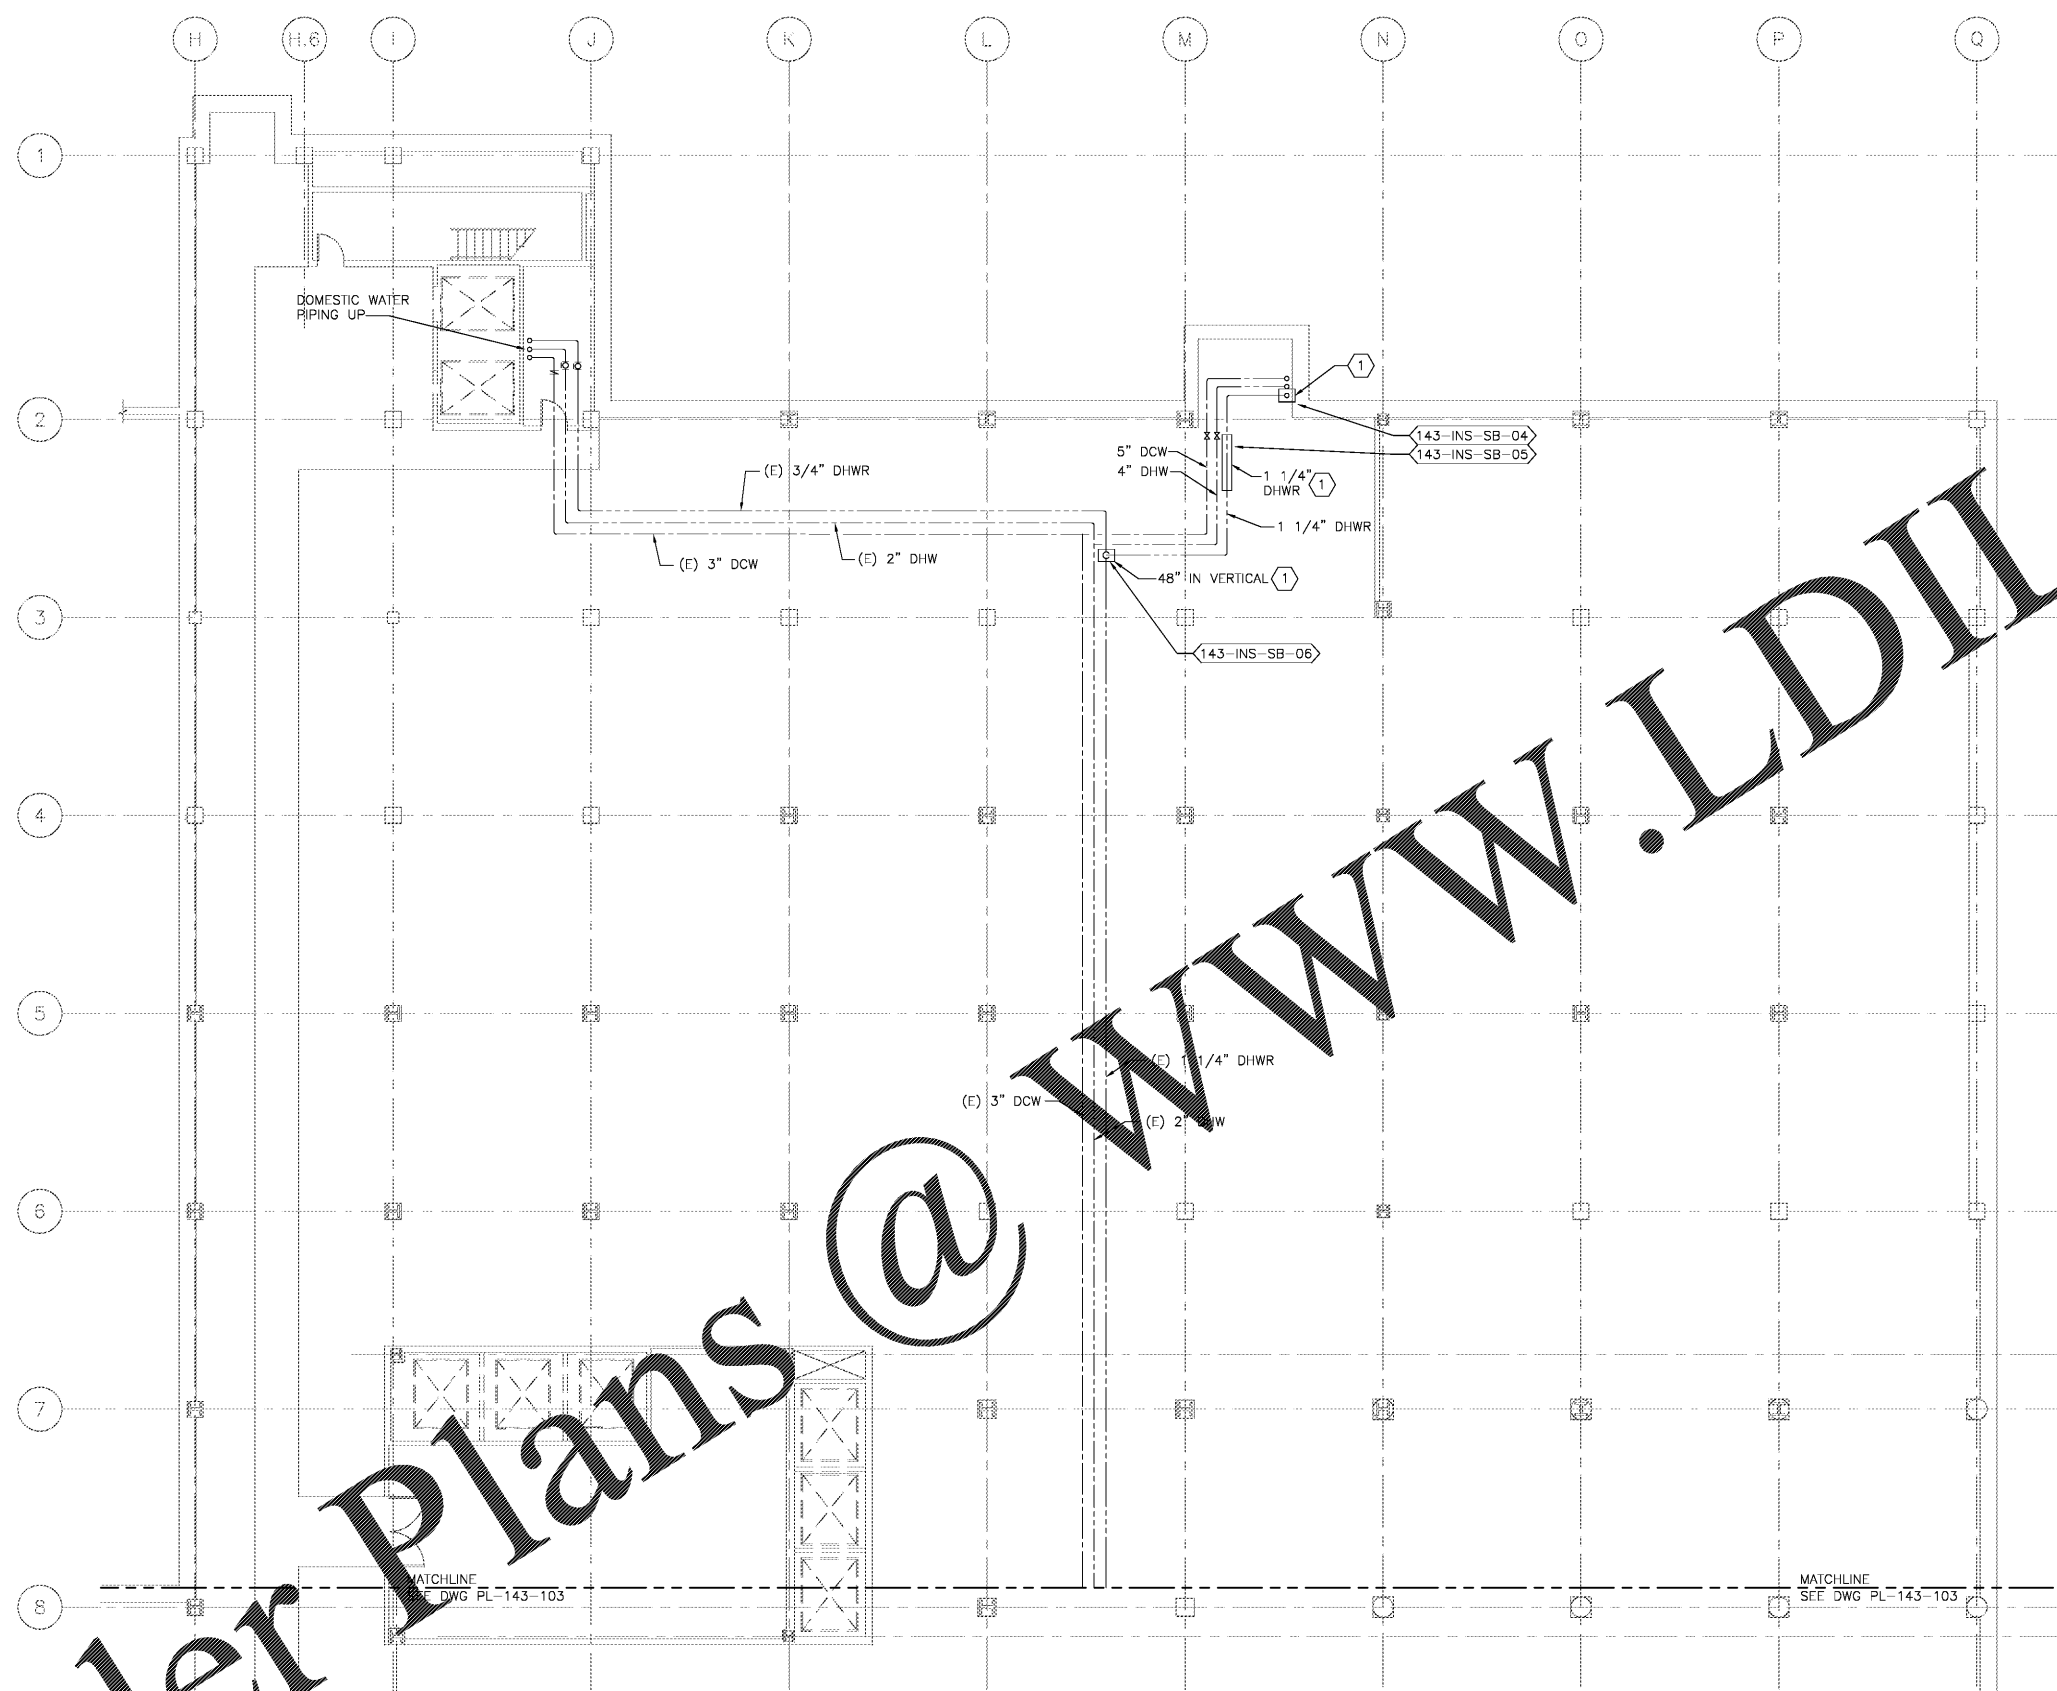

PLAN NORTH  
 1 SUB-BASEMENT PLUMBING PLAN - AREA "B"  
 SCALE: 1/8" = 1'-0"

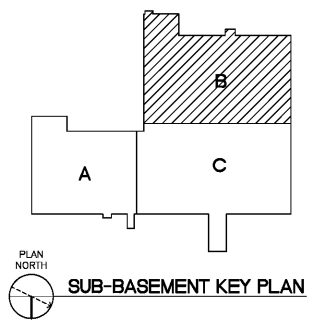

Revisions	Date

**Atrix**  
 atrix, pllc  
 102 3rd Avenue, NE  
 PO Box 1628,  
 Hickory, NC 28603  
 Phone: 828.315.9962  
 Fax: 828.315.9964  
 www.atrifaxgroup.com

Wiley/Wilson  
 Wiley/Wilson  
 127 Nationwide Drive  
 Lynchburg, VA 24502  
 Phone: 434.947.1901  
 www.wileywilson.com



Approved: Energy Engineer  
**CONSTRUCTION DOCUMENTS**

Approved: Safety Manager  
 Approved: Infection Control Officer  
 Approved: GEMS Coordinator

Approved: Service Chief  
 Approved: Chief of Staff  
 Approved: Associate Director

Drawing Title  
 PL-143-102  
 BLDG 143 SUB-BASEMENT PLUMBING PLAN  
 AREA "B" NEW WORK  
 Approved: Chief of Facility Management Svc.  
 Approved: Medical Center Director

Project Title  
 RENOVATE FOR WATER QUALITY  
 Building Number 143  
 Location VA MEDICAL CENTER, SALEM, VA 24153  
 Checked MJG  
 Drawn JFC

Date 04/28/2017  
 Project No. 658-15-101  
 DRAWING SET  
 2592  
 Dwg. 103 Of 155

Veterans Affairs