



three inches = one foot
 one and one-half inches = one foot
 one inch = one foot
 three-quarters inch = one foot
 one-half inch = one foot
 one-quarter inch = one foot
 one-eighth inch = one foot

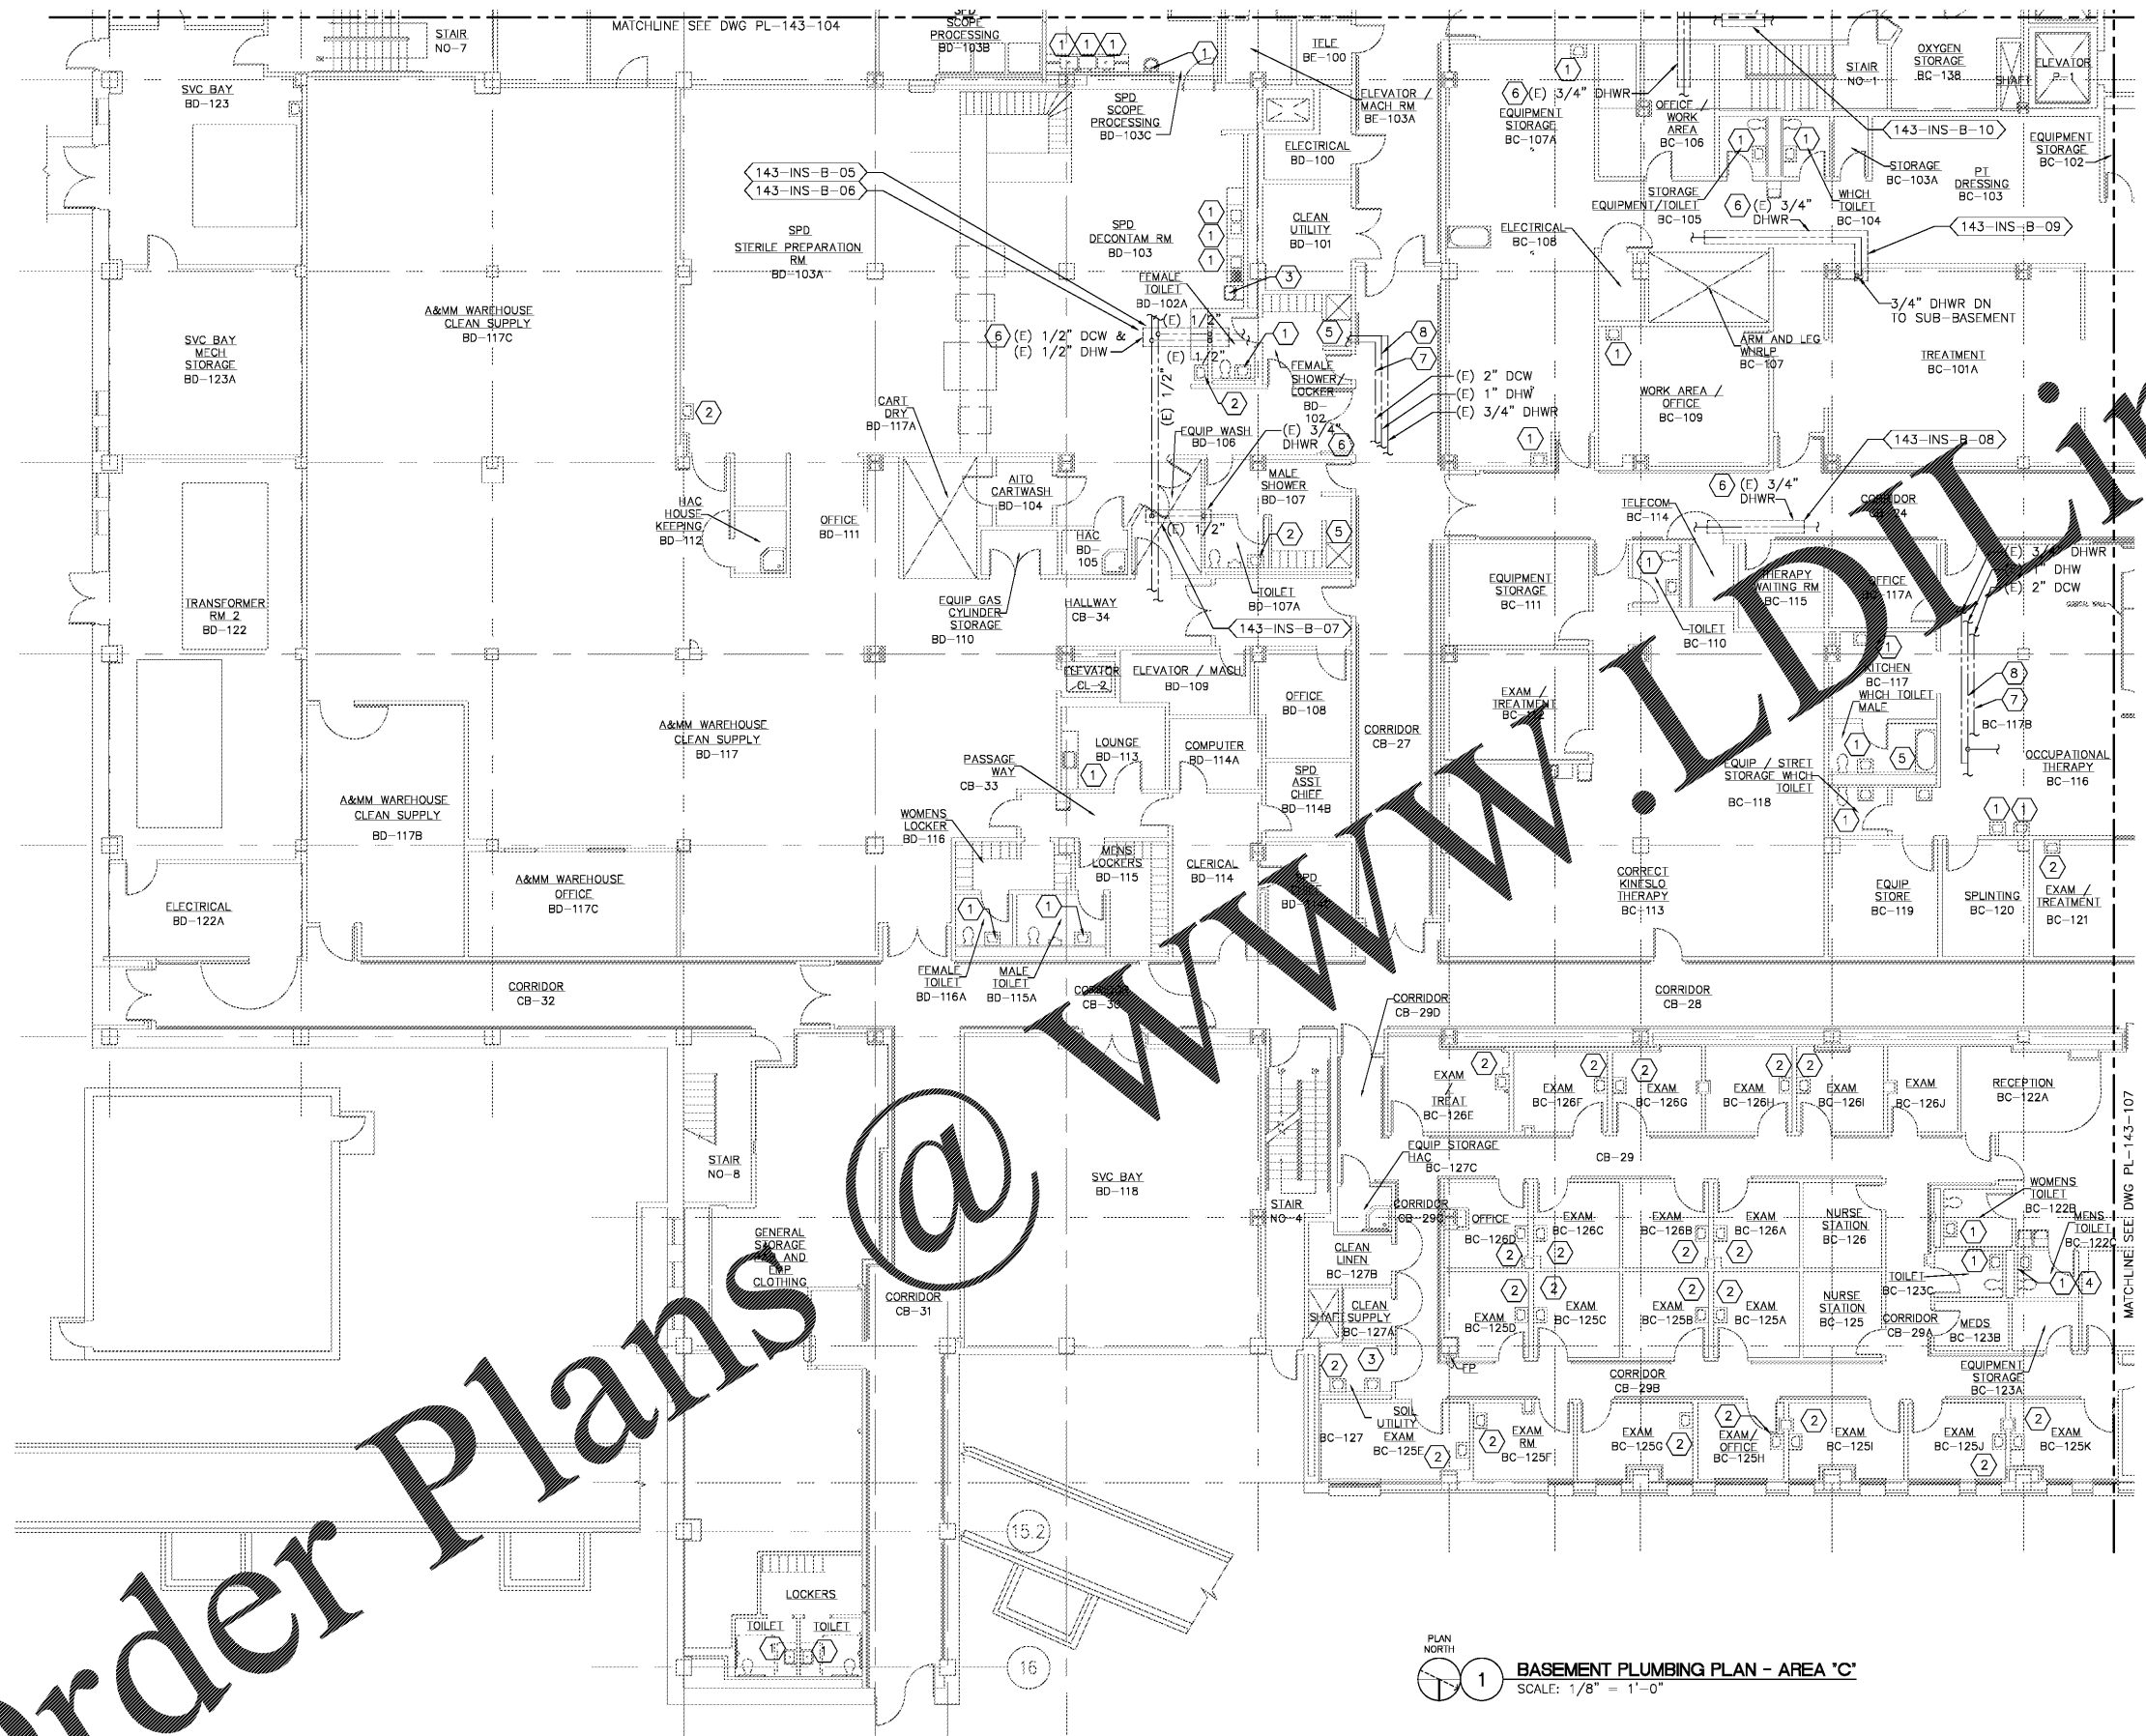

- CONSTRUCTION NOTES:**
- 1 PROVIDE THERMOSTATIC MIXING VALVE BELOW SINK/LAVATORY PER DETAIL 'C' ON DRAWING PL-501.
 - 2 PROVIDE THERMOSTATIC MIXING VALVE IN CEILING ABOVE SINK/LAV PER DETAIL 'D' ON DRAWING PL-501.
 - 3 PROVIDE THERMOSTATIC MIXING VALVE IN CEILING ABOVE CLINIC SINK FAUCET. MIXING VALVE SHALL SERVE CLINIC SINK FAUCET AND BEDPAN WASHER FOOT PEDAL PER DETAIL 'D' ON DRAWING PL-501.
 - 4 REMOVE FAUCET AERATOR AND PROVIDE LAMINAR FLOW OBJECT.
 - 5 REMOVE SHOWER VALVE AND PROVIDE THERMOSTATIC MIXING VALVE AND PRESSURE-BALANCING COMBINATION SHOWER VALVE. REMOVE AND REPLACE PORTION OF TILE WALL TO ALLOW INSTALLATION OF NEW SHOWER VALVE.
 - 6 INSULATE PIPING WITH FLEXIBLE EPOXY/OMERIC INSULATION.
 - 7 PROVIDE TEMPERATURE SENSOR IN DCW AND CONNECT TO DDC PANEL LOCATED IN SUB-BASEMENT MECH RM. REFER TO DWG PL-143-401.
 - 8 PROVIDE TEMPERATURE SENSOR IN DHW AND CONNECT TO DDC PANEL LOCATED IN SUB-BASEMENT MECH RM. REFER TO DWG PL-143-401.

PLAN NORTH
 1 BASEMENT PLUMBING PLAN - AREA 'C'
 SCALE: 1/8" = 1'-0"

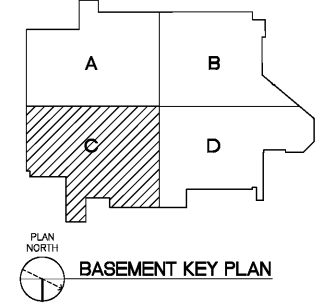

Order Plans @ www.wildfire.com

Revisions	Date

Atrix
 Atrix, plc
 102 3rd Avenue, NE
 PO Box 1628,
 Hickory, NC 28603
 Phone: 828.315.9962
 Fax: 828.315.9964
 www.atrigrp.com

Wiley Wilson
 Wiley Wilson
 127 Nantuxite Drive
 Lynchburg, VA 24502
 Phone: 434.947.1901
 www.wileywilson.com



Approved: Energy Engineer
 Approved: Safety Manager
 Approved: Infection Control Officer
 Approved: GEMS Coordinator

CONSTRUCTION DOCUMENTS

Approved: Service Chief
 Approved: Chief of Staff
 Approved: Associate Director

Drawing Title
 PL-143-106
 BLDG 143 BASEMENT PLUMBING PLAN
 AREA 'C' NEW WORK
 Approved: Chief of Facility Management Svcs.
 Approved: Medical Center Director

Project Title
 RENOVATE FOR WATER QUALITY
 Building Number
 143
 Location
 VA MEDICAL CENTER, SALEM, VA 24153

Date
 04/28/2017
 Project No.
 658-15-101
 DRAWING SET
 2592
 Dwg. 107 Of 155

Veterans Affairs