



Order Plans @ WWW.AJIDLINE.COM

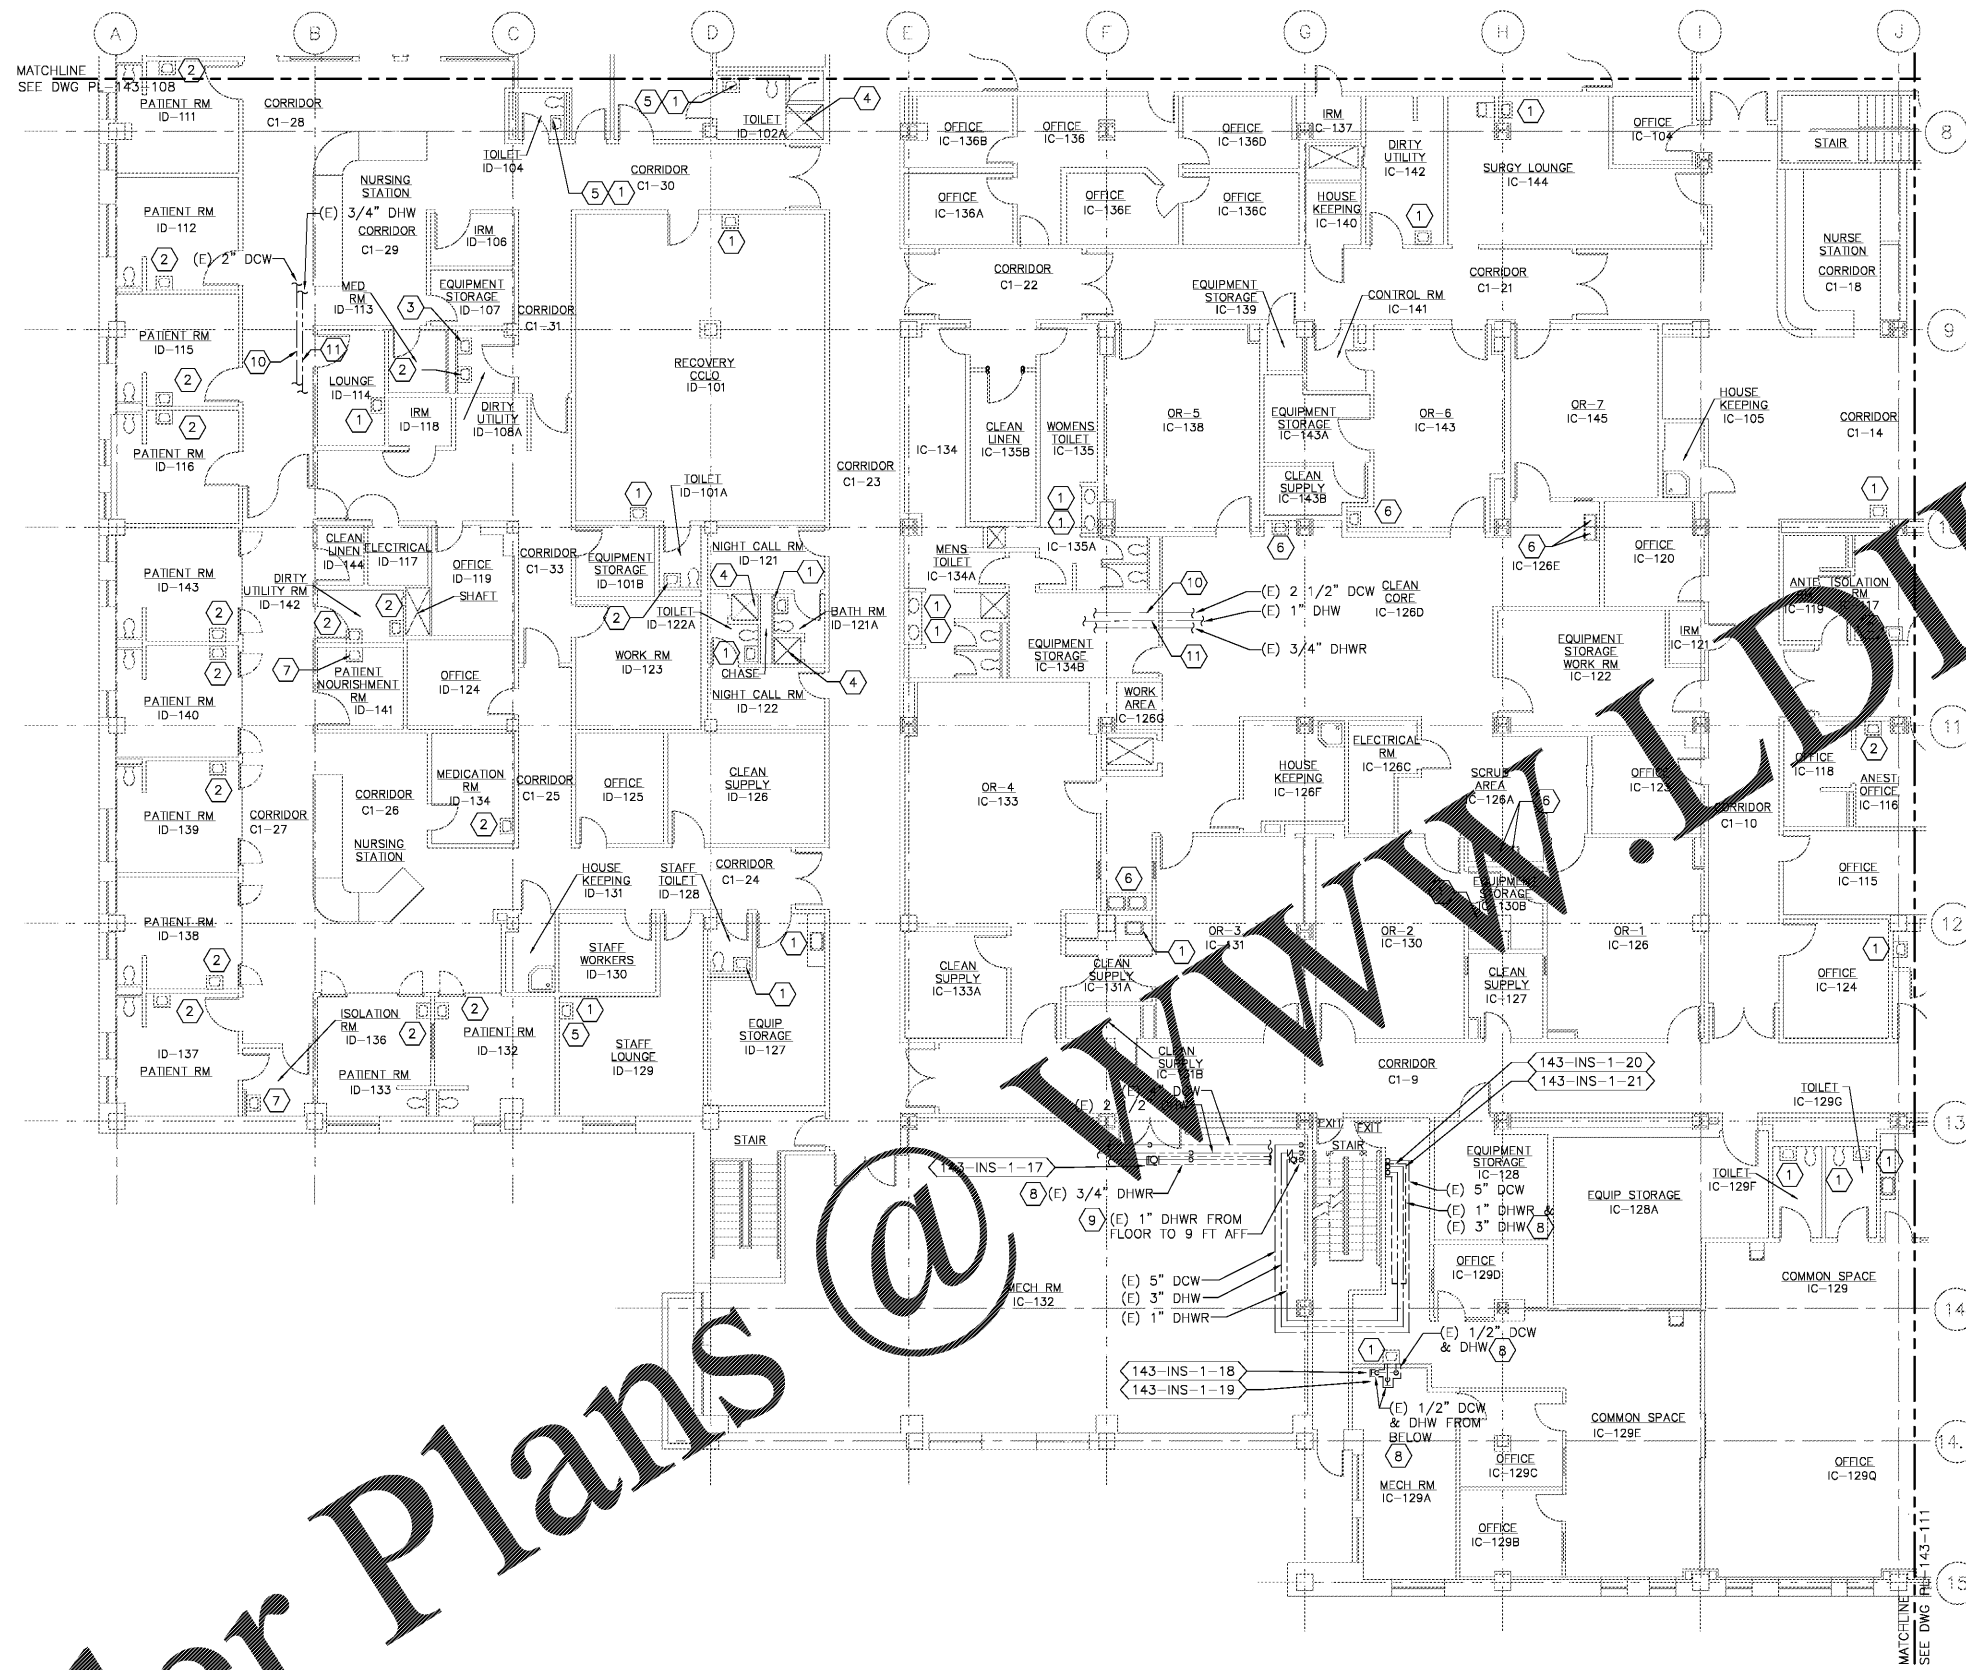

CONSTRUCTION NOTES:

- 1 PROVIDE THERMOSTATIC MIXING VALVE BELOW SINK/LAVATORY PER DETAIL 'C' ON DRAWING PL-501.
- 2 PROVIDE THERMOSTATIC MIXING VALVE IN CEILING ABOVE LAV PER DETAIL 'D' ON DRAWING PL-501.
- 3 PROVIDE THERMOSTATIC MIXING VALVE IN CEILING ABOVE CLINIC SINK FAUCET. MIXING VALVE SHALL SERVE CLINIC SINK FAUCET AND BEDPAN WASHER FOOT PEDAL PER DETAIL 'D' ON DRAWING PL-501.
- 4 REMOVE SHOWER VALVE AND PROVIDE ASSY. THERMOSTATIC AND PRESSURE-BALANCING COMBINATION SHOWER VALVE. REMOVE AND REPLACE PORTION OF TILE WALL TO ALLOW INSTALLATION OF NEW SHOWER VALVE.
- 5 REMOVE FAUCET AERATOR AND PROVIDE LAMP GLASS OUTLET.
- 6 PROVIDE THERMOSTATIC MIXING VALVE IN CEILING ABOVE KNEE OPERATED SURGEON'S SINK PER DETAIL 'D' ON DRAWING PL-501. PROVIDE 18" X 18" ACCESS DOOR TO EXPOSE WALL CEILING. PATCH AND PAINT TO MATCH EXISTING.
- 7 PROVIDE THERMOSTATIC MIXING VALVE IN CEILING ABOVE LAV PER DETAIL 'D' ON DRAWING PL-501. PROVIDE 18" X 18" ACCESS DOOR TO EXPOSE WALL CEILING. PATCH AND PAINT TO MATCH EXISTING.
- 8 INSULATE PIPING WITH FLEXIBLE ELASTOMERIC INSULATION.
- 9 REMOVE DAMAGED INSULATION AND REINSULATE PIPING WITH FLEXIBLE ELASTOMERIC INSULATION.
- 10 PROVIDE TEMPERATURE SENSOR IN DCW AND CONNECT TO DDC PANEL LOCATED IN SUB-BASEMENT MECH RM. REFER TO DWG. PL-143-401.
- 11 PROVIDE TEMPERATURE SENSOR IN DHW AND CONNECT TO DDC PANEL LOCATED IN SUB-BASEMENT MECH RM. REFER TO DWG. PL-143-401.

1 **FIRST FLOOR PLUMBING PLAN - AREA 'C'**
SCALE: 1/8" = 1'-0"

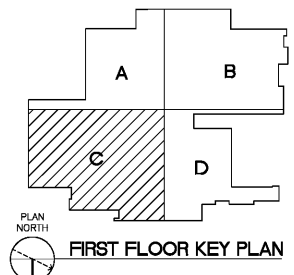

three inches = one foot
one and one-half inches = one foot
one inch = one foot
three-quarters inch = one foot
one-half inch = one foot
one-quarter inch = one foot
three-eighths inch = one foot
one-eighth inch = one foot

Revisions	Date

Atrix
Atrix, plc
102 3rd Avenue, NE
PO Box 1628,
Hickory, NC 28603
Phone: 828.315.9962
Fax: 828.315.9964
www.atrigroup.com

Wiley Wilson
Wiley Wilson
127 Nantowite Drive
Lynchburg, VA 24502
Phone: 434.947.1901
www.wileywilson.com



Approved: Energy Engineer	Approved: Safety Manager	Approved: Service Chief	Drawing Title	Project Title	Date
			PL-143-110 BLDG 143 FIRST FLOOR PLUMBING PLAN AREA 'C' NEW WORK	RENOVATE FOR WATER QUALITY	04/28/2017
	Approved: Infection Control Officer	Approved: Chief of Staff	Approved: Chief of Facility Management Svcs.	Building Number	Project No.
				143	668-15-101
	Approved: GEMS Coordinator	Approved: Associate Director	Approved: Medical Center Director	Checked	DRAWING SET
				MUG	2592
				Drawn	Dwg. 111 Of 155
				JFC	
				Location	
				VA MEDICAL CENTER, SALEM, VA 24153	

Veterans Affairs