



three inches = one foot
 one and one-half inches = one foot
 one inch = one foot
 three-quarters inch = one foot
 one-half inch = one foot
 three-eighths inch = one foot
 one-quarter inch = one foot
 one-eighth inch = one foot

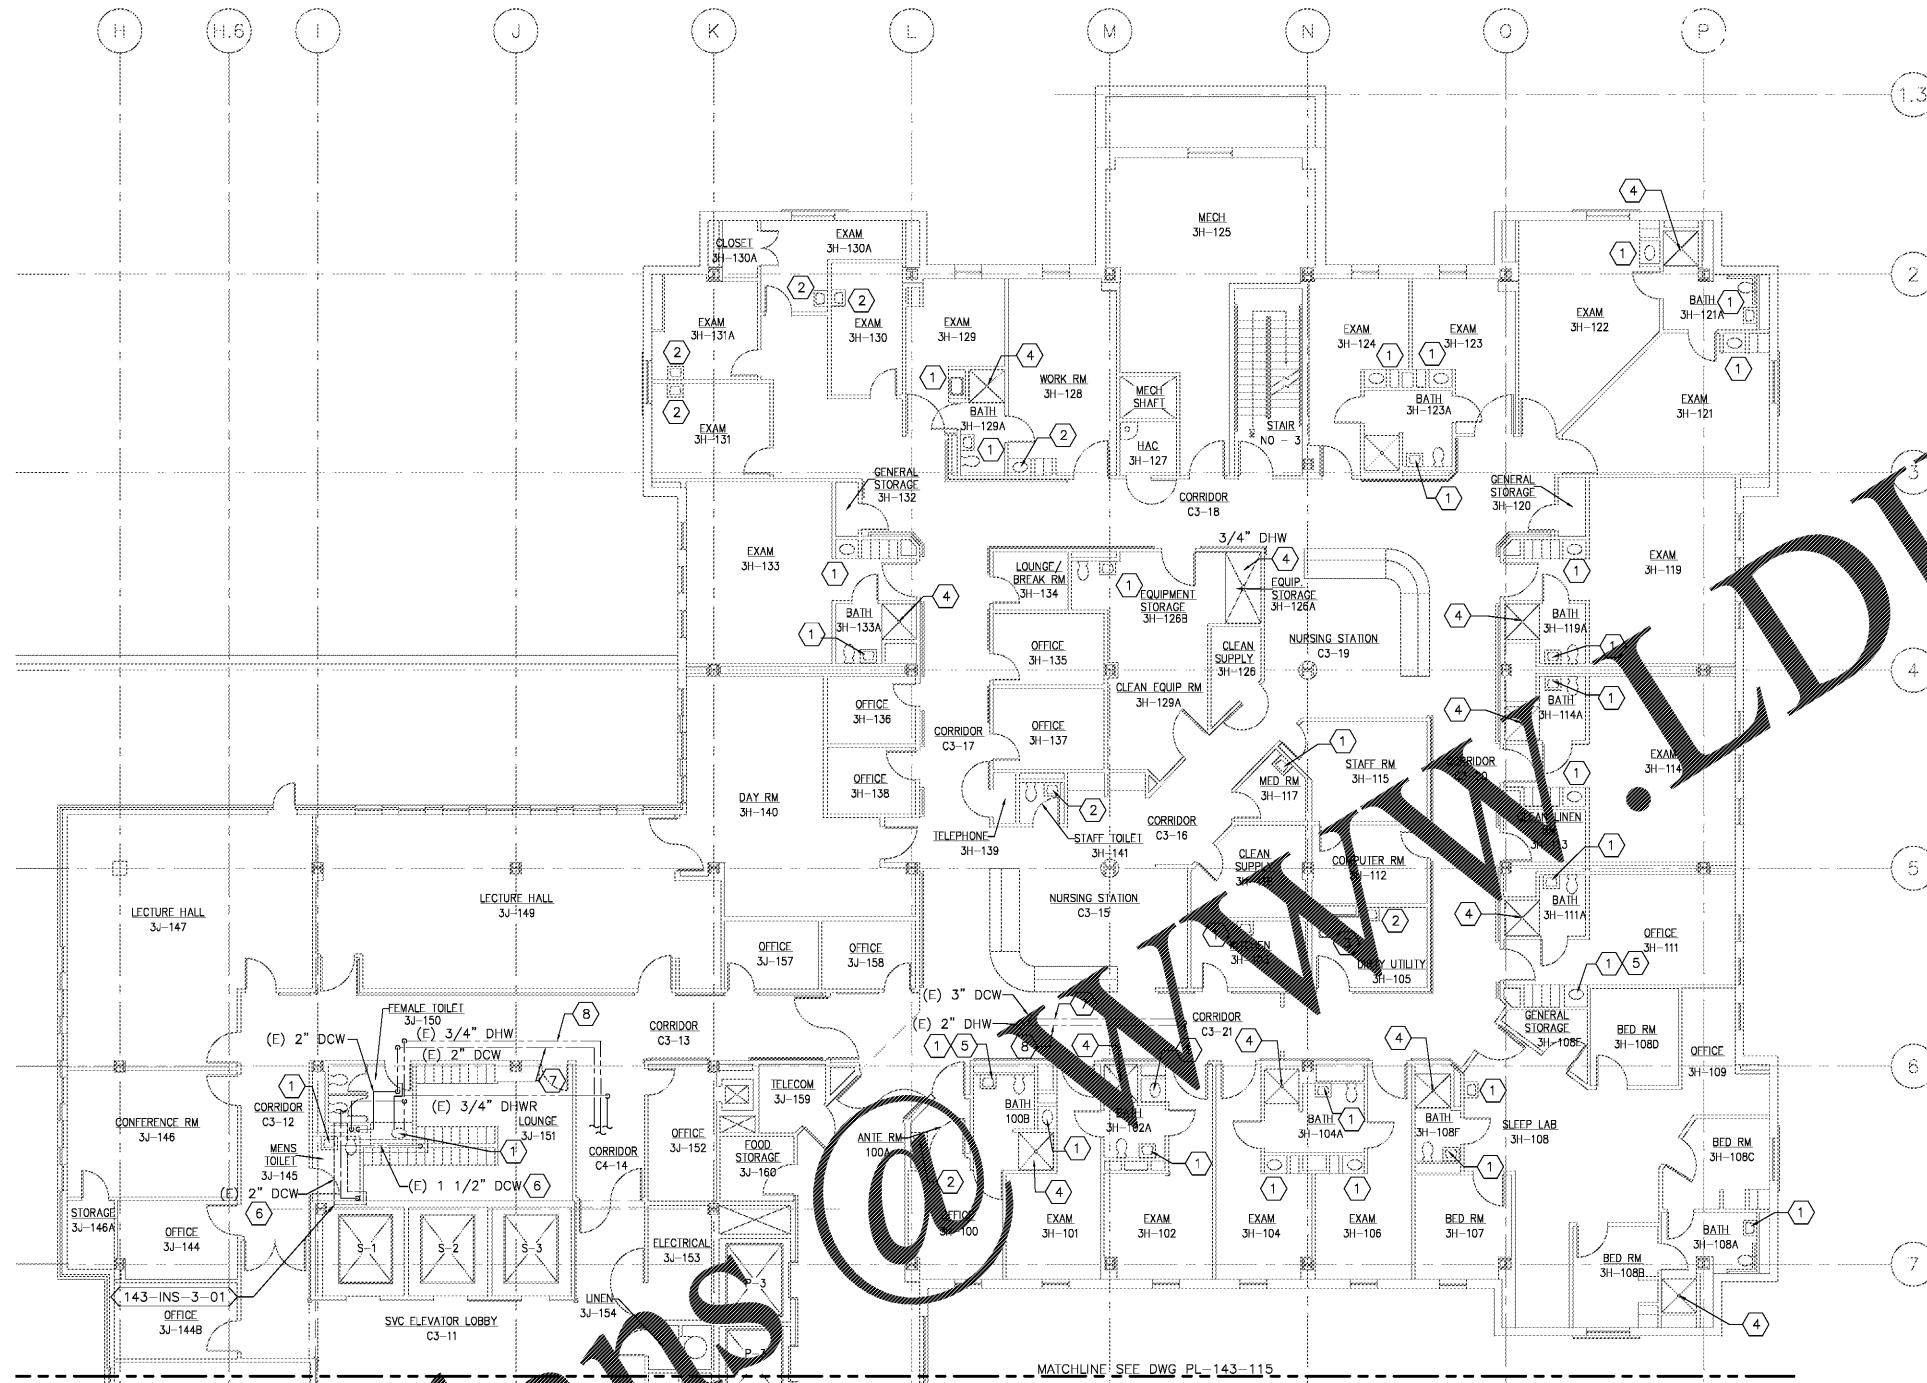

CONSTRUCTION NOTES:

- 1 PROVIDE THERMOSTATIC MIXING VALVE BELOW SINK/LAVATORY PER DETAIL 'C' ON DRAWING PL-501.
- 2 PROVIDE THERMOSTATIC MIXING VALVE IN CEILING ABOVE LAV PER DETAIL 'D' ON DRAWING PL-501.
- 3 PROVIDE THERMOSTATIC MIXING VALVE IN CEILING ABOVE CLINIC SINK FAUCET. MIXING VALVE SHALL SERVE CLINIC SINK FAUCET AND BEDPAN WASHER FOOT PEDAL PER DETAIL 'D' ON DRAWING PL-501.
- 4 REMOVE SHOWER VALVE AND PROVIDE ASSOCIATED THERMOSTATIC AND PRESSURE BALANCING COMBINATION SHOWER VALVE. REMOVE AND REPLACE PORTION OF TILE WALL TO ALLOW INSTALLATION OF NEW SHOWER VALVE.
- 5 REMOVE FAUCET AERATOR AND PROVIDE LAVATORY FLOW OUTLET.
- 6 INSULATE PIPING WITH FLEXIBLE ELASTOMERIC INSULATION.
- 7 PROVIDE TEMPERATURE SENSOR AND CONNECT TO DDC PANEL LOCATED IN SVC BAY 3H-118. SEE DWG. PL-143-115.
- 8 PROVIDE TEMPERATURE SENSOR IN DHW AND CONNECT TO DDC PANEL LOCATED IN SVC BAY 3J-118. SEE DWG. PL-143-115.


PLAN NORTH
 1 THIRD FLOOR PLUMBING PLAN - AREA 'A'
 SCALE: 1/8" = 1'-0"

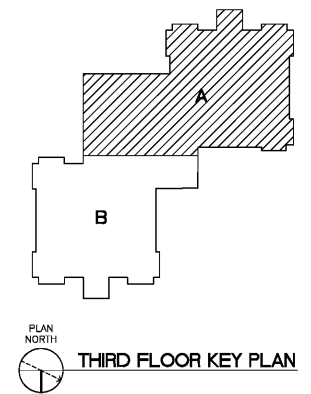

Order Plans

Revisions	Date

 Atrix , plc 102 3rd Avenue, NE PO Box 1628, Hickory, NC 28603 Phone: 828.315.9962 Fax: 828.315.9964 www.atrifaxgroup.com	 WileyWilson 127 Nationwide Drive Lynchburg, VA 24502 Phone: 434.947.1901 www.wileywilson.com
---	---

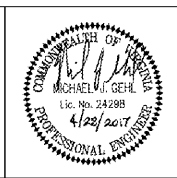

Approved: Energy Engineer	Approved: Safety Manager	Approved: Service Chief
	Approved: Infection Control Officer	Approved: Chief of Staff
CONSTRUCTION DOCUMENTS		
	Approved: GEMS Coordinator	Approved: Associate Director

Approved: Medical Center Director	Approved: Chief of Facility Management Svc.	Approved: GEMS Coordinator
-----------------------------------	---	----------------------------

Drawing Title PL-143-114 BLDG 143 THIRD FLOOR PLUMBING PLAN AREA 'A' NEW WORK	Project Title RENOVATE FOR WATER QUALITY
Approved: Chief of Facility Management Svc. Approved: Medical Center Director	Building Number 143
Approved: Medical Center Director	Location VA MEDICAL CENTER, SALEM, VA 24153

Date 04/28/2017	Project No. 658-15-101
Drawing Set 2592	
Dwg. 115 Of 155	Date 04/28/2017

Veterans Affairs