



three-eighths inch = one foot
 one-half inch = one foot
 one-quarter inch = one foot
 one-eighth inch = one foot
 one-sixteenth inch = one foot

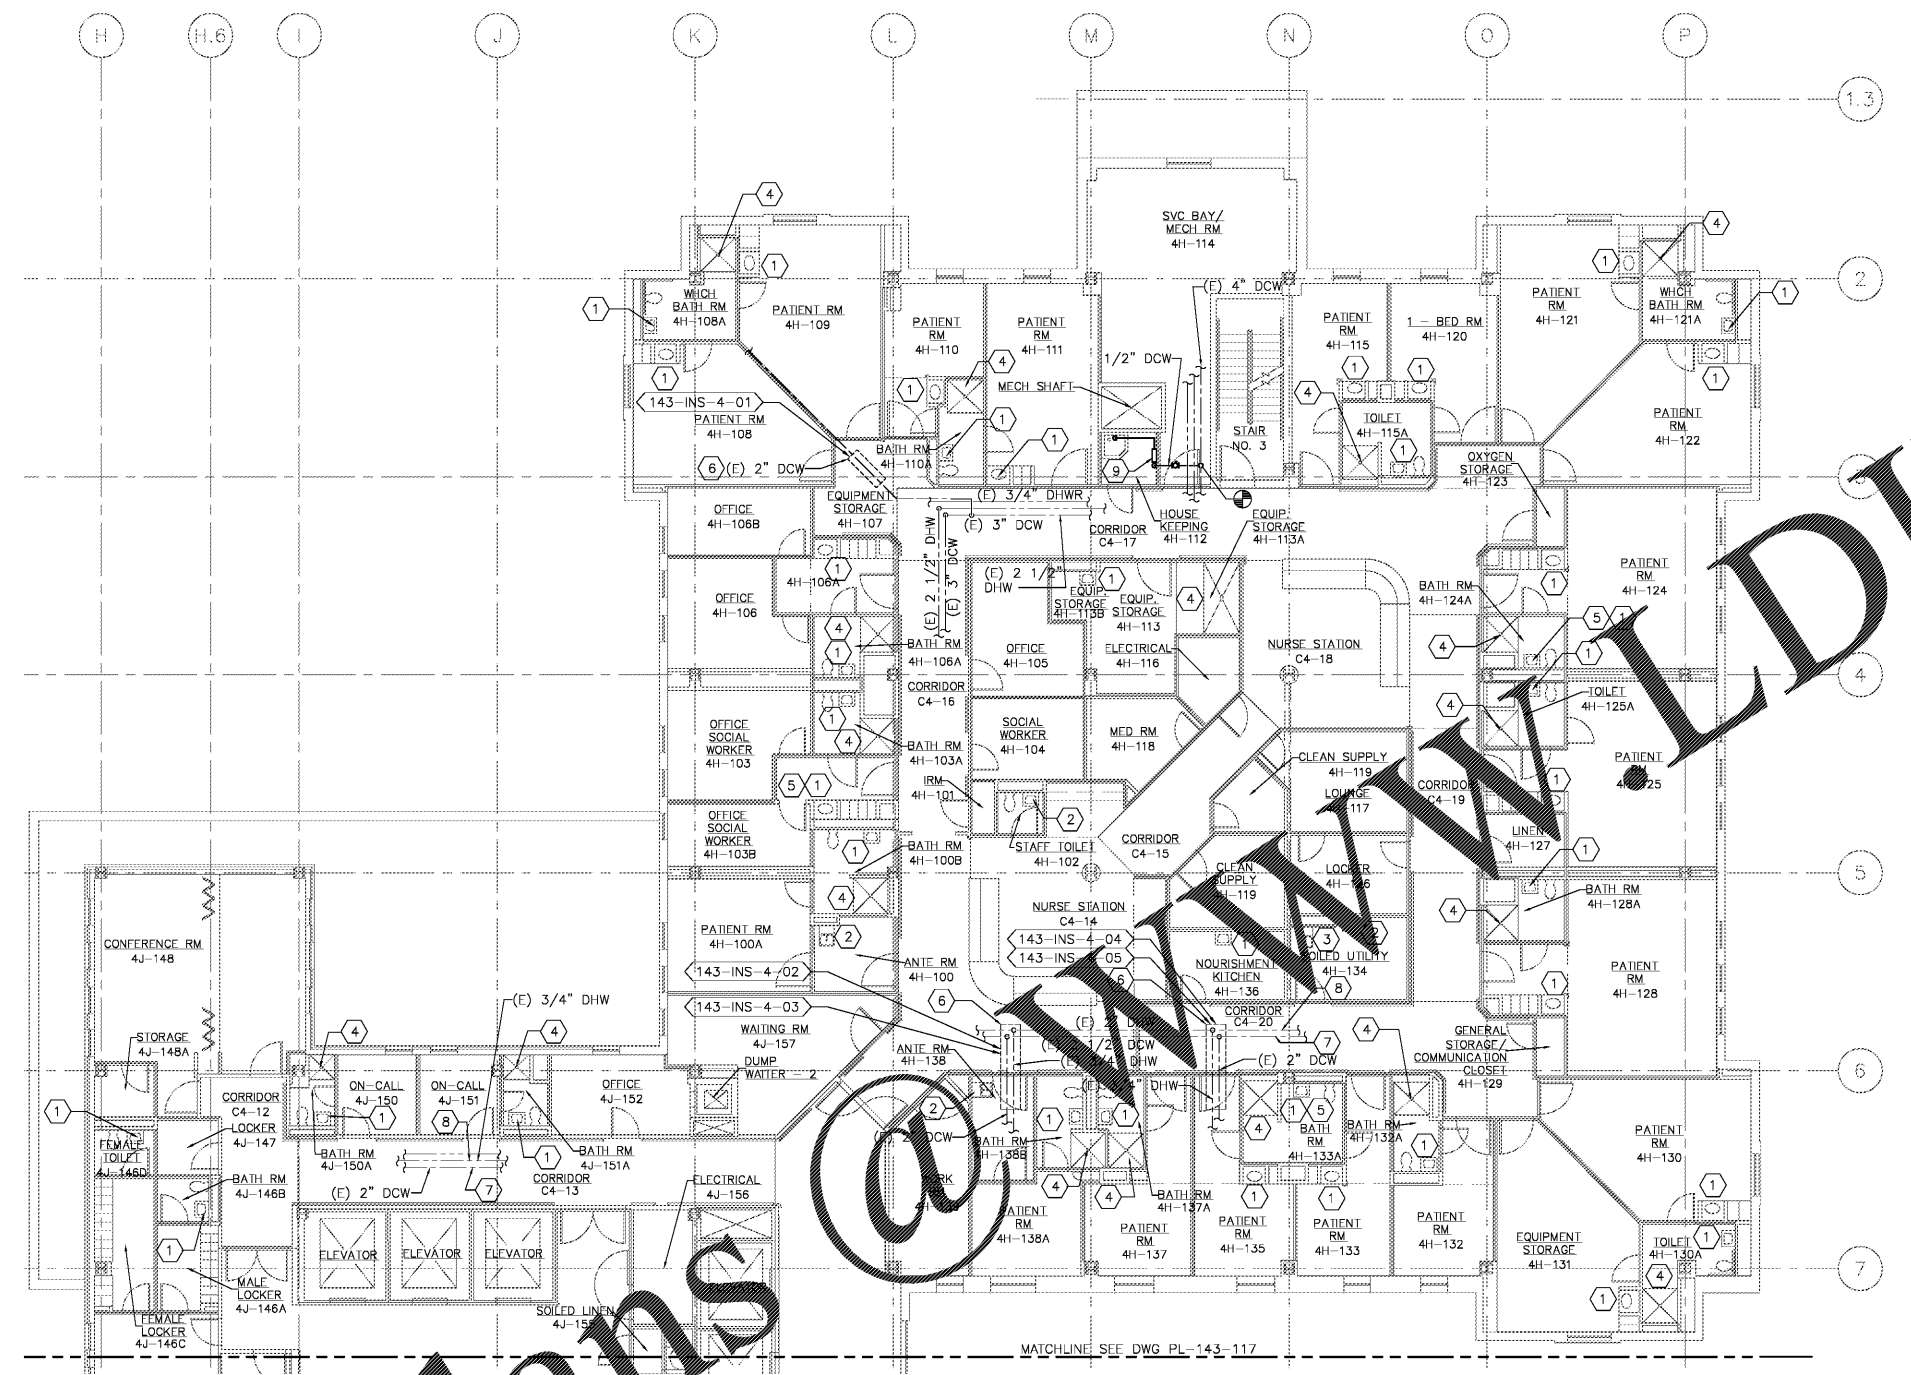

- CONSTRUCTION NOTES:**
- 1 PROVIDE THERMOSTATIC MIXING VALVE BELOW SINK/LAVATORY PER DETAIL 'C' ON DRAWING PL-501.
 - 2 PROVIDE THERMOSTATIC MIXING VALVE IN CEILING ABOVE LAV PER DETAIL 'D' ON DRAWING PL-501.
 - 3 PROVIDE THERMOSTATIC MIXING VALVE IN CEILING ABOVE CLINIC SINK FAUCET. MIXING VALVE SHALL SERVE CLINIC SINK FAUCET AND BLEAN WASHER FOOT PEDAL PER DETAIL 'D' ON DRAWING PL-501.
 - 4 REMOVE SHOWER VALVE AND PROVIDE ASSE 1016 THERMOSTATIC AND PRESSURE BALANCING COMBINATION SHOWER VALVE. REMOVE AND REPLACE PORTION OF TILE WALL TO ALLOW INSTALLATION OF NEW SHOWER VALVE.
 - 5 REMOVE FAUCET AERATOR AND PROVIDE LAMINAR FLOW AERATOR.
 - 6 INSULATE PIPING WITH FLEXIBLE ELASTOMERIC INSULATION.
 - 7 PROVIDE TEMPERATURE SENSOR IN DCW AND CONNECT TO DDC PANEL LOCATED IN SVC BAY 3J-118. SEE DWG. PL-143-115.
 - 8 PROVIDE TEMPERATURE SENSOR IN DHW AND CONNECT TO DDC PANEL LOCATED IN SVC BAY 3J-118. SEE DWG. PL-143-115.
 - 9 PROVIDE CHLORINE ANALYZER. CONNECT TO DDC PANEL LOCATED IN SVC BAY 3J-118. SEE DWG. PL-143-115. PROVIDE 1/2\"/>

PLAN NORTH
 1 FOURTH FLOOR PLUMBING PLAN - AREA 'A'
 SCALE: 1/8" = 1'-0"

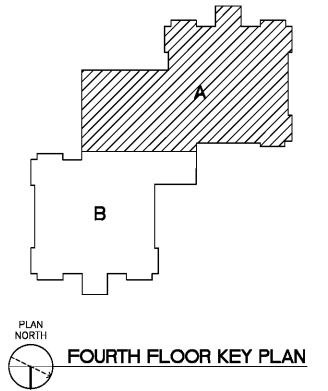

Order Plans

Revisions	Date

Atrix
 Atrix, plc
 102 3rd Avenue, NE
 PO Box 1628,
 Hickory, NC 28603
 Phone: 828.315.9962
 Fax: 828.315.9964
 www.atraxisgroup.com

Wiley Wilson
 Wiley Wilson
 127 Nantowite Drive
 Lynchburg, VA 24502
 Phone: 434.947.1901
 www.wileywilson.com



Approved: Energy Engineer	Approved: Safety Manager
Approved: Infection Control Officer	Approved: Chief of Staff
Approved: GEMS Coordinator	Approved: Associate Director

Approved: Service Chief	Approved: Chief of Facility Management Svcs.
Approved: Medical Center Director	

Project Title	Date
Building Number	Checked
Location	Drawn

Project Title	Date
Building Number	Checked
Location	Drawn

Project Title	Date
Building Number	Checked
Location	Drawn

Project Title	Date
Building Number	Checked
Location	Drawn

CONSTRUCTION DOCUMENTS

Veterans Affairs