


Symbol	Label	Qty	Catalog Number	Description	Lamp	Number Lamps	Lumens Per Lamp	LLF	Wattage
☐	P8	1	PRV-A25-D-UNV-T3-BZ	Single Head Eaton Preval Series LED Area Unit w/Type T3 Distribution (12ft. Pole Height w/3ft. Base)	87w of LED per Head (Type A40 Power Input)	2	5145	1	97
☐	P3-BLS	1	PRV-A25-D-UNV-T3-BZ-HSS	Single Head Eaton Preval Series LED Area Unit w/Type T3 Distribution (12ft. Pole Height w/3ft. Base) House Side Shield	87w of LED per Head (Type A40 Power Input)	2	4887	1	97
☐	P4-BLS	1	PRV-A25-D-UNV-T4-BZ-HSS	Single Head Eaton Preval Series LED Area Unit w/Type T4 Distribution (12ft. Pole Height w/3ft. Base) House Side Shield	87w of LED per Head (Type A40 Power Input)	2	4876	1	97



Description	Symbol	Avg	Max	Min	Max/Min	Avg/Min
Main Property Line Light Levels	+	0.0 fc	0.1 fc	0.0 fc	N/A	N/A
Parking Lot Light Levels	+	2.4 fc	5.5 fc	0.0 fc	N/A	N/A
Secondary Property Line Light Levels	+	0.0 fc	0.1 fc	0.0 fc	N/A	N/A

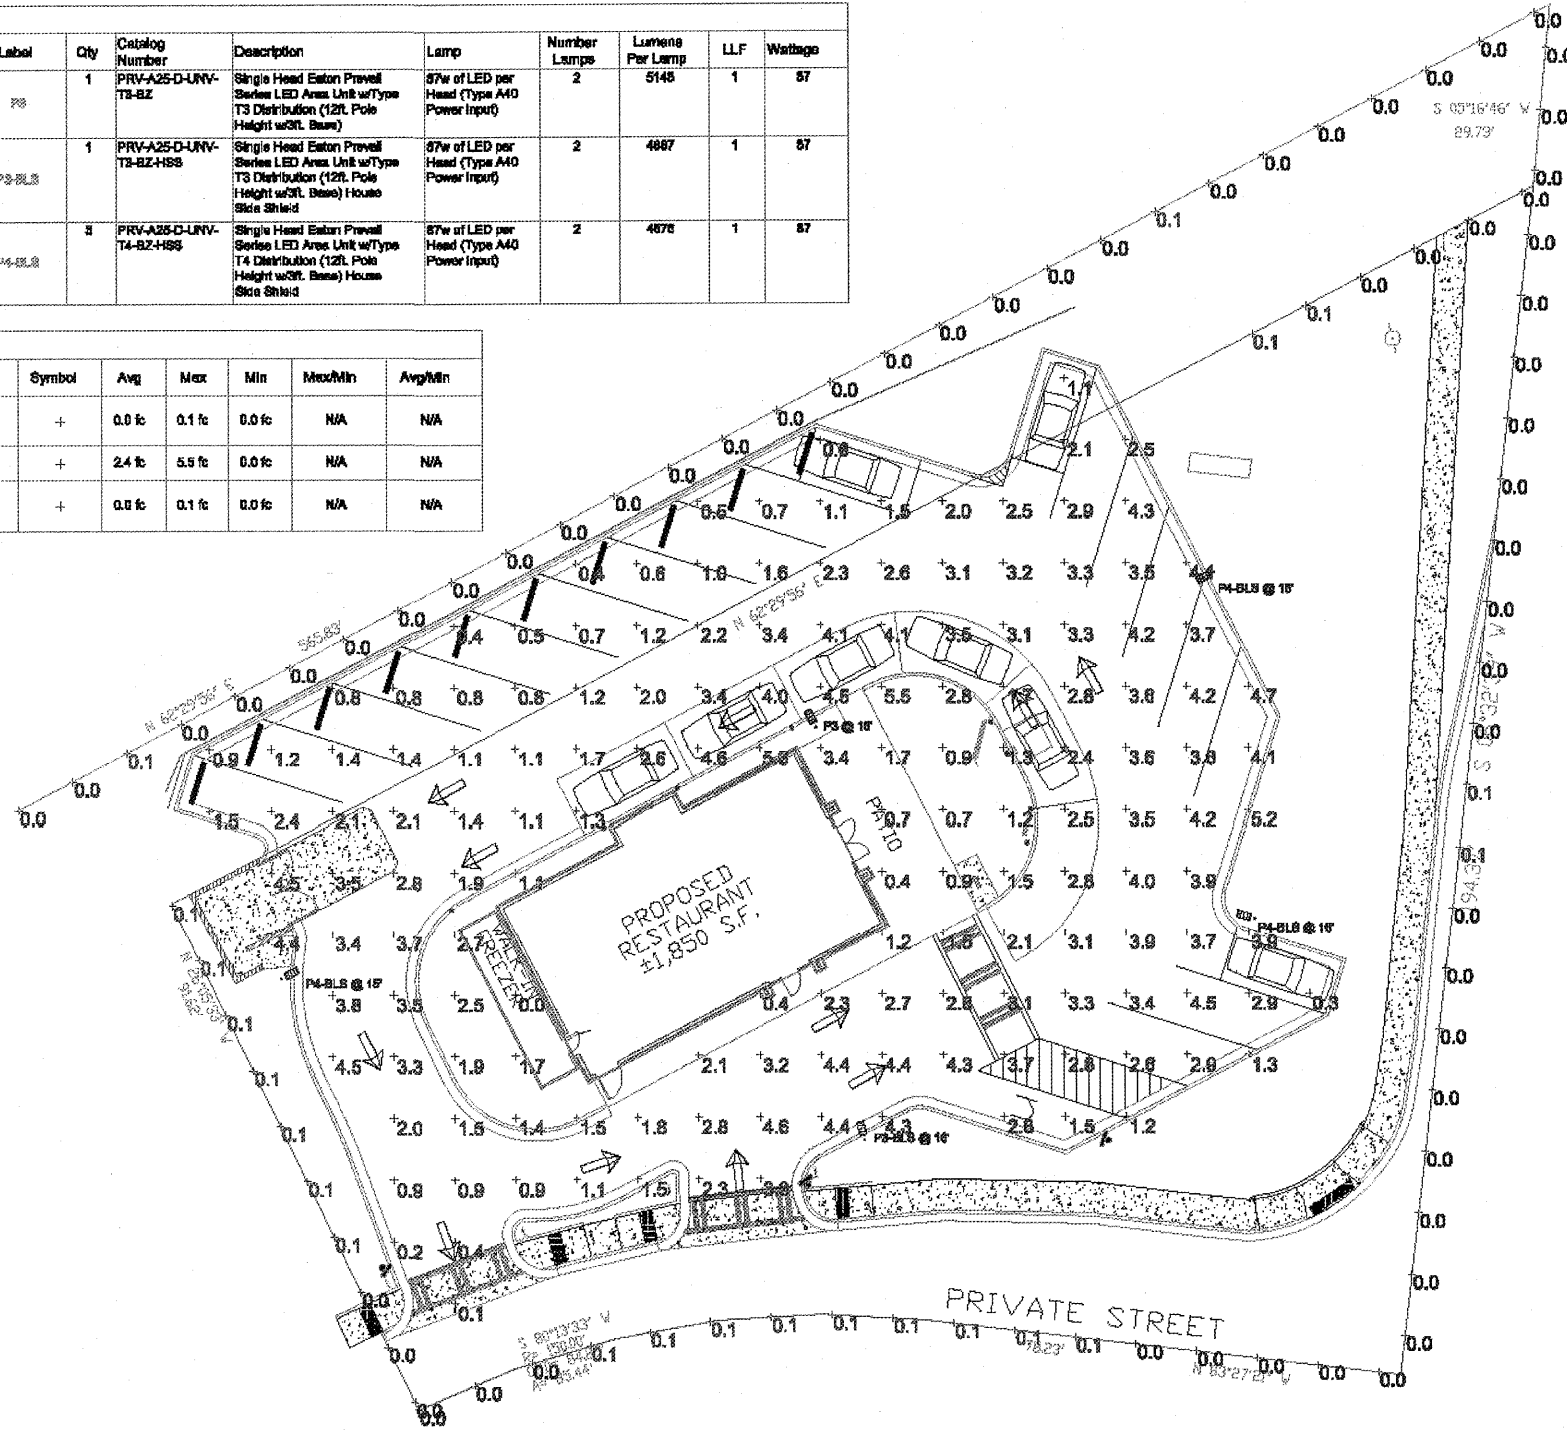

Dunkin' Donuts - Spring Hill, TN - Parking Lot Lighting Layout

Designer:  
Adrian Carter  
Eagle  
771922217  
Scale:  
Not to Scale  
Drawing No.  
Summary

1 of 2

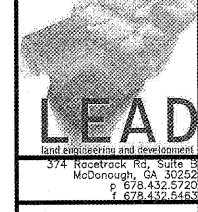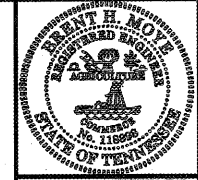

Lighting Plan Prepared For:  
**DUNKIN' DONUTS**

Developer:  
**SHULER DEVELOPMENT, LLC.**  
6406 POWERS FERRY RD  
SUITE 500  
ATLANTA, GA 30339  
770-303-8200

DATE	RELEASE DESCRIPTION
06-18-17	REVISED PER STAFF COMMENTS (06-16-17)
07-06-17	REVISED PER WORK SESSION COMMENTS (06-28-17)
07-07-17	REVISED PER CITY COMMENT
07-11-17	REVISED PER PLANNING COMMISSION COMMENTS

DATE: JUNE 11, 2017  
THIRD CIVIL DISTRICT  
A: Map 027, 30.06  
B: Map 027, 01.02  
CITY: SPRING HILL  
COUNTY: MAURY  
STATE: TENNESSEE  
JOB NUMBER:  
2016.095

14

14 OF 14 SHEETS

24-HR CONTACT  
ALLEN CURTIS  
770-303-8200



Lighting Plan