

OCCUPANCY LOAD CALCULATION						
Number	Name	Area	Type	Description	OLF	Load
100	SEATING AREA	272 SF	LSC - ASSEMBLY USE - More concentrated use - without fixed seats		15	19
100A	SEATING AREA	80 SF	LSC - ASSEMBLY USE - More concentrated use - without fixed seats		15	6
101	SALES AREA	310 SF	LSC - ASSEMBLY USE - Less concentrated use - without fixed seats		15	18
102	SERVICE AREA	335 SF	LSC-KITCHEN		100	4
103	VESTIBULE	30 SF	(none)			
104	MENS	44 SF	(none)			
105	WOMENS	45 SF	(none)			
106	KITCHEN	504 SF	LSC-KITCHEN		100	6
107	OFFICE	26 SF	LSC-BUSINESS		100	1
WC-1	WALK IN COOLER	54 SF	(none)			
WF-1	WALK IN FREEZER	85 SF	(none)			

TOTAL OCCUPANCY : 54 PERSONS


LIFE SAFETY LEGEND

- EXIT ACCESS TRAVEL DISTANCE
- - - - - EXIT SEPERATION DISTANCE
- MAXIMUM DIAGONAL LENGTH

- CEILING MOUNTED LED EXIT LIGHT WITH BATTERY BACK UP AND EMERGENCY LIGHTS
- WALL MOUNTED LED EMERGENCY LIGHTS WITH BATTERY BACK UP
- F.E. = FIRE EXTINGUISHER CABINET

SPECIAL OVEN/HOOD NOTE:
 OVENS ARE FOR FINAL WARMING / BAKING OF FOOD PRODUCTS. NO GREASE / COOKING TAKES PLACE IN THE KITCHEN. A TYPE I GREASE HOOD WITH SUPPRESSION SYSTEM IS NOT REQUIRED. TYPE II HOOD IS FOR HEAT REMOVAL ONLY. REFER TO MECHANICAL PLANS FOR HOOD DETAILS

FIRE EXTINGUISHER CABINET NOTE:
 4A-40BC: Larsen's "MP-10" in a "B-2409-R4" cabinet.
 K: "WC-2 1/2" extinguisher in a B 2712-RL" cabinet

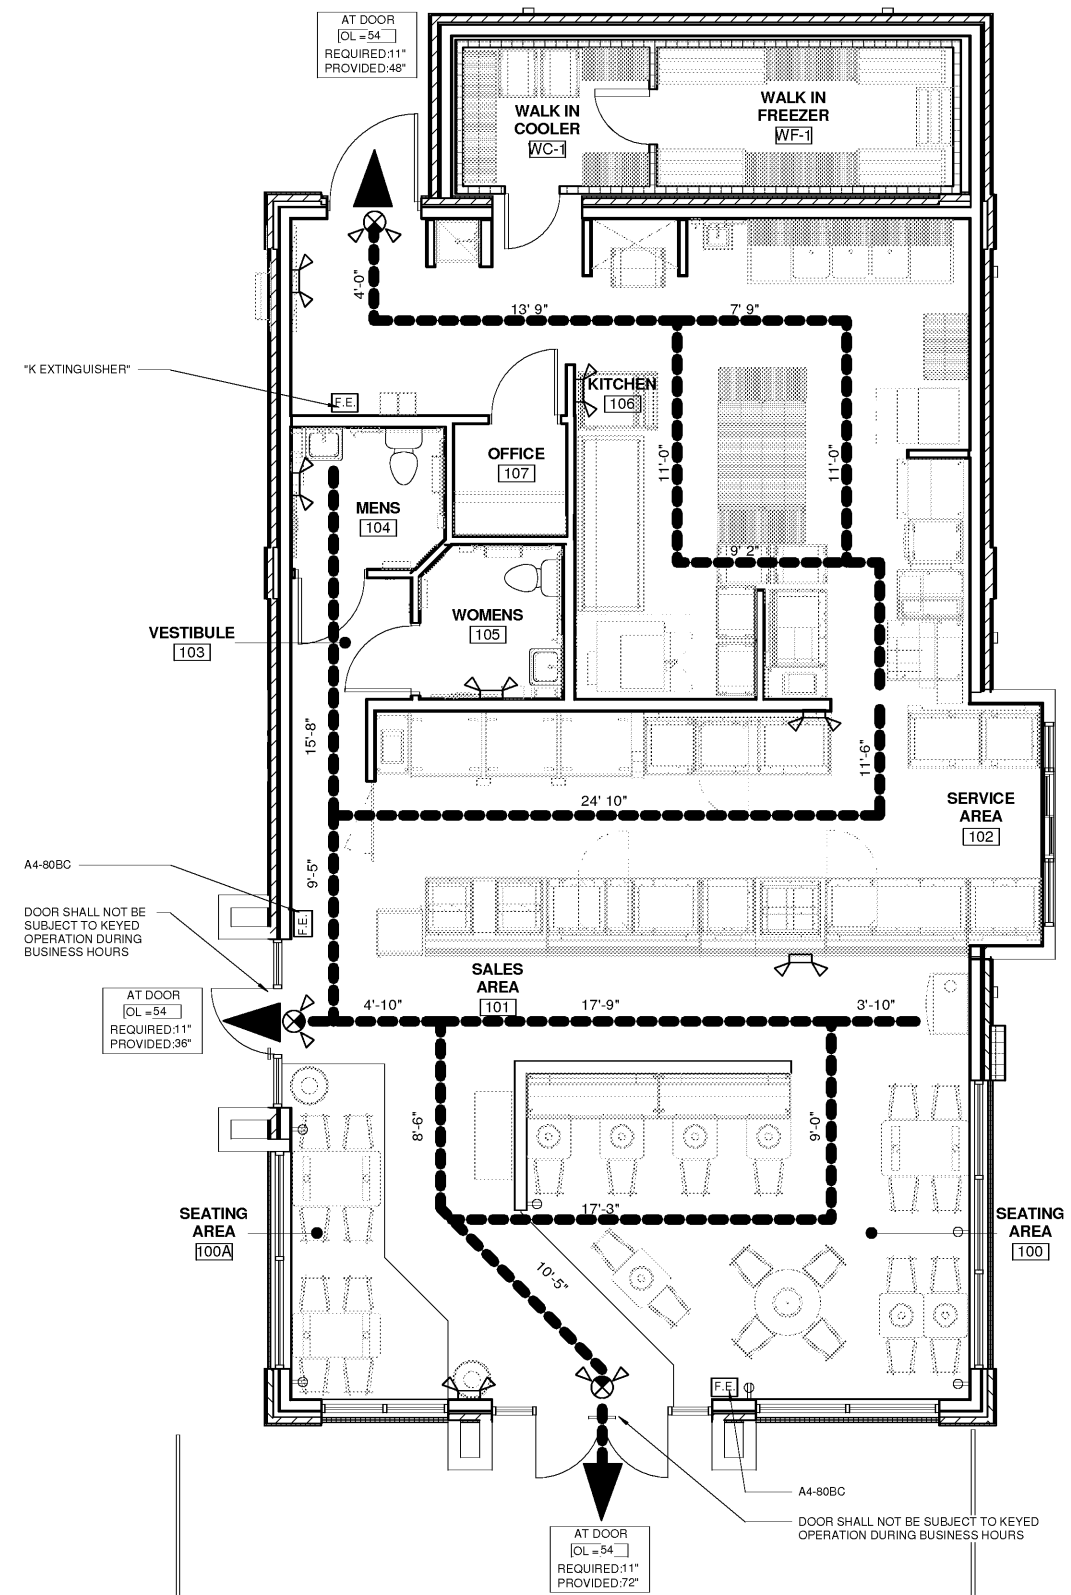


1 FIRST FLOOR - NEW WORK - LIFE SAFETY
 A0.8 1/4" = 1'-0"




RELEASED FOR CONSTRUCTION

No.	Date	Description

This Drawing and all associated designs are the property of COPELAND ARCHITECTURE and shall be returned upon completion of work. Use or copy is permitted by contract only. Unauthorized use will be prosecuted.

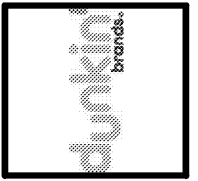

A NEW DARK ROAST STORE
 DUNKIN' DONUTS
 for
 SHULER DEVELOPMENT
 STORE 357147
 4880-4890 PORT ROYAL ROAD
 SPRING HILL, TN 37174

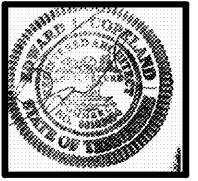

LIFE SAFETY PLAN
 EDWARD L. COPELAND, AIA
 4511 CHAMBLEE DUNWOODY ROAD, SUITE E.1
 ATLANTA, GEORGIA 30338
 PH. 770.551.9525 FAX 770.551.9524
 WWW.COPELANDARCHITECTURE.COM

DRAWN BY: RMG
 CHECKED BY: ELC
 DATE: 07/07/17
 SCALE: AS NOTED
 C.A. COMMISSION NUMBER 1704
 SHEET NAME LIFE SAFETY PLAN

SHEET NUMBER
A0.8