



CITY OF TAMPA
 CONTRACT ADMINISTRATION
 DEPARTMENT
 PLANNING AND DESIGN DIVISION
 205 E. JACKSON STREET, 4th NORTH
 TAMPA, FLORIDA 33602
 P: 813.274.8455 - F: 813.274.8080
 WWW.TAMPA.GOV

James E. Jackson, Jr. AIA, NOMA
 City Architect
 Edward D. Rice, AIA
 Project Architect
 Kevin L. Hurdall, AIA
 Project Architect
 Thomas A. Hester, Sr., AIA, NOMA
 Project Architect
 Kasey C. Tillman
 Drafting Technician
 Jerry P. Sanders
 Drafting Technician
 Byron K. Thomas, LEED AP
 Drafting Technician

MEP CONSULTANT
 GRINER ENGINEERING, INC.
 1628 1st. AVENUE NORTH
 ST. PETERSBURG, FL 33713

STRUCTURAL CONSULTANT
 BILLER REINHART
 STRUCTURAL GROUP, INC.
 4014 GUNN HWY. SUITE 240
 TAMPA, FL 33613

CIVIL CONSULTANT
 5 M CIVIL LLC
 12315 WYCLIFF PLACE
 TAMPA, FL 33626

LANDSCAPE CONSULTANT
 DAVID CONNER & ASSOCIATES
 1509 W. SWANN AVENUE, SUITE 255
 TAMPA, FL 33606

FIRE STATION 23
 20770 TROUT CREEK DR.
 TAMPA, FL 33647

DPW FILE NUMBER

DPW NUMBER
 17-C-00037

ISSUE DATE
 JULY 28, 2017

DRAWN BY
 KINBEY TILLMAN

REVISIONS

▲	
▲	
▲	

SEAL

SCALE VARIES

SHEET NUMBER

A-2.1

X OF X


GENERAL NOTES

- ALL WINDOWS TO RECEIVE HORIZONTAL BLINDS - SEE SPECIFICATIONS FOR REQUIREMENTS

KEY NOTES

- 5/8" GYPSUM BOARD ON 3/4" FURRING CHANNELS OVER 3/4" RIGID INSULATION AND 8" CMU
- 3/4" CEMENT PLASTER WITH SAND FINISH
- ACOUSTICAL BATT INSULATION
- EXPOSED 8" CMU, PROVIDE FLUSH JOINTS, PAINTED
- 5/8" GYPSUM BOARD PROVIDE 5/8" MOISTURE RESISTANT GYPSUM BOARD IN ALL RESTROOMS, JANITOR CLOSET AND KITCHEN AREAS
- 3-5/8" METAL STUDS AT 16" O.C.
- 6" METAL STUDS AT 16" O.C.
- SEMI-RECESSED FIRE EXTINGUISHER CABINET AND FIRE EXTINGUISHER
- DRYER - WASHING MACHINE ANCHORED TO FLOOR
- CONCRETE SIDEWALK - SEE CIVIL DRAWINGS & SITE PLAN FOR SCORING
- CONCRETE DRIVE - SEE CIVIL DRAWINGS
- PROVIDE 5/8" TYPE X GYPSUM BOARD FOR PARTITION TYPES P - 2A & P - 3A
- REFRIGERATOR
- ICE MACHINE
- FLOOR DRAIN - SEE PLUMBING PLANS
- LOUVER - SEE MECHANICAL DUGS FOR LOCATIONS AND SIZES
- TOP OF PARTITION P-1A AT 7'2" AFF. PROVIDE 1 x 6 S4S OAK WOOD CAP
- CREATE DOOR JAMBS BY EXTENDING 6" OF PARTITION WALL UP TO 7'-0" AFF. PROVIDE ROD AND CURTAIN TIE AS INDICATED ON TOILET ACCESSORIES. TYP. AT EACH OPENING. STIFFEN JAMBS WITH 1/2" x 4" STUD AND 2 METAL STUDS EACH SIDE. W/ 3'-0" OPENING
- 6" SIDEWALK & 5" SIDEWALK ALONG WEST SIDE. PROVIDE CONTROL JOINTS AT 5' O.C. & EXPANSION JOINTS AT 25' O.C. - VERIFY IN FIELD FOR EXACT LOCATIONS.
- THIN SET STONE WITH WAINSCOT CAP COORDINATE WITH EXTERIOR ELEVATIONS FOR ALL LOCATIONS
- TABLE SHOWN FOR CLARITY
- SEE ELEVATIONS AND SECTIONS FOR CEMENT PLASTER LOCATIONS
- 5" SIDEWALK WITH CONTROL JOINTS AT 5' O.C. AND EXPANSION JOINTS AT 25' O.C. PROVIDE MEDIUM BRONZ FINISH WITH 3" SMOOTH KNOBLE EDGE AND BRONZ FINISH CHECKERBOARD. COORDINATE IN FIELD WITH CITY OF TAMPA, ARCHITECT.
- 6" DIA. CONC. FILLED PIPE BOLLARD SET IN CONC. - SEE DETAIL THIS SHT.
- GENERAL STORAGE CLOSET - PAINTED TO MATCH SPACE
- SHIFT STORAGE CLOSET - PAINTED TO MATCH SPACE
- CONTROL JOINTS
- EXPANSION JOINTS
- 1'-0" x 4'-0" - 1/4" LEVEL BED CAST IN STAINLESS STL. GRILL W/ STAINLESS STL WIFE OFF MAT. SIMILAR TO BABCOCK DAVIS #8GRILL MODEL BFB381BC. WWW.BABCOCKDAVIS.COM | 888-412-3726
- 3'-0" x 1'-0" ALUMINUM SCREEN DOOR AND SIDE PANEL. SIMILAR OR EQUAL TO SCREEN TIGHT SYSTEM. WWW.SCREENTIGHT.COM | 800-768-1325
- 4'-0" x 1'-4" ALUMINUM SCREEN WITH FRAME. SIMILAR OR EQUAL TO SCREEN TIGHT SYSTEM. WWW.SCREENTIGHT.COM | 800-768-1325
- 4'-6" L x 3'-4" W MATRAC WITH VINYL ADHESIVE TREAD SIMILAR TO babcockdavis BMT386 WITH SURFACE MOUNTING FRAME BTF386A1. WWW.BABCOCKDAVIS.COM | 888-412-3726
- 1'-0" L x 4'-0" W MATRAC WITH VINYL ADHESIVE TREAD SIMILAR TO babcockdavis BMT386 WITH SURFACE MOUNTING FRAME BTF386A1. WWW.BABCOCKDAVIS.COM | 888-412-3726


INFORMATION PLAN

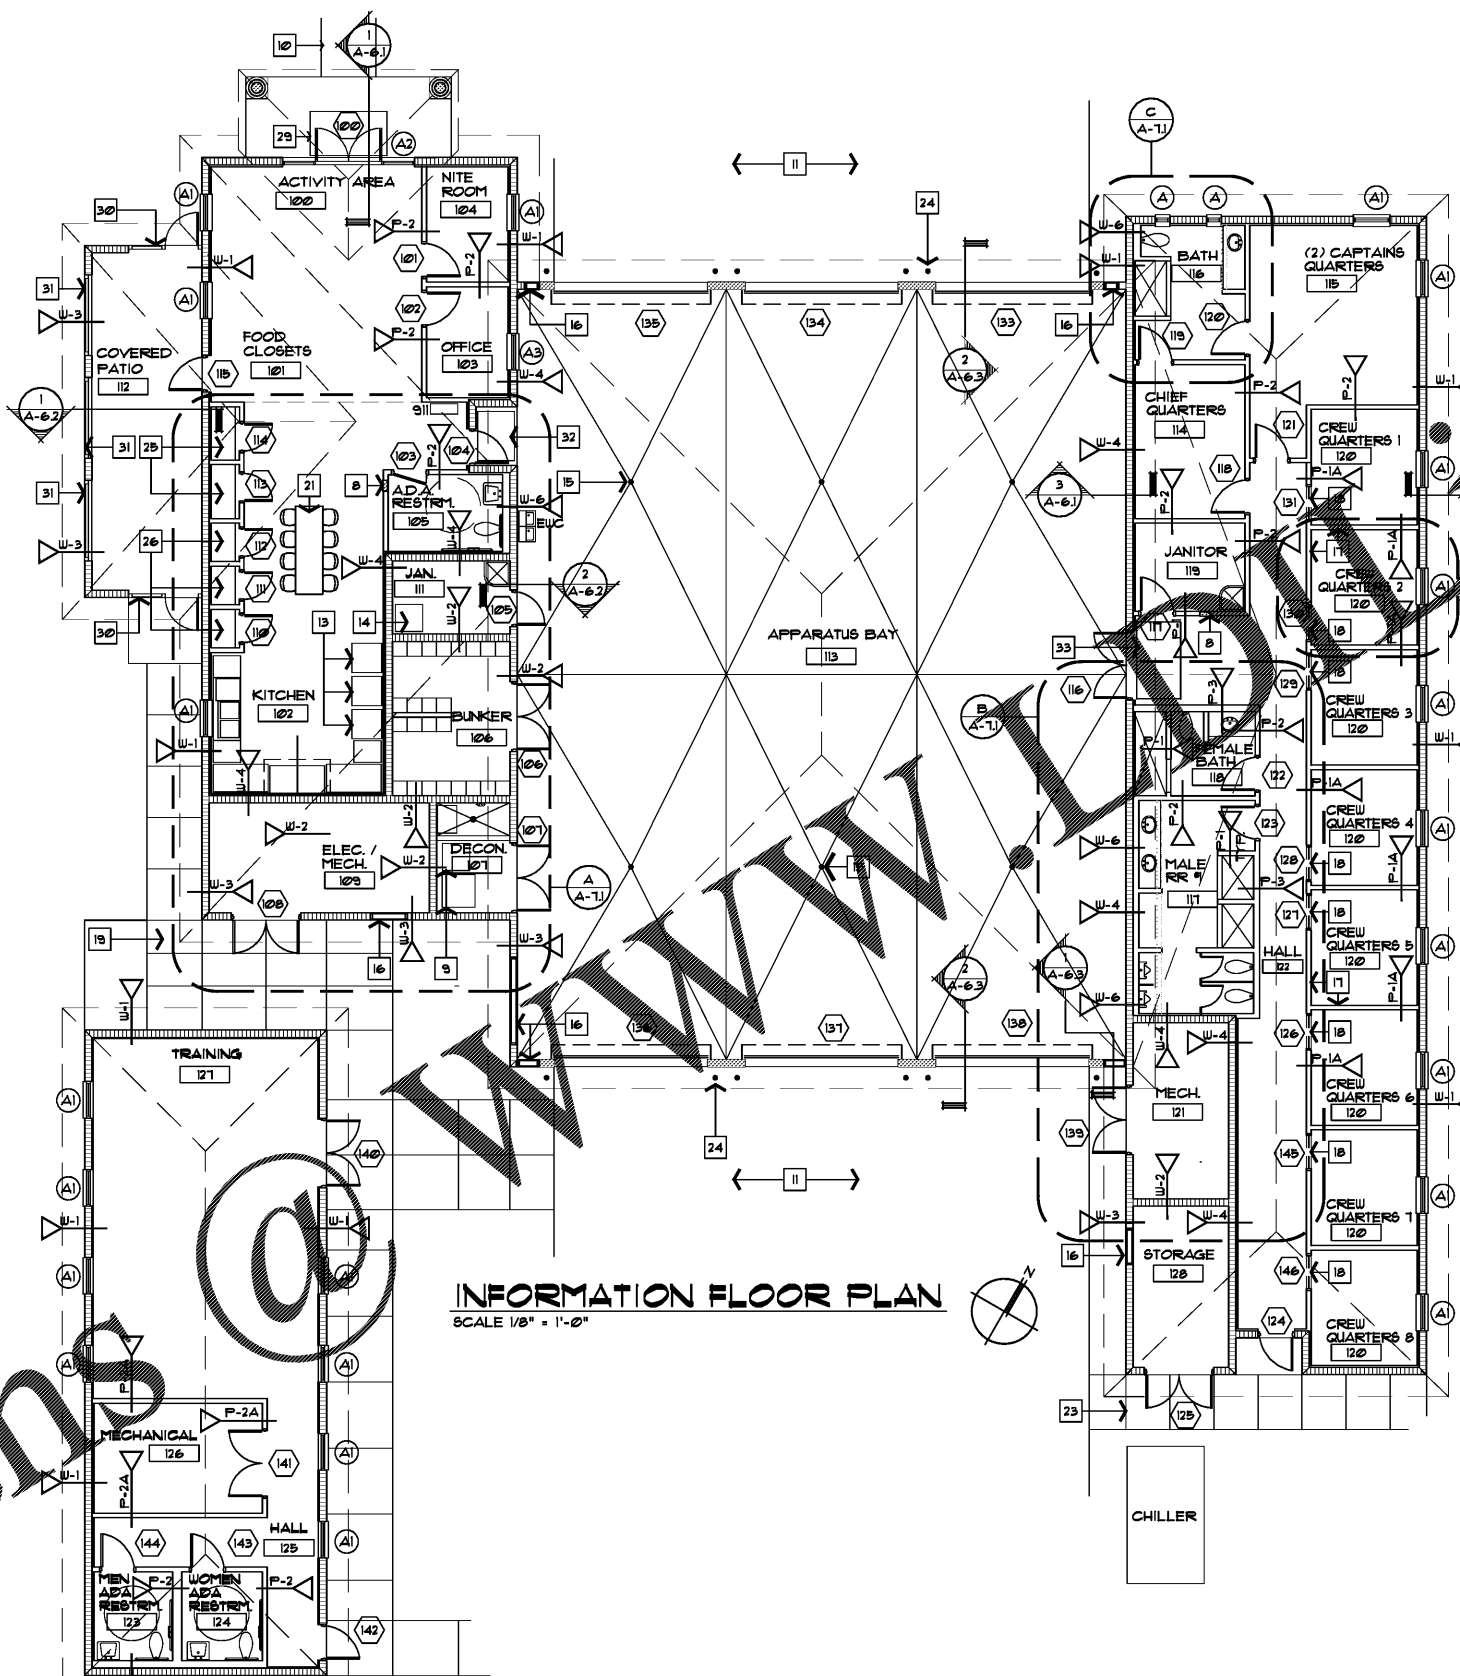


INFORMATION FLOOR PLAN
 SCALE 1/8" = 1'-0"




W-5 WALL TYPE
 SCALE 1/2" = 1'-0"

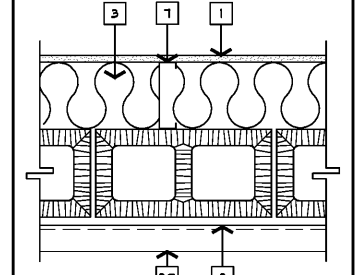


W-6 WALL TYPE
 SCALE 1/2" = 1'-0"

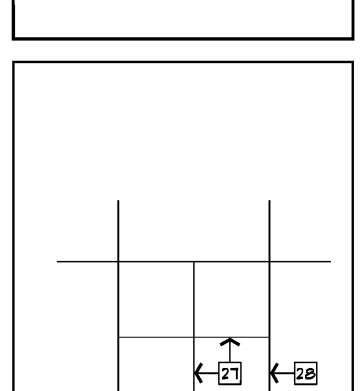


APRON PANEL DETAIL

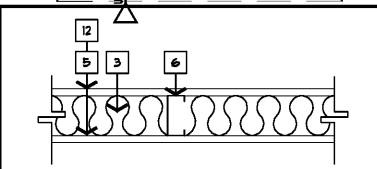


P-2A - 1 HR. RATED U486 PART. TYPE
 SCALE 1/2" = 1'-0"

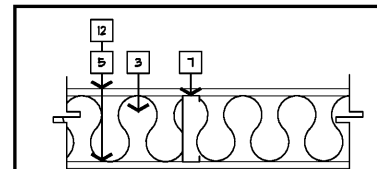


P-3A - 1 HR. RATED U486 PART. TYPE
 SCALE 1/2" = 1'-0"

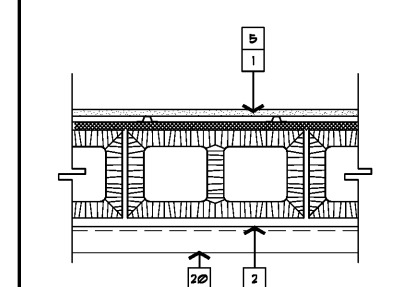


W-1 WALL TYPE
 SCALE 1/2" = 1'-0"

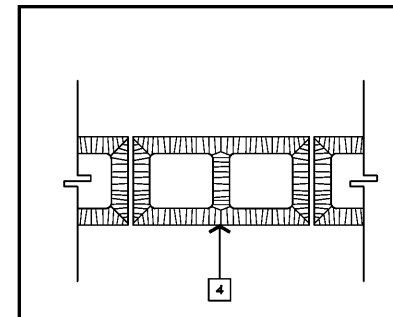


W-2 WALL TYPE
 SCALE 1/2" = 1'-0"

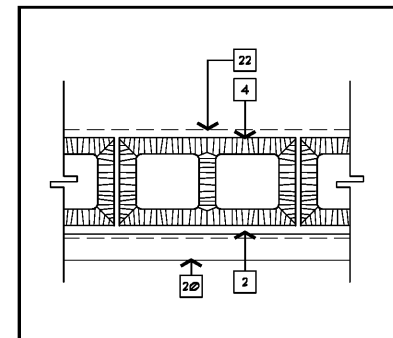

W-3 WALL TYPE
 SCALE 1/2" = 1'-0"

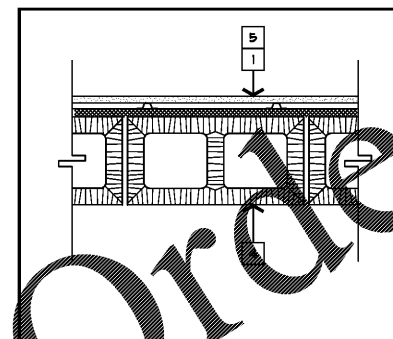

W-4 WALL TYPE
 SCALE 1/2" = 1'-0"

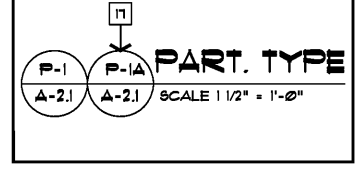

P-1 PART. TYPE
 SCALE 1/2" = 1'-0"

Order Plans @

KCP/Planning & Design Division/Station 23 - 17-C-00037/Project: Fire Station 23 - 17-C-00037 - 17-C-00037/Title: Fire Station 23 - 17-C-00037/Author: PFB/Checked: PFB/Date: 7/28/17/Scale: 1/8" = 1'-0"/Sheet: A-2.1