



TOILET ACCESSORIES


- T1 DOUBLE ROLL SURFACE MOUNTED TOILET TISSUE DISPENSER SIMILAR TO BRADLEY #5234.
- T2 SOAP DISPENSER SIMILAR TO BRADLEY #6324.
- T3 2' x 3' CHANNEL FRAMED MIRROR SIMILAR TO BRADLEY #181.
- T4 2' x 3' FIXED TILT FRAMED MIRROR SIMILAR TO BRADLEY #140.
- T5 SURFACE MOUNTED SOAP DISPENSER SIMILAR TO BRADLEY #6542.
- T6 4' x 3' CHANNEL FRAMED MIRROR SIMILAR TO BRADLEY #181.
- T7 PAPER TOWEL DISPENSER / RECEPTACLE SIM. TO BOBRICK MODEL #B-3942
- T8 GRAB BARS - SIMILAR TO BRADLEY 800-001 SERIES WITH 54" BAR AT SIDE OF WATER CLOSET.
- T9 GRAB BAR SIMILAR TO BRADLEY 800-001 SERIES 36" IN LENGHT.
- T10 CLOTHES HOOK STRIP SIMILAR TO BOBRICK B-985
- T11 EXTRA HEAVY DUTY SHOWER CURTAIN ROD SIM. TO BOBRICK B-6241 WITH VINYL SHOWER CURTAIN SIM. TO BOBRICK 204-2 AND SHOWER CURTAIN HOOKS SIM. TO BOBRICK 204-1

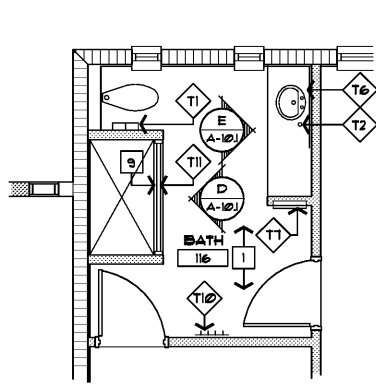


(C) ENLARGED FLOOR PLAN
SCALE 1/4" = 1'-0"

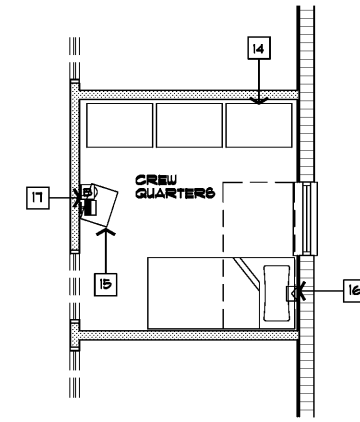


(D) PARTIAL ENLARGED FLOOR PLAN
SCALE 1/4" = 1'-0"

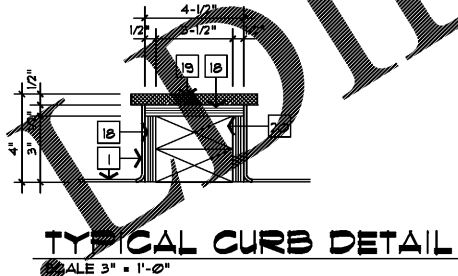


TYPICAL CURB DETAIL
SCALE 3" = 1'-0"

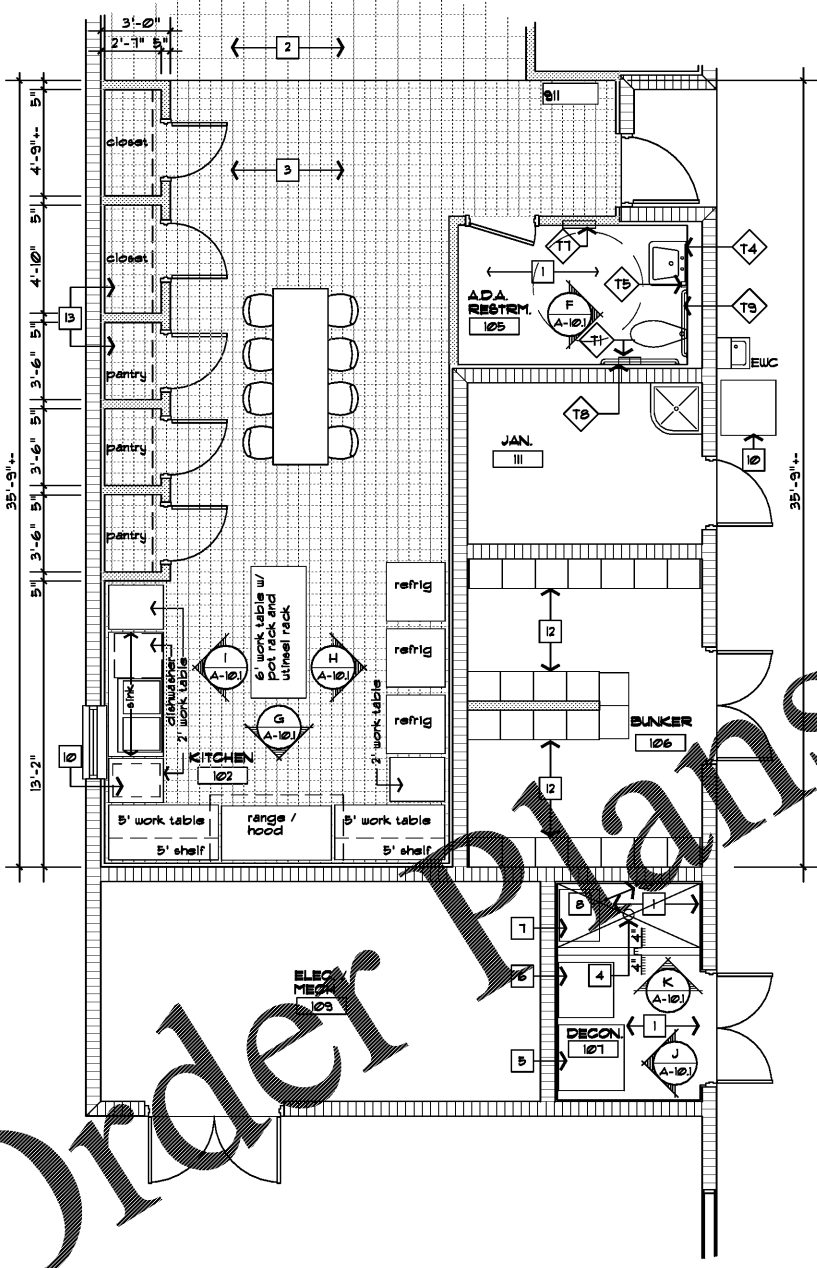

(A) ENLARGED FLOOR PLAN
SCALE 1/4" = 1'-0"

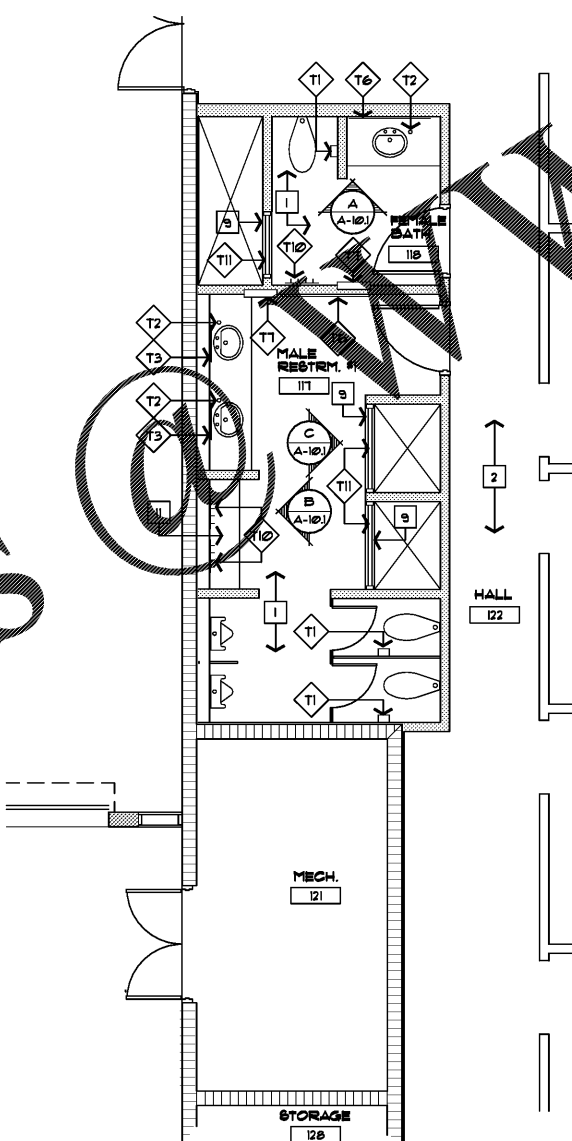

(B) ENLARGED FLOOR PLAN
SCALE 1/4" = 1'-0"

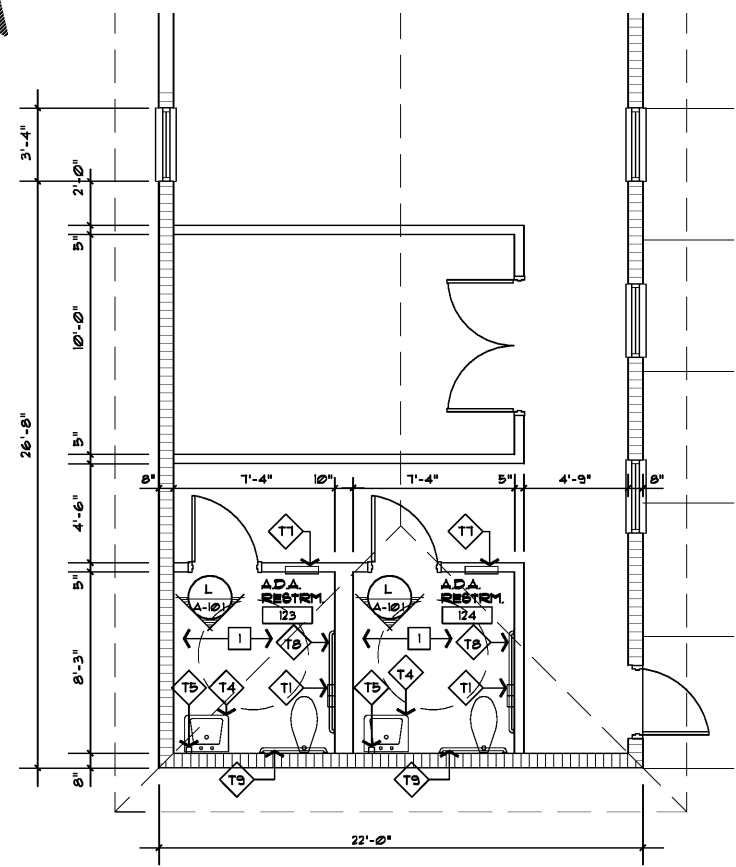

(C) ENLARGED FLOOR PLAN
SCALE 1/4" = 1'-0"

GENERAL NOTES

KEY NOTES

- 1 2" x 2" MOSAIC FLOOR TILE.
- 2 12" x 12" VCT ACCENT COLOR TILE.
- 3 6" x 6" QUARRY TILE
- 4 FLOOR DRAIN - SLOPE FLOOR TO DRAIN.
- 5 COMMERCIAL HEAVY DUTY WASHING MACHINE
- 6 HEAVY DUTY DRYER
- 7 FIBERGLASS SINK WITH HANDS FREE CONTROLS
- 8 HAND HELD SHOWER
- 9 4" CURB
- 10 ICE MACHINE
- 11 1-1/2" THICK x 60" LONG SOLID SURFACE BENCH
- 12 18"Wx21"Dx12"H SOLID WOOD LAMINATE WITH BOTTOM FOOT LOCKER AND TOP LOCK BOX SIMILAR TO THE 302000 SERIES OPEN ACCESS DESIGNER WOOD LOCKER BY SALSBERG INDUSTRIES COLOR SELECTED FROM STANDARD RANGE. WWW.LOCKERS.COM | 800 562-5371 EXTENSION 128, MIKE
- 13 PROVIDE 6 HEAVY DUTY WIRE SHELVES ON HEAVY DUTY BRACKETS FOR EACH CLOSET AND PANTRY TYP.
- 14 FOR EACH CREW ROOM AND CHIEF AND CAPTAIN QUARTERS PROVIDE 3 SOLID 24" x 24" x 12" WOOD LOCKER WITH BOTTOM LOCKER, TOP TRAY LOCKER AND LOCKER DOOR. ALL LOCKERS WITH STANDARD HASP LOCK. SIMILAR TO 30074 DESIGNER GREAT LOCKER BY SALSBERG INDUSTRIES. WWW.LOCKERS.COM | 800 562-5371 EXTENSION 128 MIKE
- 15 WALL MOUNTED TV BRACKETS - 65" AFF. FIELD VERIFY) NOT IN CONTRACT - TO BE INSTALLED BY CITY OF TAMPA
- 16 RELOCATE STROBE FIXTURE TO EXTERIOR WALL TYP. ALL SLEEPING ROOMS REFER TO ELEC. DUGS. FOR MOUNTING HEIGHTS
- 17 911 BELL AND INTERCOM REMOTE STATION AT 58" AFF. (FIELD VERIFY)
- 18 1/2" CEM. BD. - SIM. TO DUROROCK
- 19 1/2" x 5" WIDE TRAVERTINE / MARLE
- 20 P.T. 2x4 CONTINUOUS

ENLARGED FLOOR PLAN



CITY OF TAMPA
CONTRACT ADMINISTRATION
DEPARTMENT
PLANNING AND DESIGN DIVISION
805 E. JACKSON STREET 4 NORTH
TAMPA, FLORIDA 33602
P: 813.274.8456 - F: 813.274.8080
WWW.TAMPAGOV.GOV

James E. Jackson, J. AIA, NOMA
City Architect
Edward D. Rice, AIA
Project Architect
Kevin L. Hamilton, AIA
Project Architect
Thomas A. Hester, Sr., AIA, NOMA
Project Architect

Kimmy C. Tillman
Drafting Technician
Jarry P. Sanders
Drafting Technician
Byron K. Thomas, LEED AP
Drafting Technician

MEP CONSULTANT
GRINER ENGINEERING, INC.
1678 1st. AVENUE NORTH
ST. PETERSBURG, FL 33713

STRUCTURAL CONSULTANT
BILLER REINHART
STRUCTURAL GROUP, INC.
4014 GUNN HWY. SUITE 248
TAMPA, FL 33613

CIVIL CONSULTANT
B M CIVIL LLC
12315 WYCLIFF PLACE
TAMPA, FL 33626

LANDSCAPE CONSULTANT
DAVID CONNER & ASSOCIATES
1509 W. SWANN AVENUE, SUITE 255
TAMPA, FL 33606

FIRE STATION 23
20770 TROUT CREEK DR.
TAMPA, FL 33647

DPW FILE NUMBER

DPW NUMBER
17-C-00037

ISSUE DATE
JULY 28, 2017

DRAWN BY
KIMBEY TILLMAN

REVISIONS

SEAL

SCALE 1/4" = 1'-0"

SHEET NUMBER
A-7.1

X OF X

Order Plans