



CITY OF TAMPA  
 CONTRACT ADMINISTRATION  
 DEPARTMENT  
 PLANNING AND DESIGN DIVISION  
 305 E. JACKSON STREET 4 NORTH  
 TAMPA, FLORIDA 33602  
 p: 813. 274. 8466 - f: 813. 274. 8080  
 url: www.tampagov.net

James E. Jackson, Jr. AIA, NOMA  
 City Architect  
 Edward D. Rice, AIA  
 Project Architect  
 Kevin L. Henika, AIA  
 Project Architect  
 Thomas A. Hester, Sr., AIA, NOMA  
 Project Architect  
 David R. Pagitt  
 Supervisor, Architectural Drafting  
 Kinsey C. Tillman  
 Drafting Technician  
 Jerry P. Sanders  
 Drafting Technician  
 Byron K. Thomas, LEED AP  
 Drafting Technician

MEP CONSULTANT  
**GRINER ENGINEERING, INC.**  
 1628 1st AVENUE NORTH  
 ST. PETERSBURG, FL 33713

STRUCTURAL CONSULTANT  
**BILLER REINHART**  
 STRUCTURAL GROUP, INC.  
 4014 GUNN HWY. SUITE 240  
 TAMPA, FL 33713

CIVIL CONSULTANT  
**B M CIVIL LLC**  
 12315 WYCLIFF PLACE  
 TAMPA, FL 33626

LANDSCAPE CONSULTANT  
**DAVID CONNER & ASSOCIATES**  
 1503 W. SWANN AVENUE SUITE 255  
 TAMPA, FL 33606

FIRE STATION 23  
 20770 TROUT CREEK DR.  
 TAMPA, FL 33647

DPW FILE NUMBER

DPW NUMBER  
 17-C-00037

ISSUE DATE  
 07-28-2017

DRAWN BY

REVISIONS  
 △  
 △  
 △

SEAL

Joseph H. Griner III, P.E. FL. 39491


SCALE: 1/8" = 1'-0"

PLUMBING ROOF PLAN

SHEET NUMBER

P-3.3

X OF X

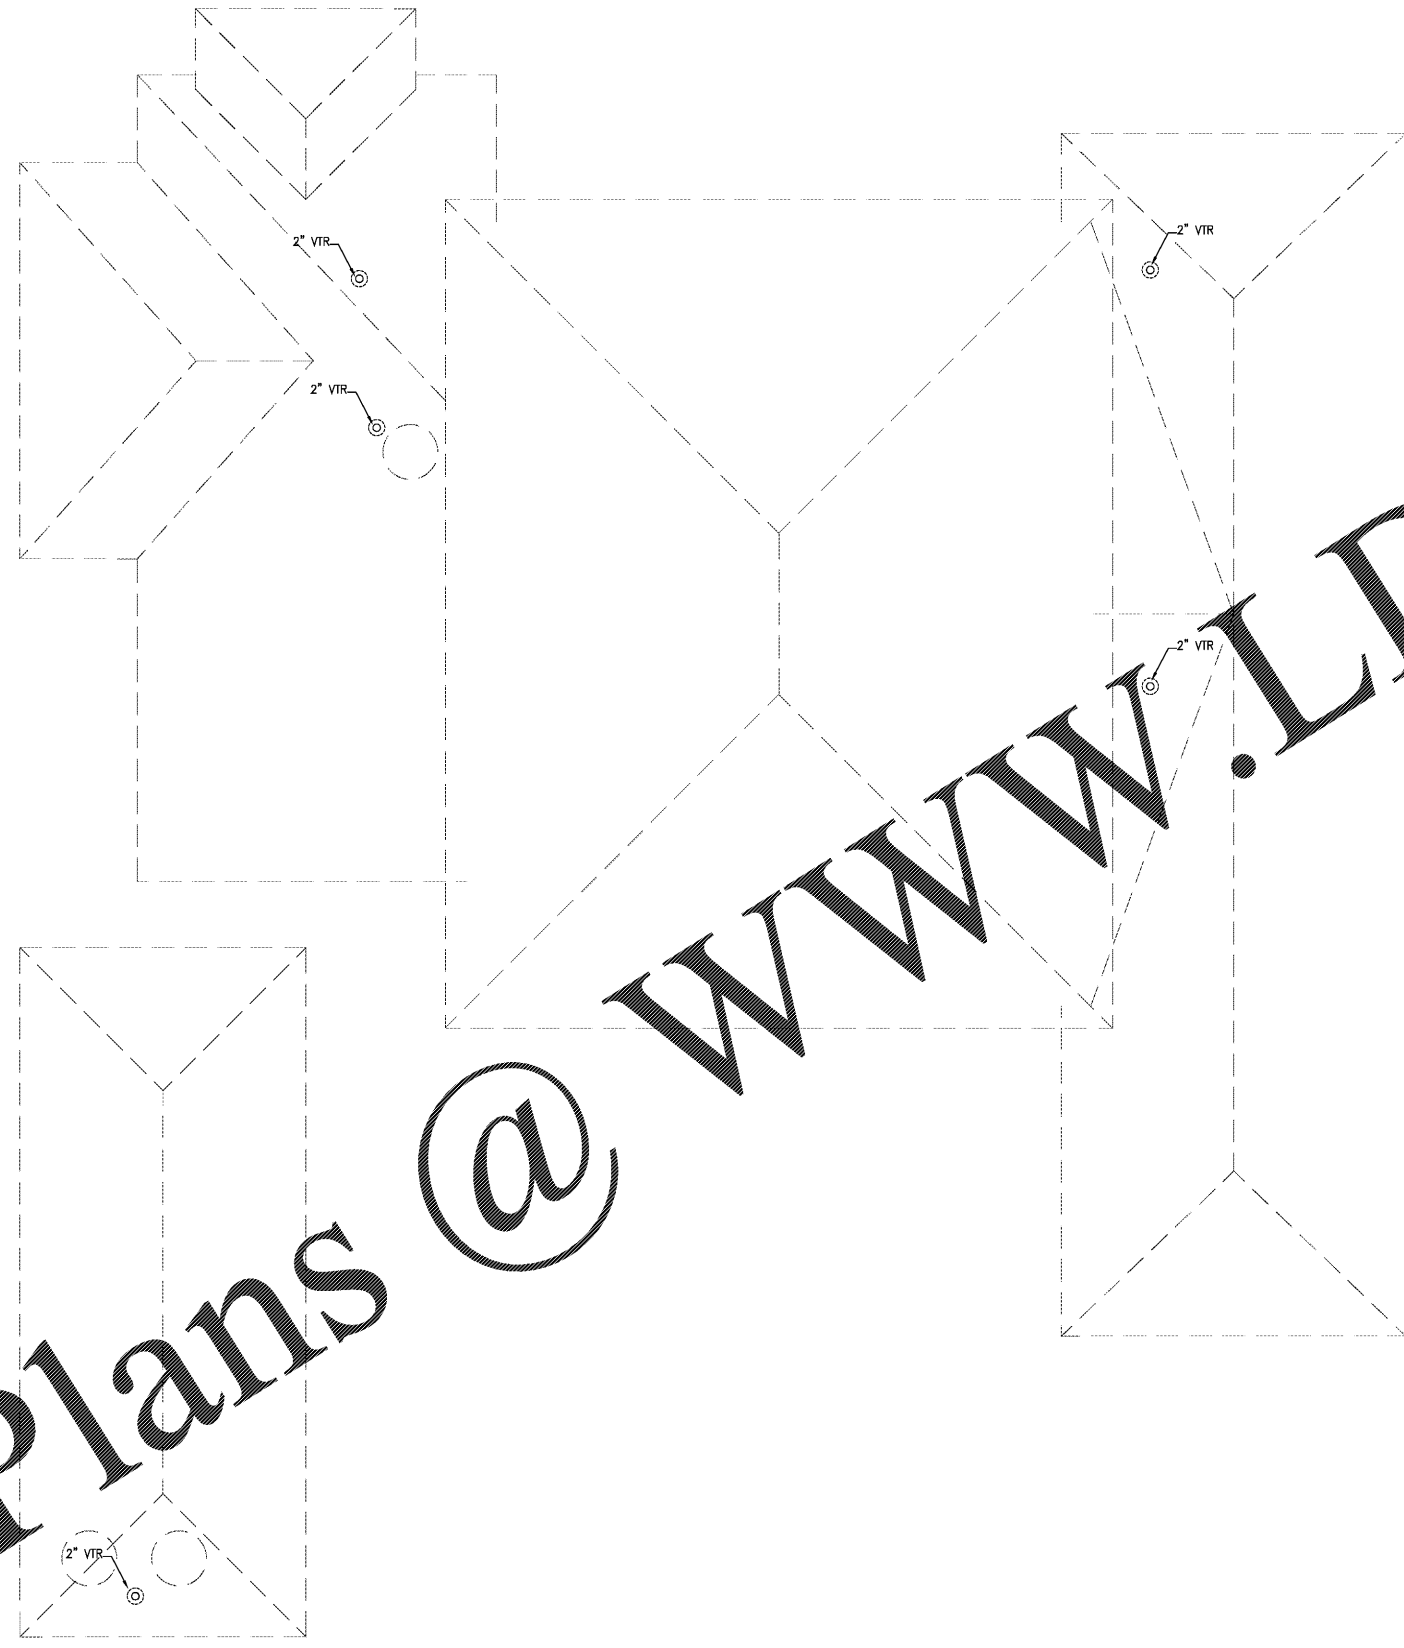

N  
 ROOF PLAN  
 SCALE: 1/8" = 1'-0"

Order Plans @

WWW.LDILine.com

<b>GRINER</b> GRINER ENGINEERING, INC. 1628 First Avenue North St. Petersburg, Florida 33713 Phone: (727)-822-2335 Fax: (727)-821-3361 Certificate of Authorization #3173	Date	06-15-2017
	Drawn	JL
	Designed	JL
	EOR	JHG
	Job no.	17049